
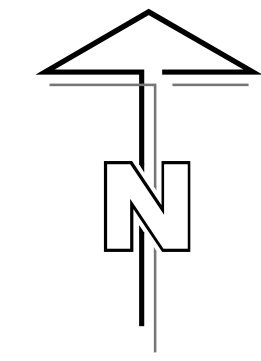


D SIZE 22" x 34" (559mm x 864mm)

PLOT: 07/12/14 9:05:56 AM

UMA FILE NAME: D265-202-02\_02-E-001\_RX.dwg Saved By: jll

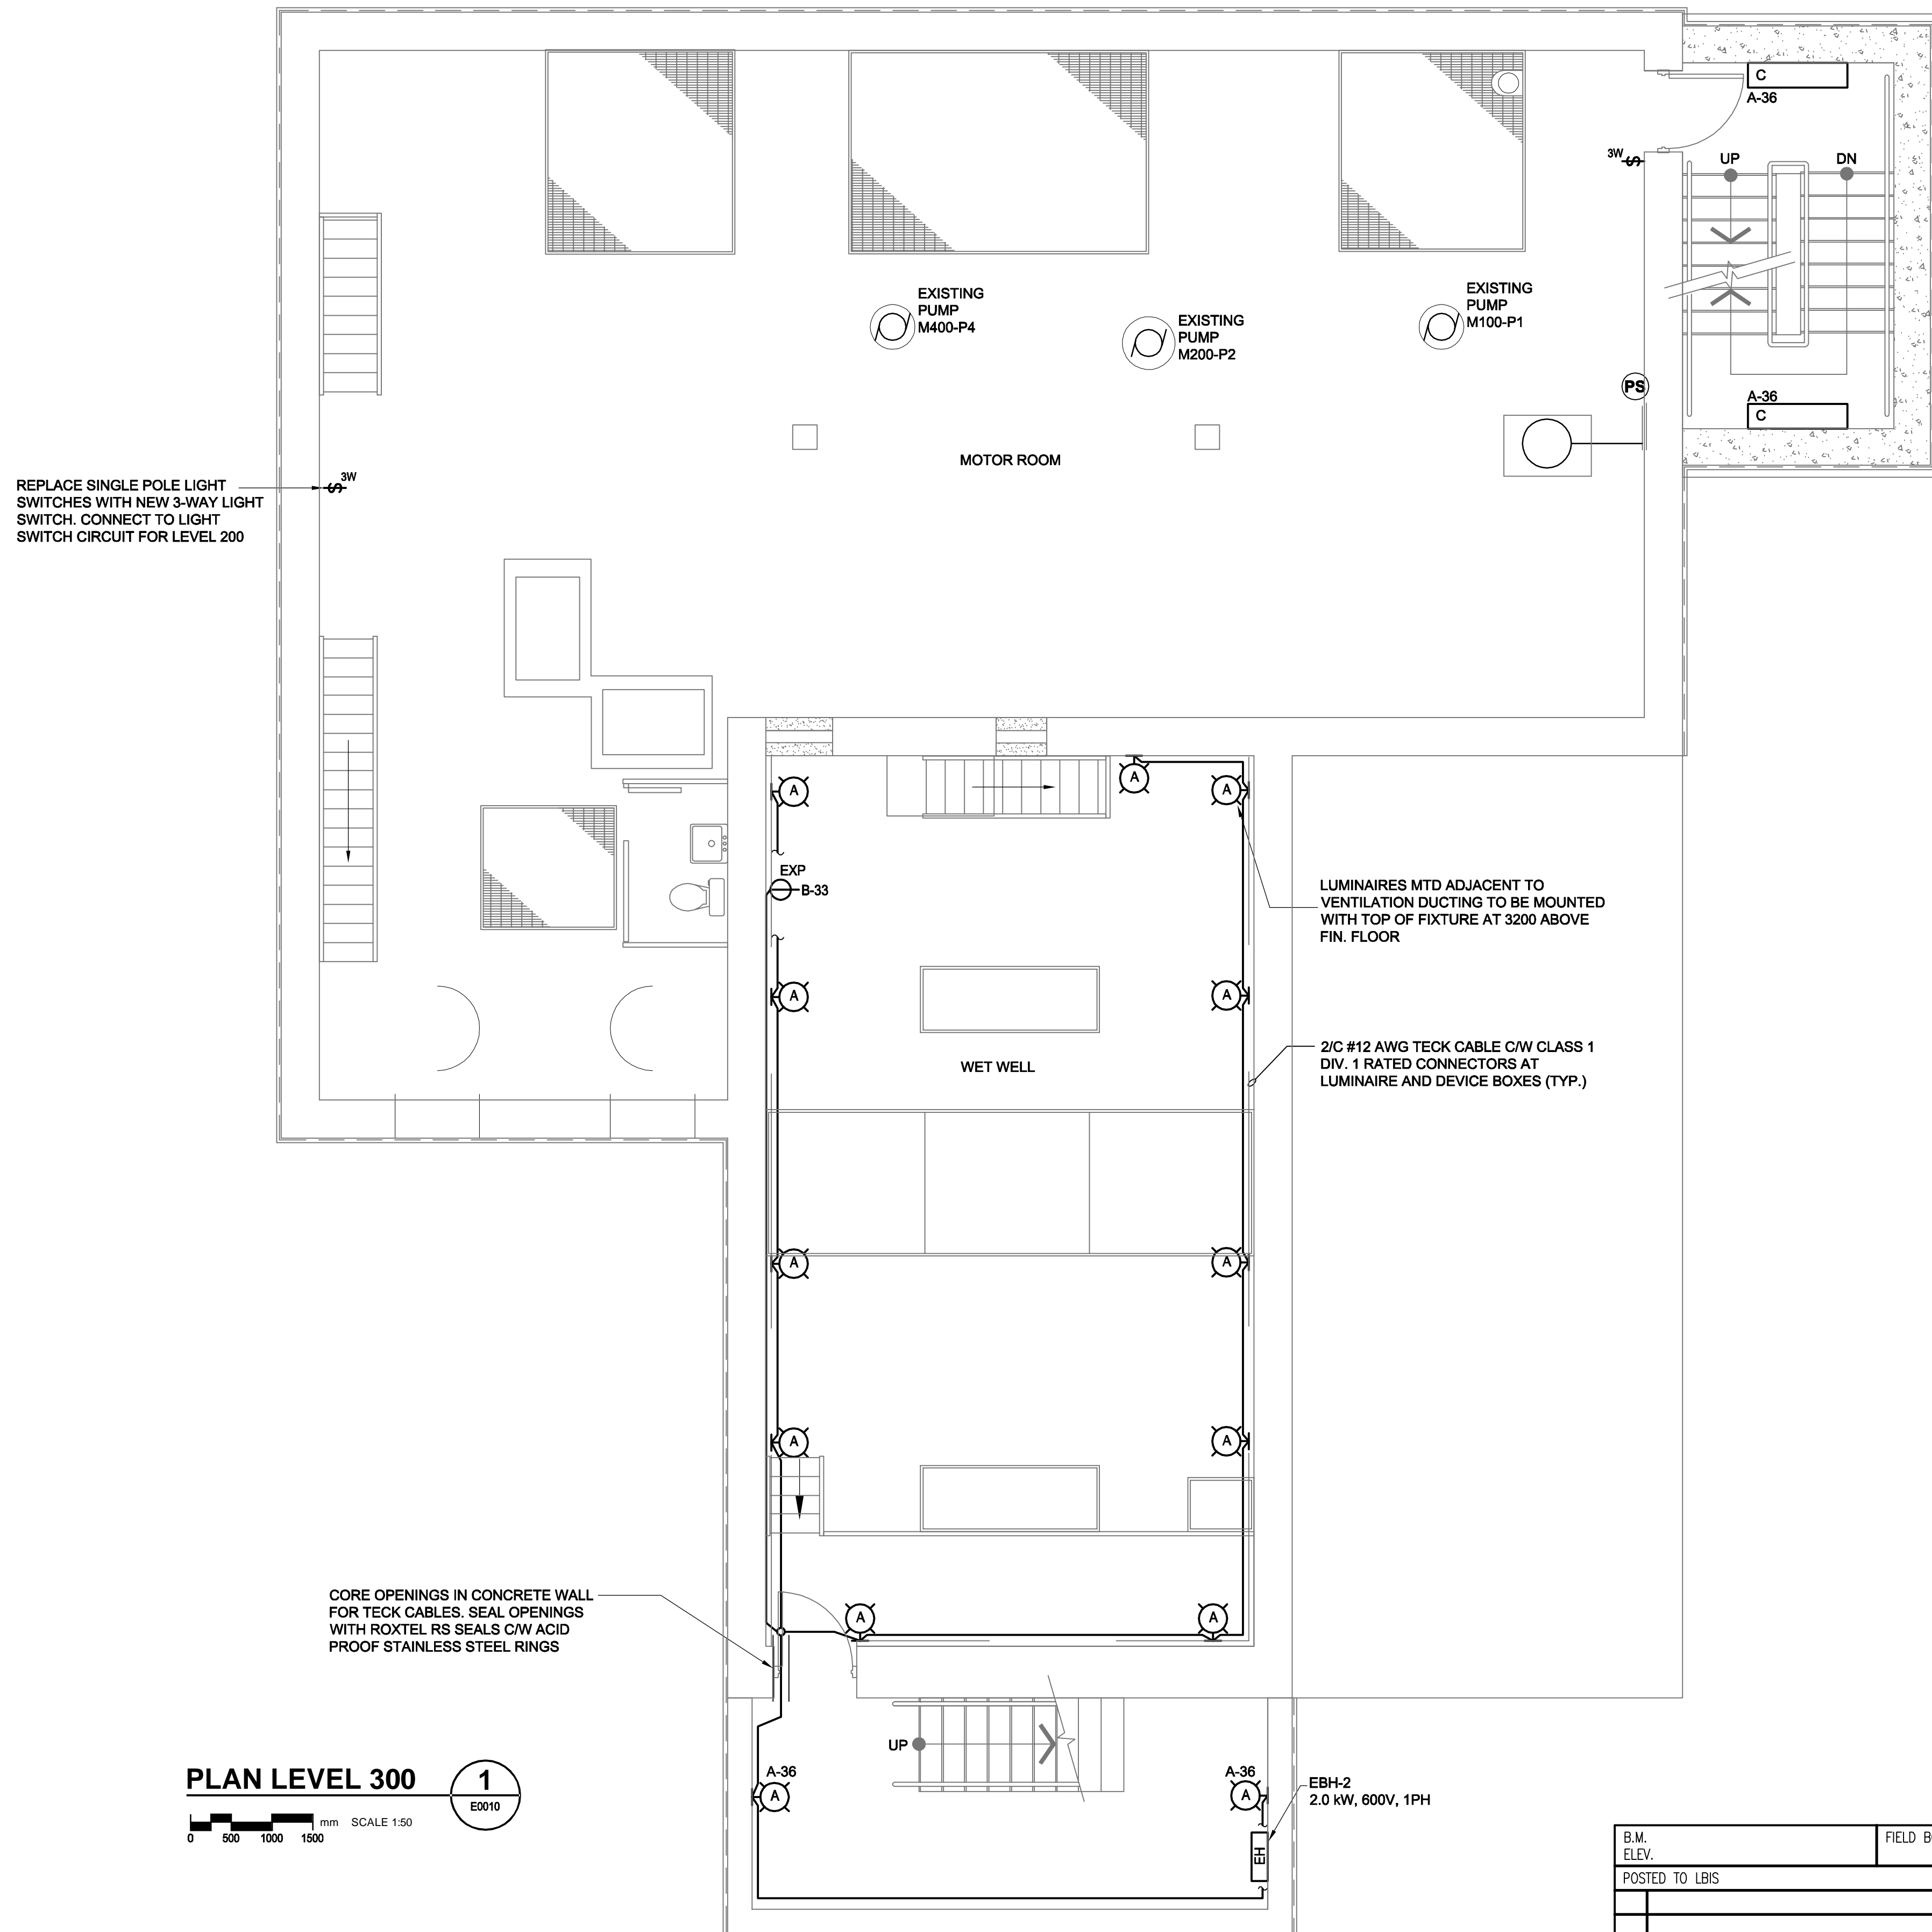

**PLAN LEVEL 300** 1  
E0010  
0 500 1000 1500 mm SCALE 1:50

**APEGM**  
Certificate of Authorization  
UMA Engineering Ltd. (MB)  
No. 256 Date: 07/12/14

QL	RS	BM	BM	BF
DRN	CHK	DES	ENG	IDR
UMA REVIEW				

B.M. ELEV.	FIELD BOOK #:	UMA   AECOM	
POSTED TO LBIS		DESIGNED BY <b>BM/LK</b>	CHECKED BY -----
		DRAWN BY <b>SCK</b>	APPROVED BY -
<b>D</b> ISSUED FOR BID	07/12/14	LJV	
<b>C</b> ISSUED FOR 100% REVIEW	07/11/09	SCK	
<b>B</b> ISSUED FOR ZONING	07/08/21	SCK	
<b>A</b> ISSUED FOR 80% REVIEW	07/06/18	SCK	
NO. REVISIONS	DATE	BY	FILENAME: D265-202-02_02-E-0301_RX.dwg

HOR. SCALE AS NOTED	RELEASED FOR CONSTRUCTION
VERTICAL AS NOTED	
DATE 07/05/09	DATE

ENGINEER'S SEAL  
ISSUE / REVISION D  
ISSUED FOR BID  
WAS SEALED BY  
B.L. MOORE  
AND DATED  
07/12/14

**THE CITY OF WINNIPEG**  
WATER AND WASTE DEPARTMENT

**PERIMETER ROAD PUMPING STATION UPGRADES**  
Contract B - Building Upgrades

Electrical - Lighting Layout  
LEVEL 300 FLOOR PLAN

CITY DRAWING NUMBER	SHEET	REV.	SIZE
1-0111L-E0009	001	D	D