
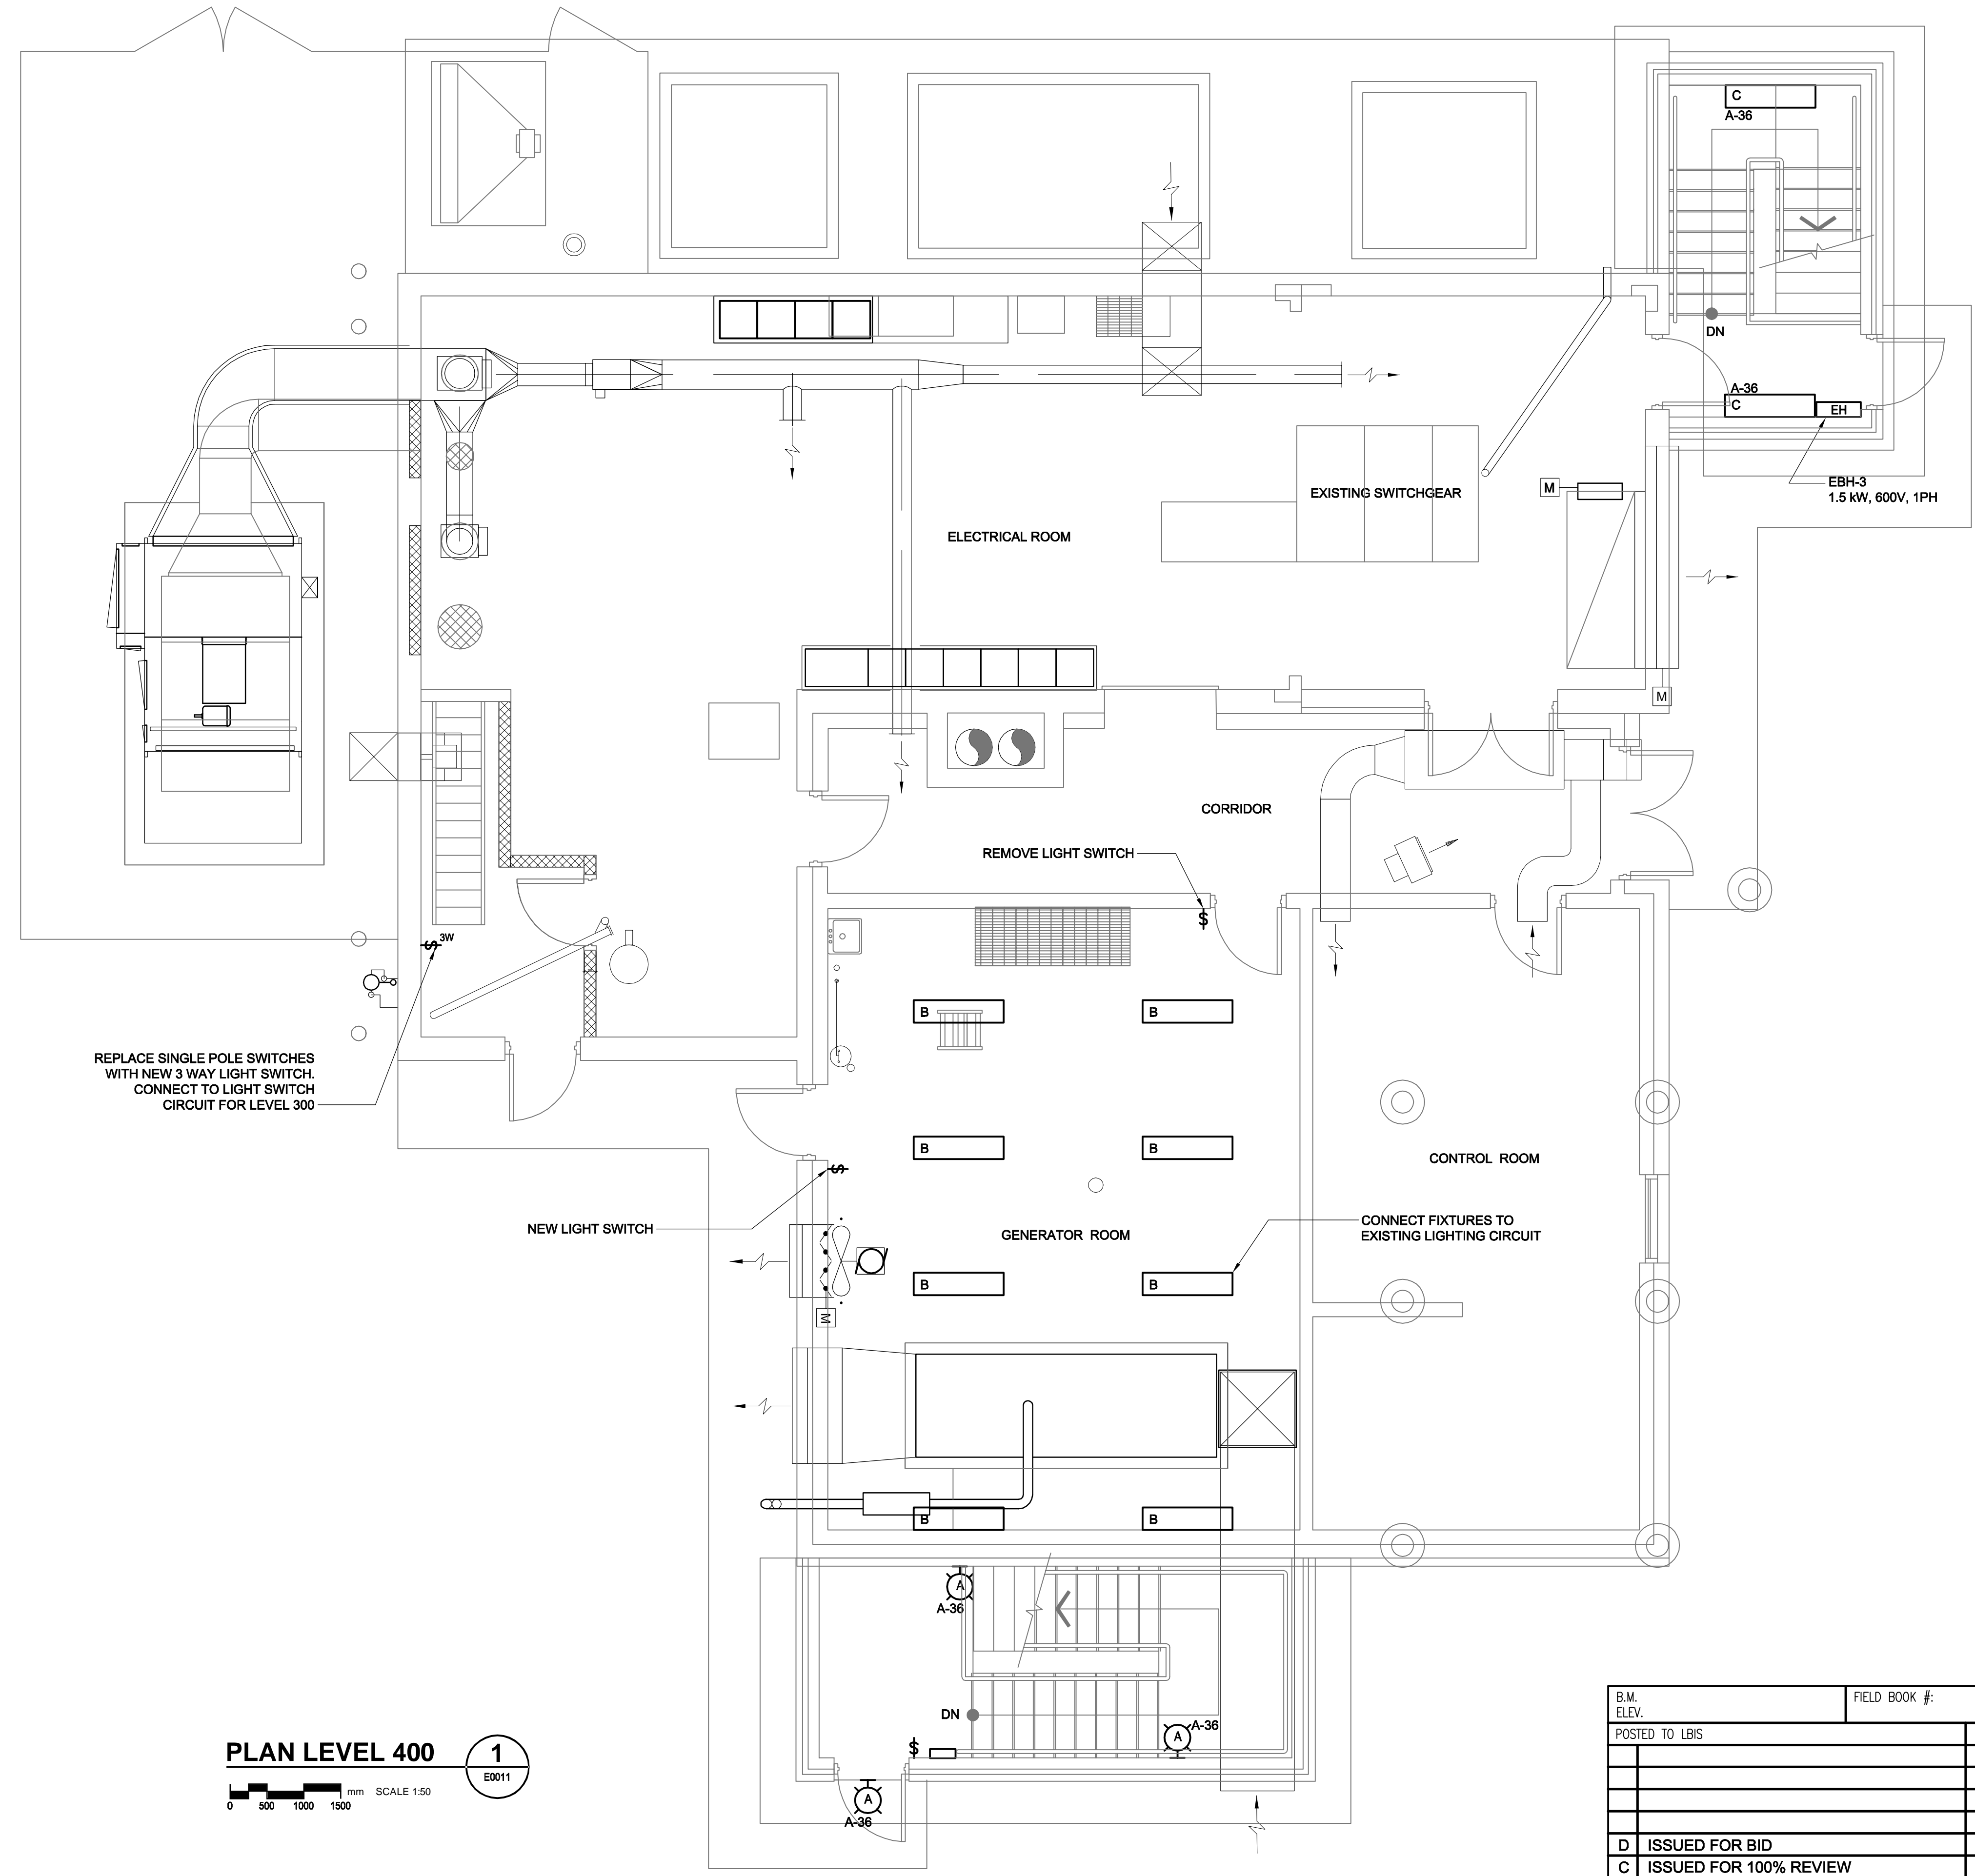


D SIZE 22" x 34" (559mm x 864mm)

PLOT: 07/12/14 9:05:04 AM

UMA FILE NAME: D265-202-02_02-E-0401_RX.dwg Saved By: jll

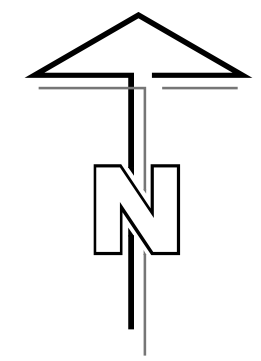

REPLACE SINGLE POLE SWITCHES WITH NEW 3 WAY LIGHT SWITCH. CONNECT TO LIGHT SWITCH CIRCUIT FOR LEVEL 300

PLAN LEVEL 400
SCALE 1:50
0 500 1000 1500 mm

1
E0011

APEGM
Certificate of Authorization
UMA Engineering Ltd. (MB)
No. 256 Date: 07/12/14

QL	RS	BM	BM	BF
DRN	CHK	DES	ENG	IDR
UMA REVIEW				

B.M. ELEV.	FIELD BOOK #:	UMA AECOM	
POSTED TO LBIS		DESIGNED BY BM/LK	CHECKED BY -----
		DRAWN BY SCK	APPROVED BY -
D ISSUED FOR BID	07/12/14	LJV	
C ISSUED FOR 100% REVIEW	07/11/09	SCK	
B ISSUED FOR ZONING	07/08/21	SCK	
A ISSUED FOR 80% REVIEW	07/06/18	SCK	
NO. REVISIONS	DATE	BY	FILENAME: D265-202-02_02-E-0401_RX.dwg

© 2009 UMA ENGINEERING LTD. ALL RIGHTS RESERVED.	
HOR. SCALE AS NOTED	RELEASED FOR CONSTRUCTION
VERTICAL AS NOTED	
DATE 07/05/09	DATE

ENGINEER'S SEAL
ISSUE / REVISION D
ISSUED FOR BID
WAS SEALED BY
B.L. MOORE
AND DATED
07/12/14

THE CITY OF WINNIPEG
WATER AND WASTE DEPARTMENT

PERIMETER ROAD PUMPING STATION UPGRADES
Contract B - Building Upgrades

Electrical - Lighting Layout
LEVEL 400 FLOOR PLAN

CITY DRAWING NUMBER	SHEET	REV.	SIZE
1-0111L-E0010	001	D	D