

**IMPORTANT: ASBESTOS NOTIFICATION AND ACKNOWLEDGMENT**

Every effort has been made to identify known asbestos containing materials within the areas of the proposed work and where in direct conflict or where posing a hazard, to remove it by proper controlled means before construction. As a precautionary measure, where material is encountered by trades and contractors that is suspected or suspicious, the Trade/Contractor/Subcontractor is to contact the Water and Waste Department who will have samples taken and tested to confirm its composition.


Ms. Reg. 53-88 (Workplace Health Hazard Regulation), Ms. Reg. 100-88R (Fibrous and Siliceous Regulation) and associated Guidelines apply to all maintenance and renovation work that may disturb asbestos or suspect asbestos-containing materials in the Workplace. Such regulations and guidelines state that any disturbance of asbestos-containing materials may only be performed by workers or by an outside contractor who have first received the required training in asbestos-related precautions.

WORKING WITH ASBESTOS CAN BE DANGEROUS. INHALING ASBESTOS FIBERS CAN CAUSE VARIOUS TYPES OF LUNG DISEASE INCLUDING CANCER. SMOKING INCREASES THE RISK OF LUNG CANCER FROM ASBESTOS EXPOSURE.

**ACKNOWLEDGMENT:**

In undertaking the work of this project, we the trade or contractor agree to perform our work in such a manner so as NOT to disturb any asbestos-containing materials without:

1. giving notice to the appropriate supervisor, individual manager and/or project coordinator at the Water And Waste Department that known or suspected asbestos-containing material(s) will be/needs to be disturbed, or
2. halting work and giving notice to the appropriate individual manager and/or project coordinator at the Water And Waste Department when unforeseen suspected asbestos-containing materials are uncovered during the provisions of services/materials.

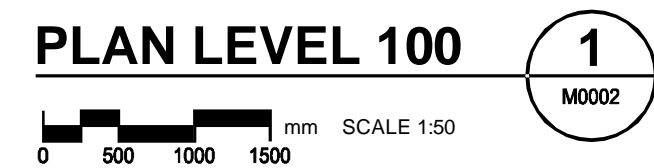

**NOTE:**  
CAUTION: EXISTING DUCTING CONTAINS ASBESTOS, WET WELL AREAS ARE CONSIDERED CONFINED SPACES AND SUITABLE PROCEDURES MUST BE FOLLOWED.

**APEGM**  
Certificate of Authorization  
UMA Engineering Ltd. (MB)  
No. 256 Date: 07/12/14

RS	ALS	CC	CC	BP
DRN	CHK	DES	ENG	IDR
UMA REVIEW				

B.M. ELEV.	FIELD BOOK #:	UMA   AECOM	
POSTED TO LBIS		DESIGNED BY: CAC	CHECKED BY: -----
		DRAWN BY: RJP	APPROVED BY: -
D ISSUED FOR BID	07/12/14	RS	
C ISSUED FOR 100% REVIEW	07/11/09	RS	
B ISSUED FOR ZONING	07/08/21	ALS	
A ISSUED FOR 80% REVIEW	07/06/18	RJP	
NO. REVISIONS	DATE	BY	FILENAME: D265-202-02_01-M-0002_RX.dwg

© 2008 UMA ENGINEERING LTD. ALL RIGHTS RESERVED.	
HOR. SCALE AS NOTED	RELEASED FOR CONSTRUCTION
VERTICAL AS NOTED	
DATE 07/05/09	DATE

ENGINEER'S SEAL  
ISSUE / REVISION  
ISSUED FOR BID  
WAS SEALED BY  
CLAUDE COURCHAINE  
AND DATED  
07/12/14

**THE CITY OF WINNIPEG**  
WATER AND WASTE DEPARTMENT

**PERIMETER ROAD PUMPING STATION UPGRADES**  
Contract B - Building Upgrades

Mechanical - Demolition  
LEVEL 100 FLOOR PLAN

CITY DRAWING NUMBER	SHEET	REV.	SIZE
1-01111L-M0002	001	D	D