
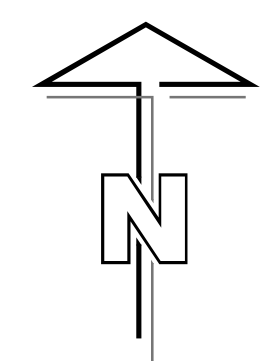


D SIZE 22" x 34" (559mm x 864mm)

PLOT: 18/12/2007 10:29:37 AM

UMA FILE NAME: D265-202-02_01-M-0010_RX.dwg Saved By: rsbetween

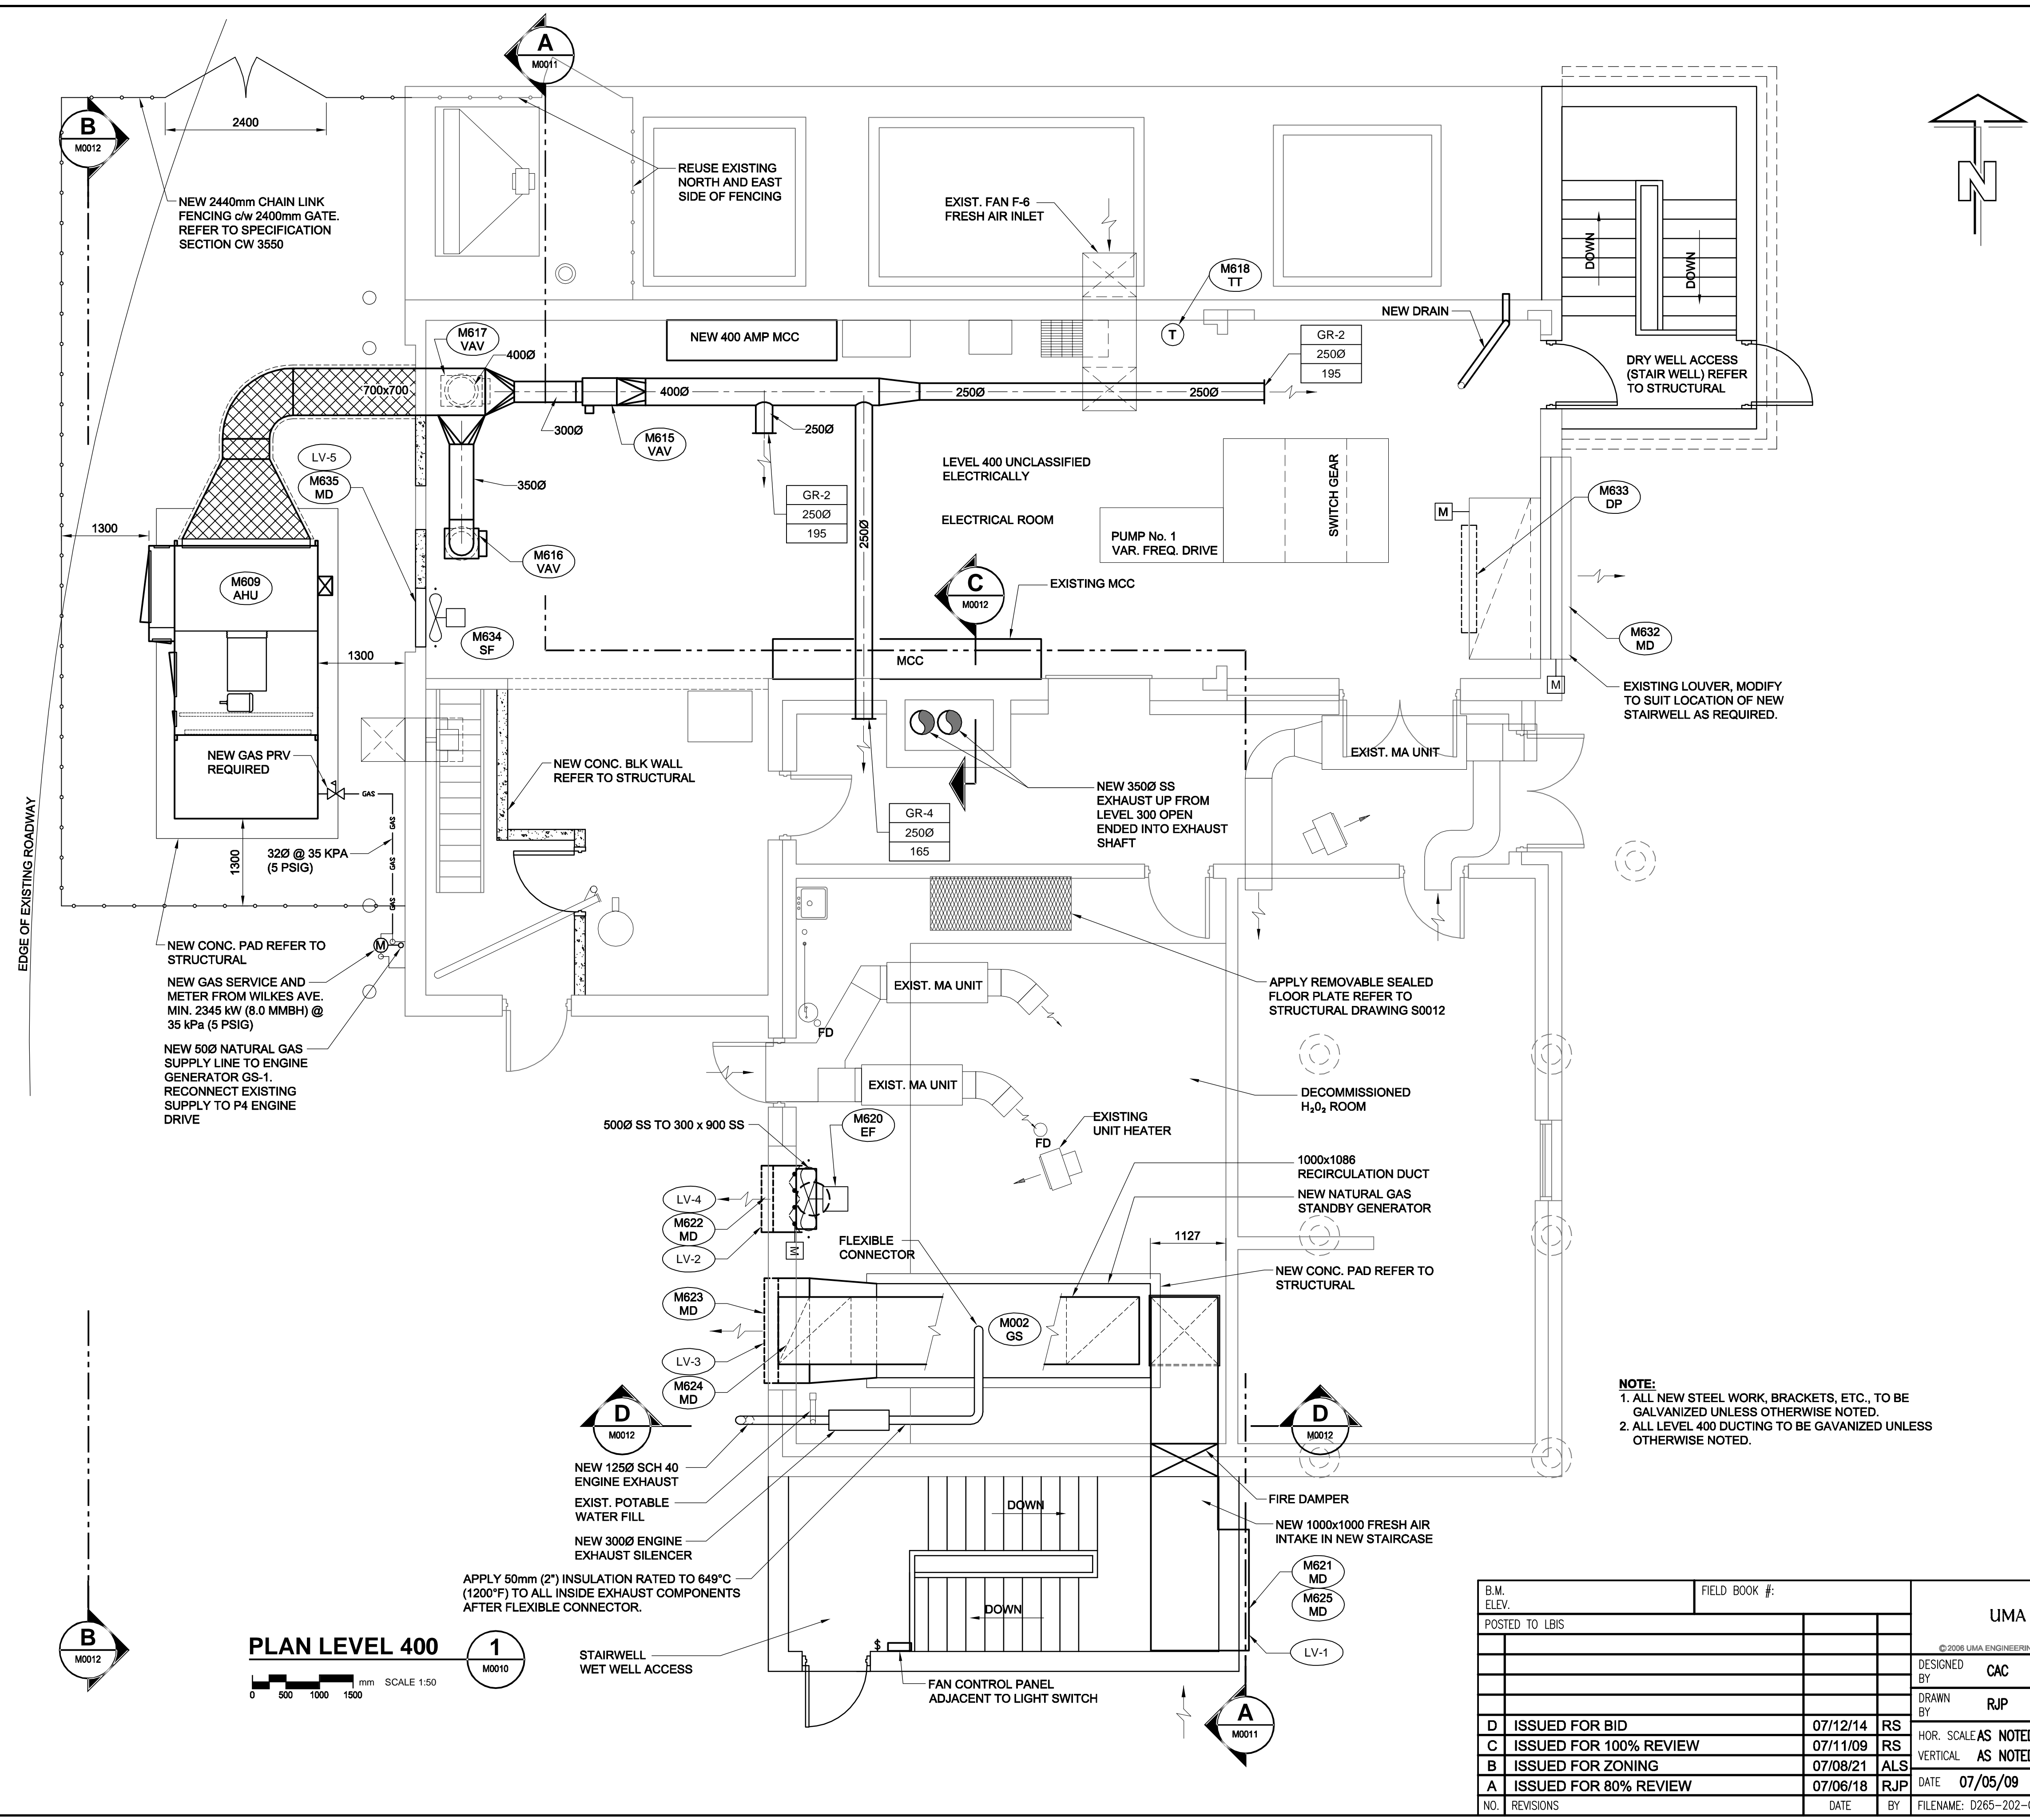

NOTE:
 1. ALL NEW STEEL WORK, BRACKETS, ETC., TO BE GALVANIZED UNLESS OTHERWISE NOTED.
 2. ALL LEVEL 400 DUCTING TO BE GALVANIZED UNLESS OTHERWISE NOTED.

PLAN LEVEL 400
 SCALE 1:50
 0 500 1000 1500 mm

APEGM
 Certificate of Authorization
 UMA Engineering Ltd. (MB)
 No. 256 Date: 07/12/14

RS	ALS	CC	CC	BP
DRN	CHK	DES	ENG	IDR
UMA REVIEW				

B.M. ELEV.	FIELD BOOK #:	UMA AECOM	
POSTED TO LBIS		DESIGNED BY CAC	CHECKED BY -----
		DRAWN BY RJP	APPROVED BY -
D ISSUED FOR BID	07/12/14	RS	HOR. SCALE AS NOTED
C ISSUED FOR 100% REVIEW	07/11/09	RS	VERTICAL AS NOTED
B ISSUED FOR ZONING	07/08/21	ALS	RELEASED FOR CONSTRUCTION
A ISSUED FOR 80% REVIEW	07/06/18	RJP	DATE 07/05/09
NO. REVISIONS	DATE	BY	FILENAME: D265-202-02_01-M-0010_RX.dwg

ENGINEER'S SEAL
 ISSUE / REVISION ISSUED FOR BID WAS SEALED BY CLAUDE COURCHAINE AND DATED 07/12/14

THE CITY OF WINNIPEG
 WATER AND WASTE DEPARTMENT
PERIMETER ROAD PUMPING STATION UPGRADES
 Contract B - Building Upgrades
 Mechanical - New Construction
 LEVEL 400 FLOOR PLAN
 CITY DRAWING NUMBER: 1-01111L-M0010
 SHEET REV. SIZE: 001 D D