


UMA FILE NAME: F833-001-01_01-14-2004_RK-01.dwg
 DATE: 2007.02.21
 DESCRIPTION: ROOF PLAN HVAC
 PROJECT No: F833-001-01
 PLOT: 07/07/20 11:52:10 AM
 ADDRESS: 989 Sargent St. Winnipeg, Manitoba

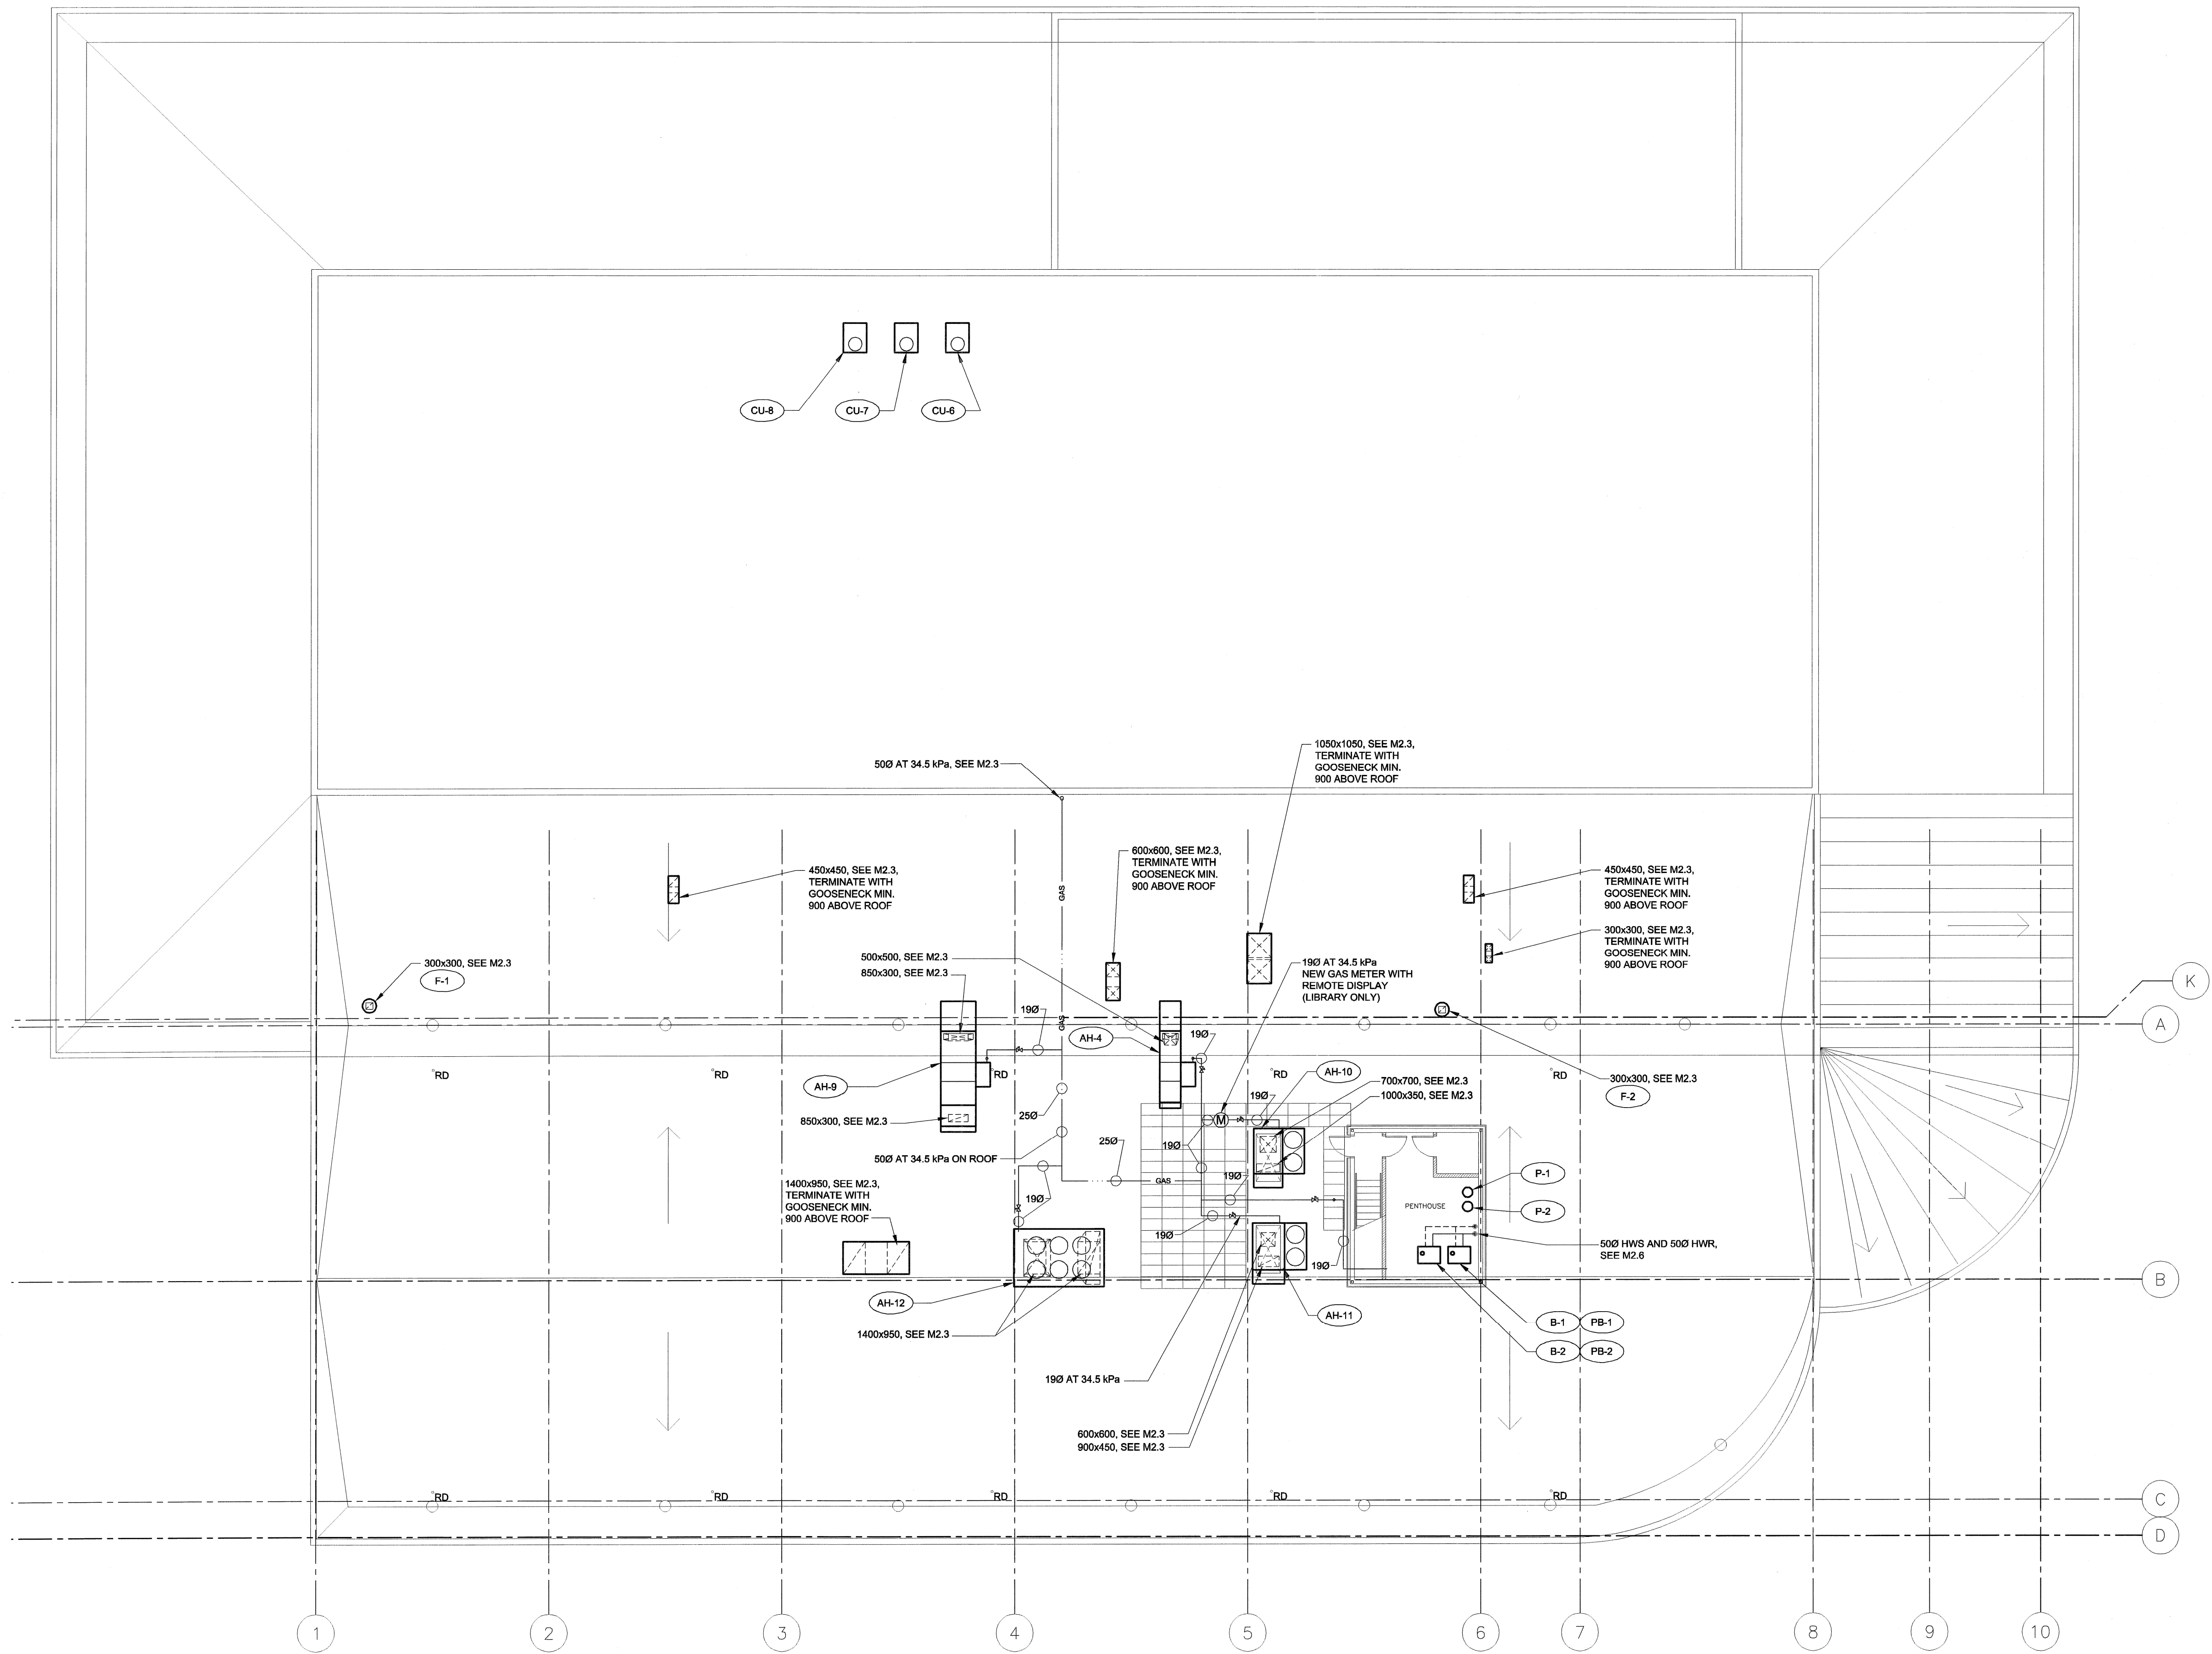

PLAN
 1
 M2.4
 0 1500 3000 4500 mm SCALE 1:150
 ROOF PLAN HVAC NEW CONSTRUCTION

UMA | AECOM

© 2007 UMA ENGINEERING LTD. ALL RIGHTS RESERVED.

APEGM
 Certificate of Authorization
 UMA Engineering Ltd. (MB)
 No. 256 Date: 07/07/23

UMA | AECOM REVIEW

| 0 | ISSUED FOR TENDER | RJP | 07/07/23 |
|-----|----------------------|-----|----------|
| NO. | REVISION/DESCRIPTION | BY | DATE |

SEALS

PROVINCE OF MANITOBA
 July 20, 2007
 B.M.
 PETERSON
 REGISTERED PROFESSIONAL ENGINEER

DRAWN BY: RJP CHECKED BY: USER APPROVAL APPROVED
 DATE: 2007.07.17

Winnipeg CITY OF WINNIPEG
 PLANNING, PROPERTY &
 DEVELOPMENT DEPARTMENT
 CIVIC ACCOMMODATIONS DIVISION
 300 - 65 GARRY ST. R3C 4K4

PROJECT
 Construction of Cindy Klassen
 Recreation Complex Facility
 Enhancement Project
 999 Sargent St. Winnipeg, Manitoba

SHEET TITLE
 Mechanical
 Roof Plan HVAC
 New Construction

SCALE: 1:150 PROJECT NO.: 2005-059 SHEET NO.: M2.4

DRAWING SHEET SIZE: A1 (841mm x 594mm) PLOT 1:1