


- CONSTRUCTION NOTES:**
1. ALL CONSTRUCTION AND PRODUCTS INCORPORATED IN THE WORK SHALL BE IN ACCORDANCE WITH THE CITY OF WINNIPEG STANDARD CONSTRUCTION SPECIFICATIONS, LATEST EDITION, AND BE REGISTERED IN THE CITY OF WINNIPEG LISTING OF APPROVED PRODUCTS.
 2. LOCATION OF UNDERGROUND STRUCTURES AS SHOWN ARE BASED ON THE BEST INFORMATION AVAILABLE. NO GUARANTEE IS GIVEN THAT ALL EXISTING UTILITIES ARE SHOWN OR THAT THE GIVEN LOCATIONS ARE EXACT.
 3. CONFIRMATION OF EXISTENCE AND EXACT LOCATION OF ALL SERVICES MUST BE OBTAINED FROM THE INDIVIDUAL UTILITIES BEFORE PROCEEDING WITH CONSTRUCTION. LOCATION AND ELEVATION OF EXISTING WORKS TO BE VERIFIED BY THE CONTRACTOR PRIOR TO CONSTRUCTION. IT IS THE RESPONSIBILITY OF THE CONTRACTOR TO VERIFY THE LOCATIONS OF SUCH UTILITIES, PIPES, SURVEY MARKERS, OR STRUCTURES, AND TO NOTIFY ALL RELEVANT UTILITIES PRIOR TO COMMENCEMENT OF CONSTRUCTION. THE CONTRACTOR SHALL NOTIFY THE CONTRACT ADMINISTRATOR OF ANY ERROR OR OMISSION PRIOR TO CONSTRUCTION.
 4. MEASUREMENTS ARE IN METRIC. WHOLE NUMBERS INDICATE MILLIMETRES, DECIMALIZED NUMBERS INDICATE METRES.
 5. ALL REGRADED/DISTURBED GRAVEL AREAS TO RECEIVE GRAVEL TO SPECIFIED GRADE UNLESS NOTED OTHERWISE.
 6. ALL AREAS AFFECTED BY CONSTRUCTION TO BE RESTORED TO THE ORIGINAL CONDITION OR BETTER UNLESS NOTED OTHERWISE ON THE DRAWING.
 7. INSTALL CATCH BASINS AS PER C.O.W. SD-025 AND CATCH PITS AS PER C.O.W. SD-023 C/W GRATED FRAME AND COVER.

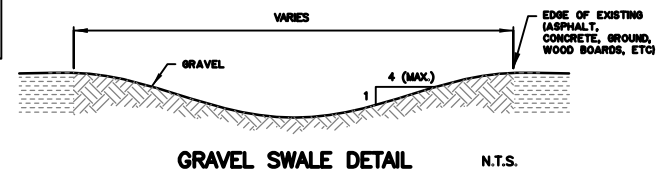

METRIC
WHOLE NUMBERS INDICATE MILLIMETRES
DECIMALIZED NUMBERS INDICATE METRES

APECM
Certificate of Authorization
Canadian Councils Limited Partnership
No. 488 Expiry April 03, 2008

150 mm WM	WATERMAIN	150 mm WM	HYDRO	150 mm WM	WATERMAIN
+	HYDRANT	+	MTS	+	HYDRANT
o	VALVE	o	GRASS	o	VALVE
250 mm LDS	LAND DRAINAGE SEWER	250 mm LDS	SWALE	300 mm LDS	SEWER
250 mm CS	COMBINED SEWER	250 mm CS	CURB RENEWAL	300 mm LDS	SEWER
o	MANHOLE	o	ASPHALT		
□	CATCH BASIN (CB)	□	ELEVATIONS		SOUTH/EAST P
△	CATCH PIT (CP)	△	PROPERTY LINE		NORTH/WEST P
o	SIGN	o	SURVEY BAR		PROFILE
o	LAMP STANDARD	o	CURB STOP		SOUTH/EAST GUTTER
o	GAS	o	RAMP CURB		NORTH/WEST GUTTER
---	EXISTING	---	LEGEND - PLAN	---	EXISTING
---	LEGEND - PLAN	---	LEGEND - PROFILE	---	NEW

LOCATION APPROVED UNDERGROUND STRUCTURES

DATE: _____

NOTE:
LOCATION OF UNDERGROUND STRUCTURES AS SHOWN ARE BASED ON THE BEST INFORMATION AVAILABLE. BUT NO GUARANTEE IS GIVEN THAT ALL EXISTING UTILITIES ARE SHOWN OR THAT THE GIVEN LOCATIONS ARE EXACT. CONFIRMATION OF EXISTENCE AND EXACT LOCATION OF ALL SERVICES MUST BE OBTAINED FROM THE INDIVIDUAL UTILITIES BEFORE PROCEEDING WITH CONSTRUCTION.

DESIGNED BY: W.D.M. CHECKED BY: D.T.B.

DRAWN BY: W.D.M. APPROVED BY: B.D.E.

HOR. SCALE: 1:800

DATE: July 24, 2007

GENIVAR
600-5 DONALD STREET
WINNIPEG, MB R3L 2T4
Tel: (204)477-6650
Fax: (204)474-2864

ENGINEER'S SEAL
PROVINCE OF MANITOBA
D.T. Blackburn
Member
23146
REGISTERED PROFESSIONAL ENGINEER

CONSULTANT DRAWING NO. 07101C02

THE CITY OF WINNIPEG
PUBLIC WORKS DEPARTMENT

ST NORBERT COMMUNITY CENTER DRAINAGE IMPROVEMENT PROJECT

PROPOSED SITE PLAN

CITY DRAWING NUMBER: 535-2007-C02
SHEET 2 OF 2

REV. 2 0

L:\Projects\2007\WE-07-101-WE\Drawings\02 Working Drawings\04 Civil\submissions\535-2007_DRAWING_C02-R0.dwg, 7/30/2007 8:35:47 AM