


BASEMENT FLOOR PLAN - ELECTRICAL LIGHTING
SCALE: 1/4"=1'-0"

| TYPE | QTY. | MANUFACTURER | CATALOGUE No. | LAMP | DESCRIPTION |
|------|------|--------------|-----------------------------|---------------------------|--|
| (A) | 11 | LIGHTOLIER | QHE2GPFOP228 | 2X54W, T8HO | 2'X4' RECESSED MOUNT, HIGH EFFICIENCY FLUORESCENT FIXTURE, 120V, 1PH |
| (A1) | 3 | LIGHTOLIER | QHE2GPFOP228 | 2X54W, T8HO | 2'X4' RECESSED MOUNT, HIGH EFFICIENCY FLUORESCENT FIXTURE, 120V, 1PH. WIRE AS NIGHT LIGHT. |
| (B2) | 4 | CFI | SLB2SFSVA232120CA | 2X32W, T8 | 2'X4' SURFACE BOX FLUORESCENT FIXTURE WITH T8 LAMPS AND PRISMATIC LENS, 120V, 1PH |
| (B3) | 9 | CFI | SLB2SFSVA332120C1 | 3X32W, T8 | 2'X4' SURFACE BOX FLUORESCENT FIXTURES WITH T8 LAMPS AND PRISMATIC LENS, 120V, 1PH |
| (B4) | 1 | CFI | SLB2SFSVA432120CJ | 4X32W, T8 | 2'X4' SURFACE BOX FLUORESCENT FIXTURES WITH T8 LAMPS AND PRISMATIC LENS, 120V, 1PH |
| (C) | 12 | CFI | CSW148-120SOZO | 2X32W, T8 | CFI MODEL CSW148-120SOZO 48" X 4 1/2" CUBELITE C/W ELECTRONIC BALLAST AND OPAL ACRYLIC DIFFUSER, 120V, 1PH. COLOR: WHITE |
| (C2) | 1 | CFI | CSW148-120SOZO | 2X32W, T8 | CFI MODEL CSW148-120SOZO 48" X 4 1/2" CUBELITE C/W ELECTRONIC BALLAST AND OPAL ACRYLIC DIFFUSER, 120V, 1PH. COLOR: WHITE. WIRE AS NIGHT LIGHT. |
| (5) | 5 | LITHONIA | LF6/2/26DDT/F602A/120/GEB10 | 2X26W, CF,41K | LITHONIA, 6" HORIZONTAL COMPACT FLUORESCENT, 2 LAMP DOUBLE TWIN TUBE (DDT) LAMPS WITH WHITE OPEN REFLECTOR AND ELECTRONIC BALLAST. 120V, 1PH |
| (2) | 2 | LITHONIA | LP6H/100M/6L4/120/HEB | 1X100MHED17 | LITHONIA, LPH SERIES OUTDOOR POT LIGHT WITH WHITE SPLAY, FRESNEL LENS AND 100W METAL HALIDE LAMP. 120V, 1PH |
| (F) | 1 | LITHONIA | TWS/50M/120/PE/LP/VTWSWG | 1X50W, METAL HALIDE | LITHONIA: TWS MINI WALL PACK, W/POLYCARBONATE REFRACTOR, 50W, METAL HALIDE LAMP, DARK BRONZE FINISH, PHOTOELECTRIC CELL AND WIRE GUARD. |
| (G) | 1 | LITHONIA | UC/24/CP/120/SWR | 2X8W, T5 | LITHONIA, 24" UNDERCABINET MOUNT FIXTURE WITH ROCKER SWITCH. |
| (H) | 1 | | | | LIFT VESTIBULE, WALL MOUNT FIXTURE TO BE SUPPLIED BY THE CITY OF WINNIPEG. INSTALLED BY CONTRACTOR |
| (L) | 1 | LUMACELL | RG24S144/2MT/9W | 2X9W, 24V, MICRO TUNGSTEN | EMERGENCY LIGHTING BATTERY PACK WITH 2 LIGHTS, 24V, 14WH, 30 MINUTE SUPPLY. |
| (R) | 5 | LUMACELL | MT2/24V/9W | DOUBLE REMOTE LAMP | 2 MICRO TUNGSTEN LAMPS 24V, 9W. TO BE WIRED TO EMERGENCY LIGHTING BATTERY PACK IN BASEMENT MECH. ROOM. MOUNT 4 INCHES BELOW FINISHED CEILING HEIGHT. |
| (S) | 7 | LUMACELL | MT1/24V/9W | SINGLE REMOTE LAMP | 1 MICRO TUNGSTEN LAMP, 24V, 9W. TO BE WIRED TO EMERGENCY LIGHTING BATTERY PACK IN BASEMENT MECH. ROOM. MOUNT 4 INCHES BELOW FINISHED CEILING HEIGHT. |
| (A) | 3 | EDWARDS | 900-0119 | | COMBINATION CARBON MONOXIDE AND SMOKE ALARM |

BASEMENT LIGHT FIXTURES DESIGNATED WITH N(B) FOR B2, B3, B4 OR C2 SHALL BE WIRED AS NIGHT LIGHT.
ALL NEW LIGHTING FIXTURES AND BALLASTS TO BE POWERSMART APPROVED.
LIGHTING FIXTURE QUANTITIES SHOWN ABOVE ARE FOR REFERENCE ONLY. CONTRACTOR IS RESPONSIBLE FOR QUANTITY TAKE-OFF FROM DRAWINGS.

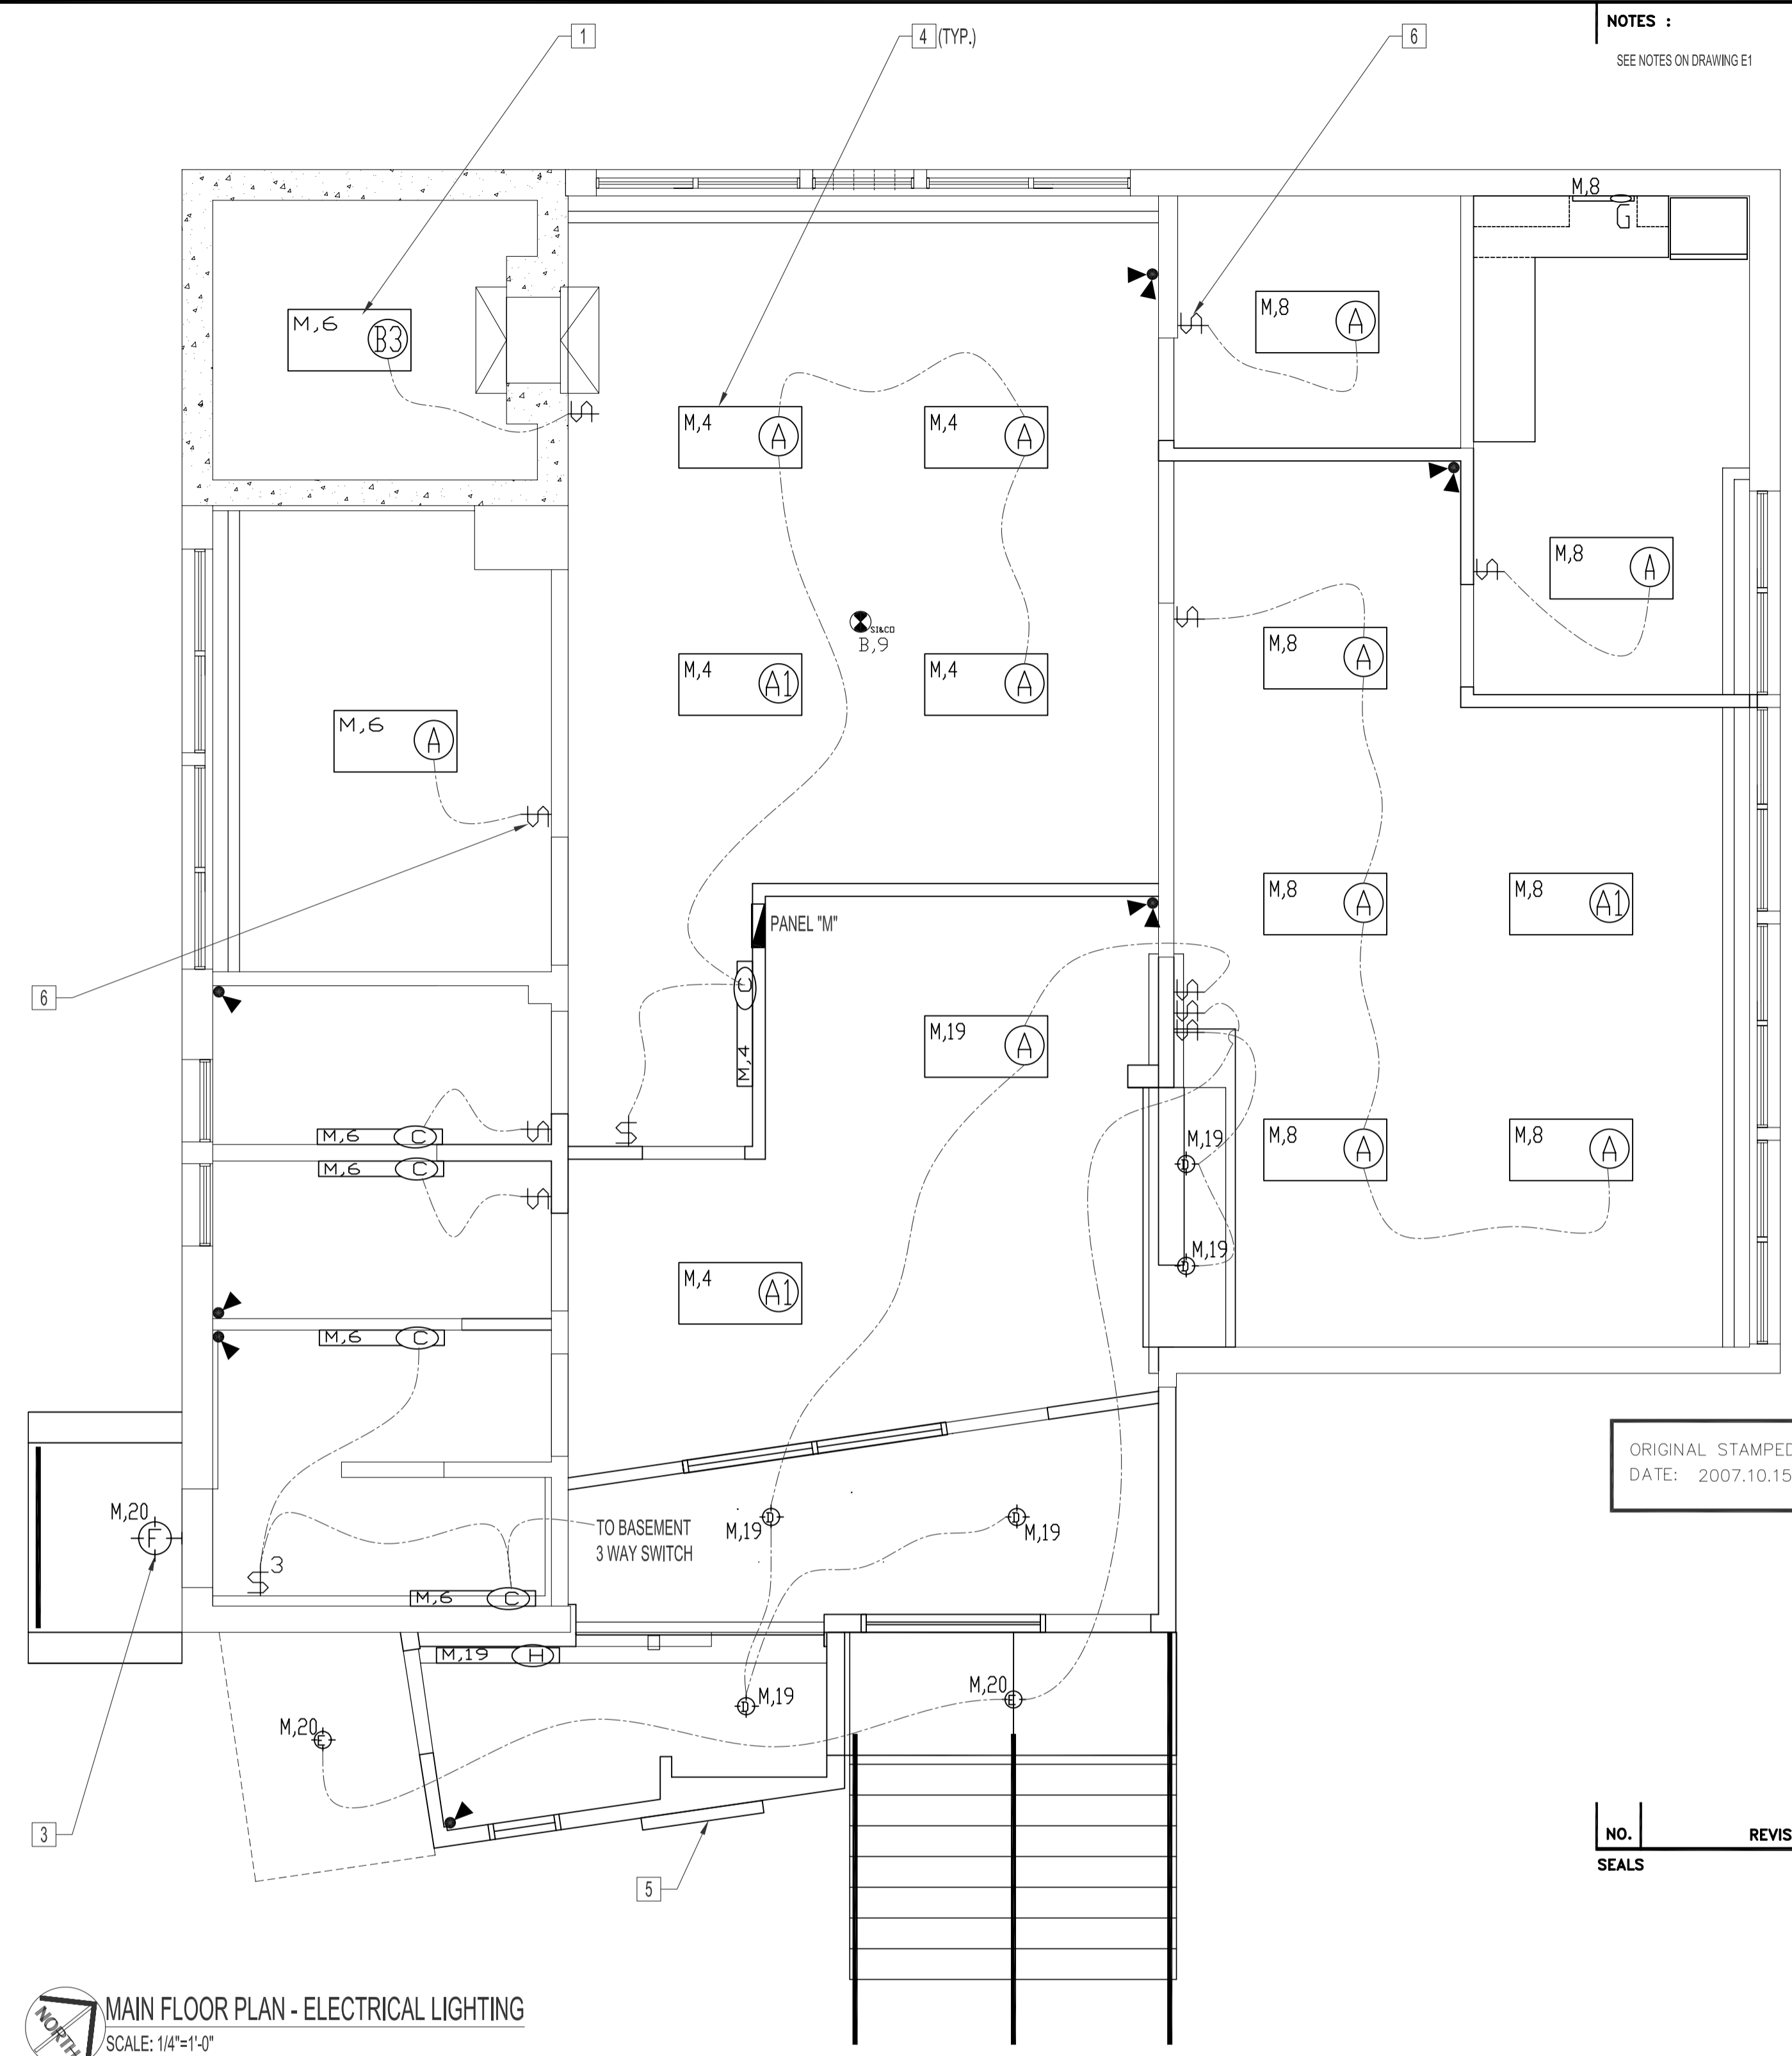

MAIN FLOOR PLAN - ELECTRICAL LIGHTING
SCALE: 1/4"=1'-0"

- ELECTRICAL RENOVATION NOTES**
- 1 SURFACE MOUNT LIGHT FIXTURES.
 - 2 SUPPLY & INSTALL (3) CO & SMOKE DETECTORS C/W DEVICE BOXES. SURFACE MOUNT TO FINISHED CEILING. WIRE AS PER SCHEDULE. DETECTORS TO BE MONITORED AS PER DRAWING T2.
 - 3 SUPPLY & INSTALL WALL MOUNT LIGHT FIXTURE. MOUNT TO EXISTING JUNCTION BOX. RUN NEW CONDUCTORS BACK TO PANEL "M".
 - 4 RECESSED MOUNT LIGHT FIXTURES.
 - 5 PROVIDE JUNCTION BOX AND TIMER FOR LIGHTED SIGN. WIRE TO TIMER IN MECHANICAL ROOM.
 - 6 SUPPLY & INSTALL PASSIVE INFRARED LIGHT SWITCH WITH MOTION DETECTION WALL SWITCH C/W COVER (WHITE). LUTRON MODEL NO. LOS-SIR-M-WH WITH MANUAL ON/AUTO OFF.

NOTES :
SEE NOTES ON DRAWING E1

ORIGINAL STAMPED BY: DOUG PALEY, P.ENG
DATE: 2007.10.15

| NO. | REVISION/DESCRIPTION | BY | DATE |
|-------|----------------------|----|------|
| SEALS | | | |

DRAWN BY: RCP
DATE: 2007.10.15
CHECKED BY: USER APPROVAL
APPROVED

**CITY OF WINNIPEG
PLANNING, PROPERTY &
DEVELOPMENT DEPARTMENT
CIVIC ACCOMMODATIONS DIVISION
300 - 65 GARRY ST. R3C 4K4**

PROJECT
COMMUNITY POLICE SERVICE CENTRE

1400 HENDERSON HWY.
SHEET TITLE
BASEMENT & MAIN FLOOR PLAN
ELECTRICAL
LIGHTING & SCHEDULE

| SCALE | PROJECT NO. | SHEET NO. |
|----------|-------------|-----------|
| AS SHOWN | 2004-023 | E4 |