



ELECTRICAL ROOM PLAN
SCALE: N.T.S.

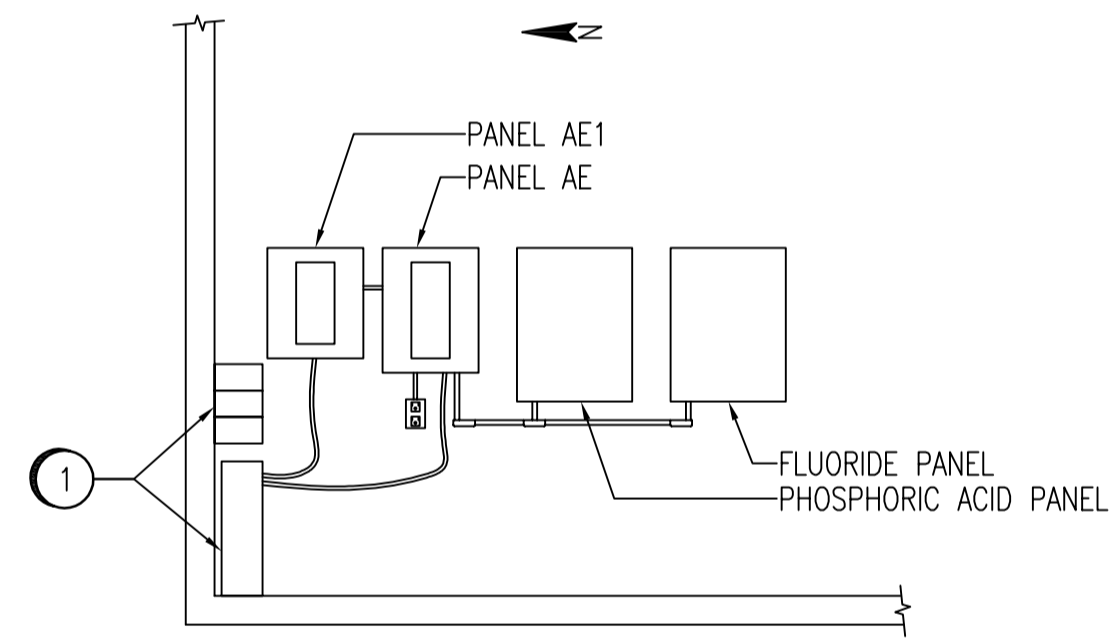

SECTION H
SCALE: N.T.S.

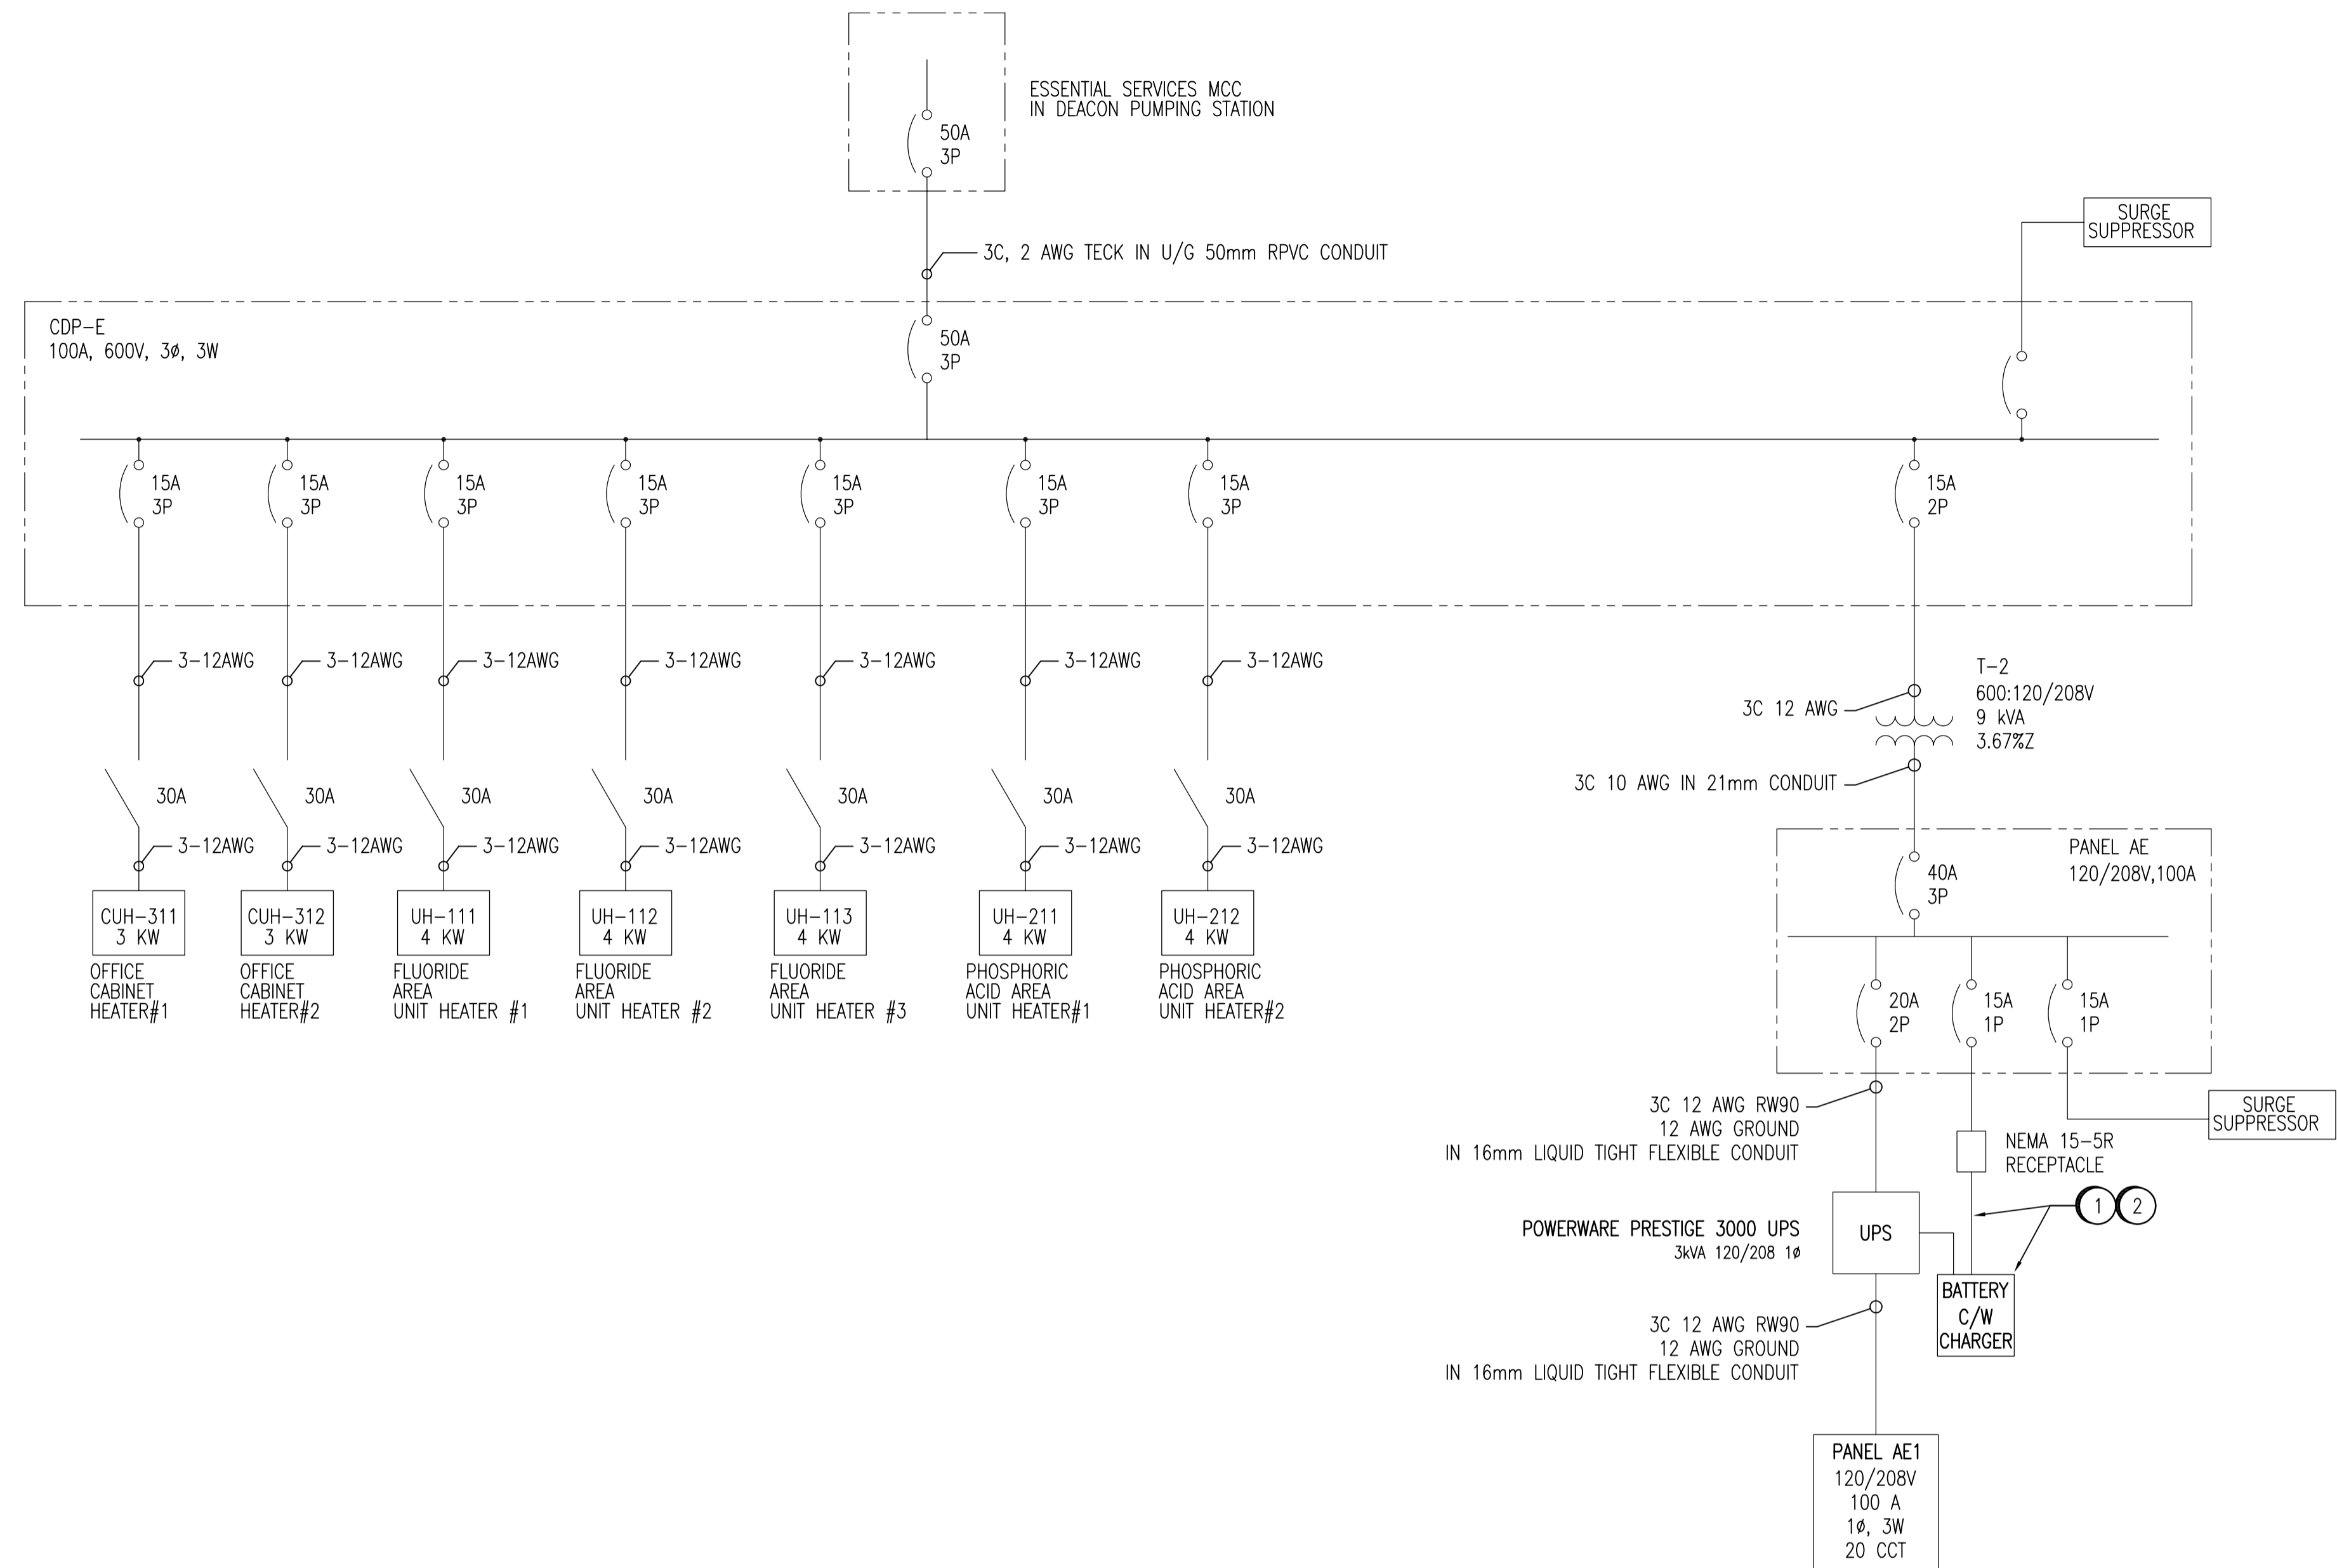

NO.	CONSTRUCTION NOTES
1	DISCONNECT EXISTING POWERWARE UPS, BATTERIES, WIRING, AND ASSOCIATED WALL MOUNTING BRACKET. DISPOSE OF WIRING.
2	EXISTING POWERWARE PRESTIGE UPS AND BATTERIES TO REMAIN.
3	REMOVE AND DISPOSE OF EXISTING POWERWARE PLUS UPS.

DRAWING NUMBER	REFERENCE DRAWINGS
----------------	--------------------



B.M. ELEV.	FIELD BOOK #:
POSTED TO LBIS	
DESIGNED BY C. REIMER	CHECKED BY C. REIMER
DRAWN BY A. OLIVER	APPROVED BY C. REIMER
HOR. SCALE NTS	RELEASED FOR CONSTRUCTION
VERTICAL NTS	DATE 2007/07/05
00 ISSUED FOR TENDER	2008/01/08 AEO
NO. REVISIONS	DATE BY

SNC-LAVALIN

SNC-LAVALIN INC.
148 Nature Park Way
Winnipeg, MB, Canada R3P 0X7
204-786-8080

ENGINEER'S SEAL

PRELIMINARY
NOT TO BE USED FOR CONSTRUCTION

FILENAME: 1-0620C-E0001-001-00.dwg

THE CITY OF WINNIPEG
WATER AND WASTE DEPARTMENT

DEACON CHEMICAL FEED BUILDING
UPS UPGRADES
SINGLE LINE DIAGRAM & LAYOUT
EXISTING CONFIGURATION

CITY DRAWING NUMBER: 1-0620C-E0001

SHEET: 001 REV: 00 SIZE: A1