

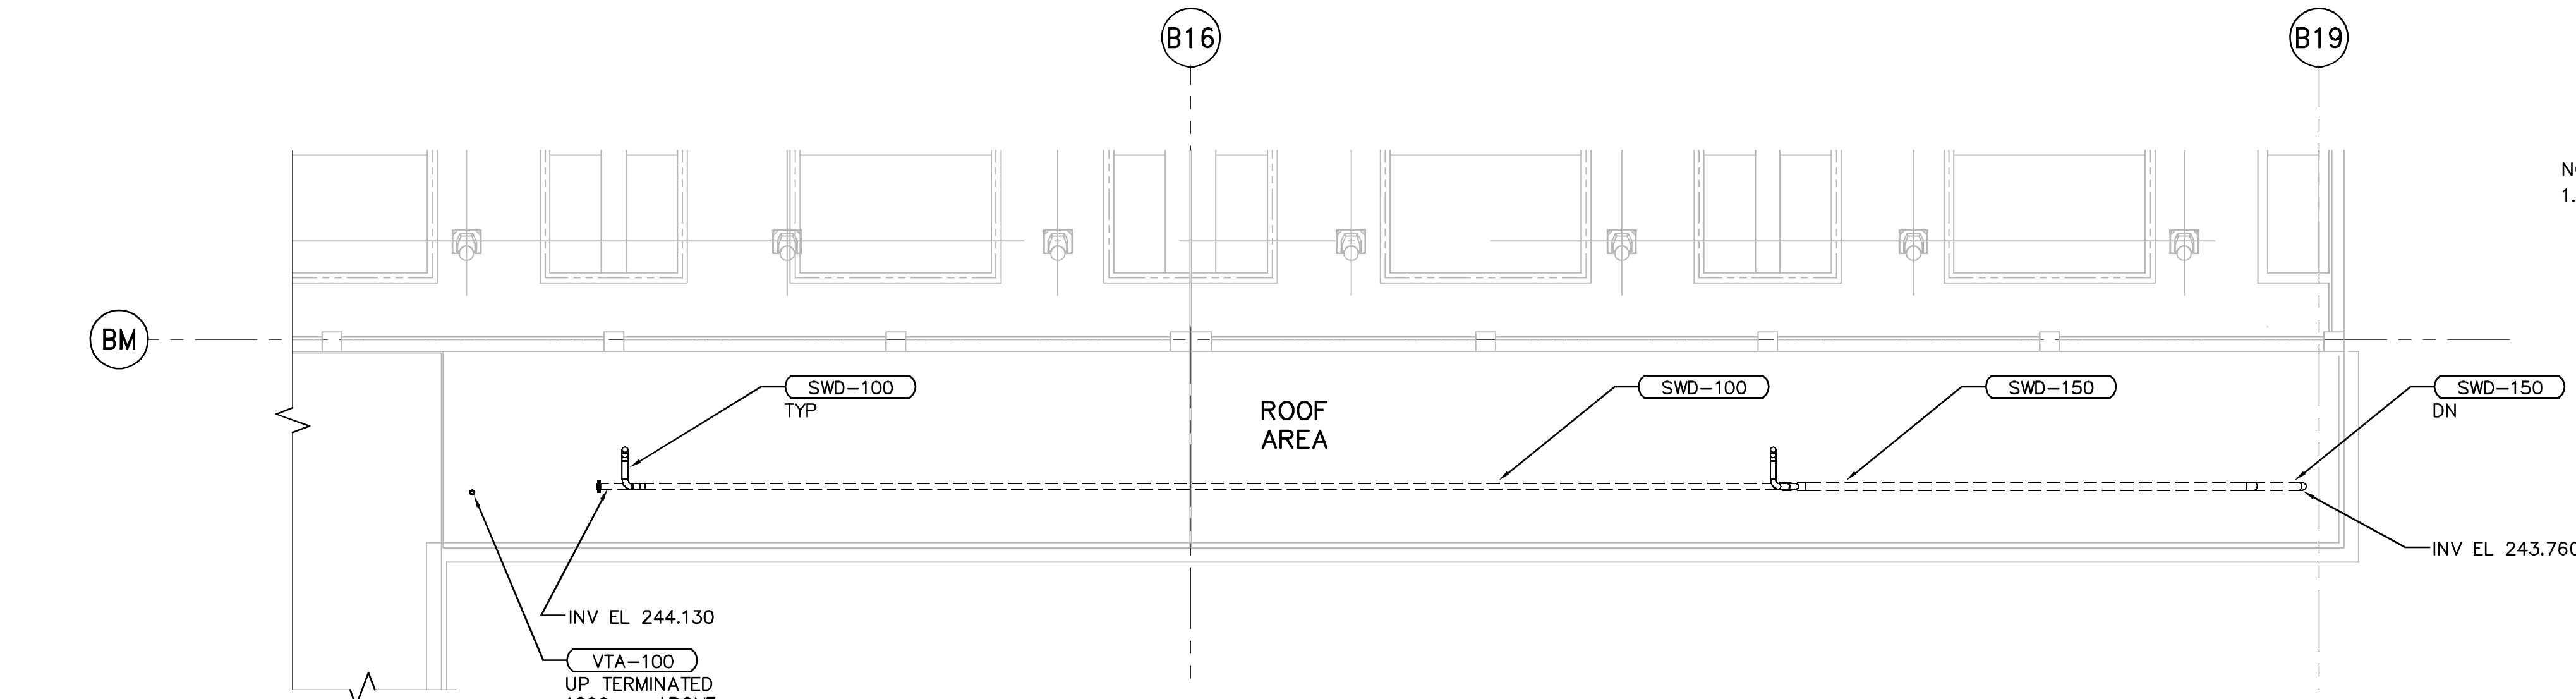


THIRD FLOOR PLAN
1:100

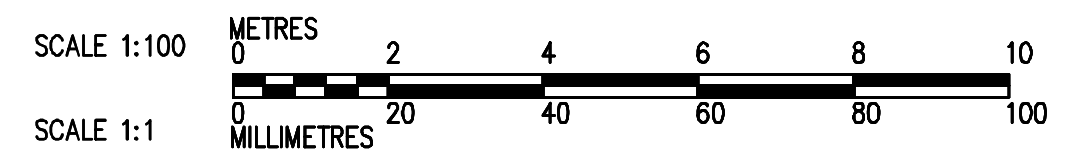

THIRD FLOOR PLAN (CONTINUATION)
1:100

NOTES
1. FOR PLUMBING FIXTURE CONNECTION SIZES, REFER TO FIXTURE CONNECTION SCHEDULE ON DWG. WB-H0533.

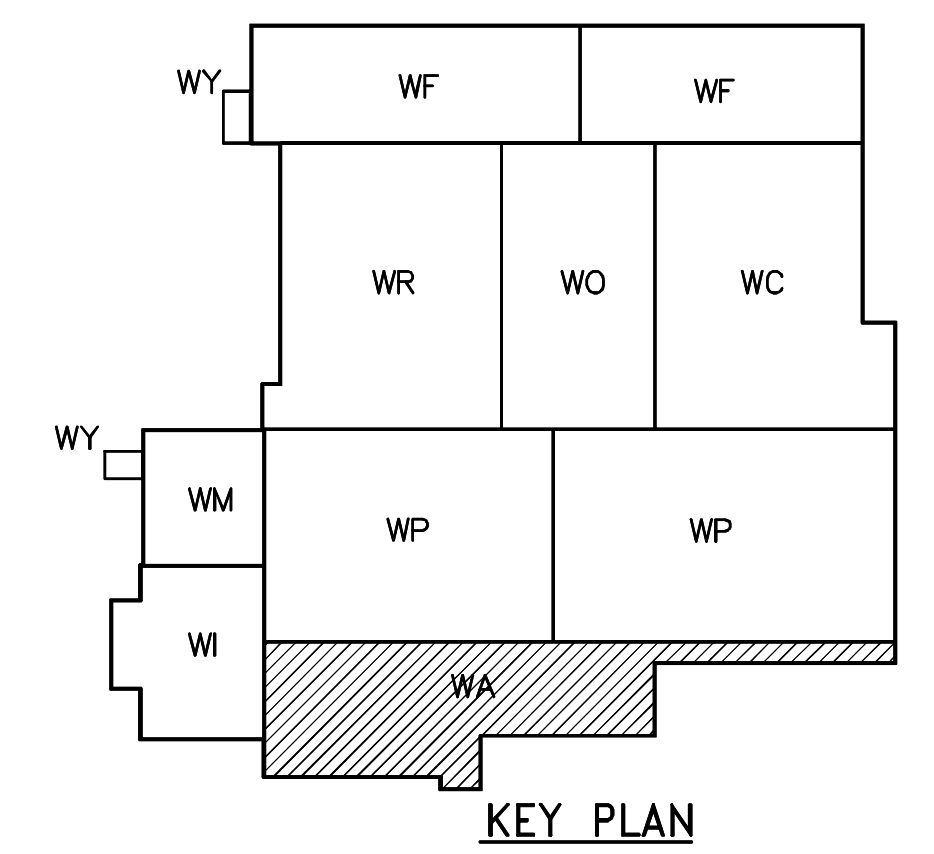

 Certificate of Authorization CH2M HILL Canada Ltd. No. 1441 Expiry: April 30, 2007	INFORMATION ONLY		 Frederickson Cooper ARCHITECTS	 A Tyco International Ltd. Company	ENGINEER'S SEAL ORIGINAL SIGNED BY D.K. CUDDINGTON 2006/03/29	 THE CITY OF WINNIPEG WATER AND WASTE DEPARTMENT ENGINEERING DIVISION WATER TREATMENT PLANT ADMINISTRATION MECHANICAL AND ELECTRICAL	CITY FILE NUMBER
	DESIGNED BY: JZ/SW CHECKED BY: DL DRAWN BY: JMcP APPROVED BY: AHL SCALE: 1:100 RELEASED FOR CONSTRUCTION BY: R. SOROKOWSKI DATE: 2005/07/15 DATE: 2006/03/29	CONSULTANT DRAWING NO. WA-H0132	SHEET OF CITY DRAWING NUMBER 1-0601A-A-H0132-001-020				