
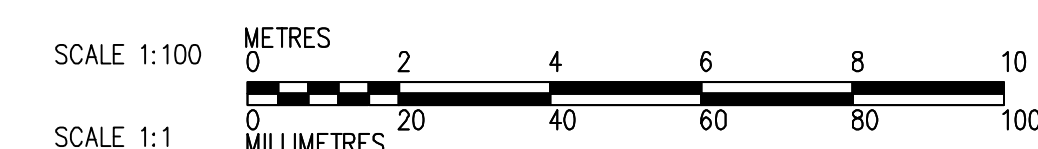


NOTE: CEILING HEIGHTS SHOWN ARE TO BE MEASURED FROM EACH ROOM'S RESPECTIVE FINISH FLOOR ELEVATIONS.

1 PARTIAL REFLECTED CEILING PLAN - ADMINISTRATION AREA (THIRD FLOOR)
WB-B0153 1:100

FIRE RATINGS:

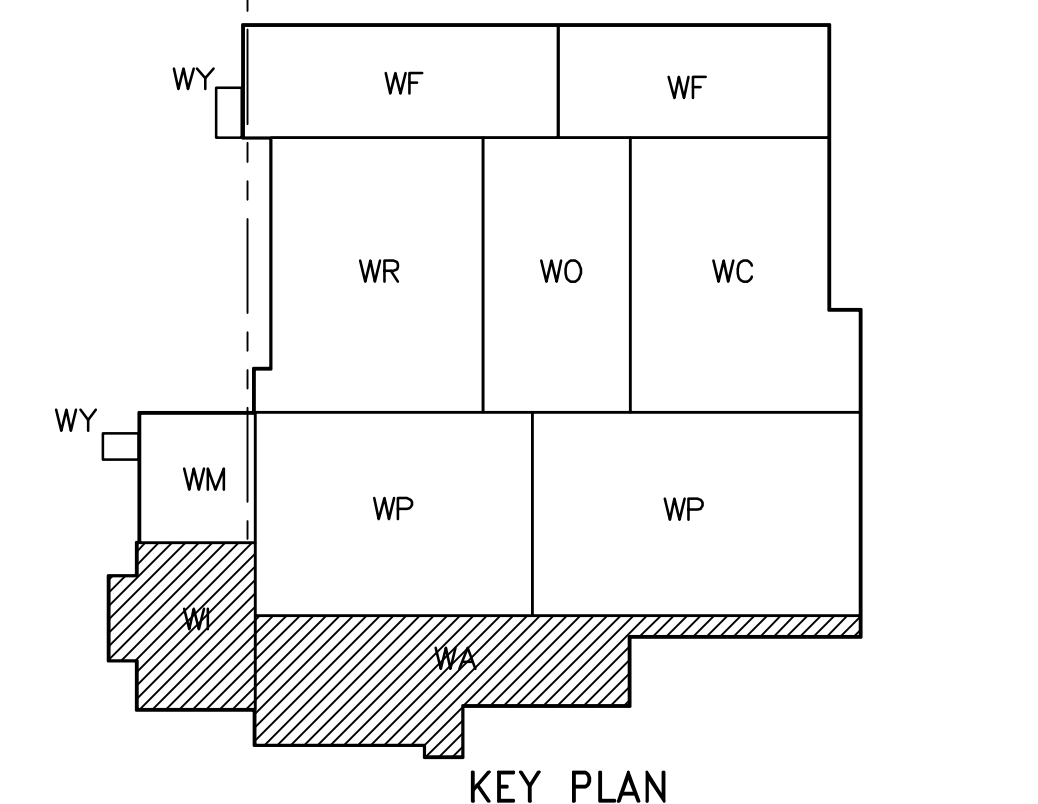

INFORMATION ONLY



NO.	REVISIONS	DATE	BY
04	95-2007 FI-O-006-FC	07/12/04	LK
03	95-2007 ISSUED FOR CONSTRUCTION	07/09/04	LK
02	95-2007 ADDENDUM 06	07/07/04	LK
01	95-2007 ADDENDUM 05	07/07/13	LK
00	ISSUED FOR TENDER	07/06/05	LK

DESIGNED BY: TWS	CHECKED BY: BJS
DRAWN BY: AL/LK	APPROVED BY: AHL
SCALE: 1:100	RELEASED FOR CONSTRUCTION BY: R. SOROKOWSKI
DATE: 2005/08/03	DATE: 2007/06/05

ENGINEER'S SEAL
ORIGINAL SIGNED BY: NEIL COOPER
DATE: 2007/06/05
CONSULTANT DRAWING NO. WB-B0153

THE CITY OF WINNIPEG
WATER AND WASTE DEPARTMENT
ENGINEERING DIVISION

WATER TREATMENT PLANT
MAIN BUILDING
OFFICE AND PLANT INTERIOR FINISHES

ARCHITECTURAL
PARTIAL REFLECTED CEILING PLAN OF
ADMINISTRATION AREA

CITY FILE NUMBER
SHEET OF
CITY DRAWING NUMBER
1-0601B-A-B0153-001-04D