
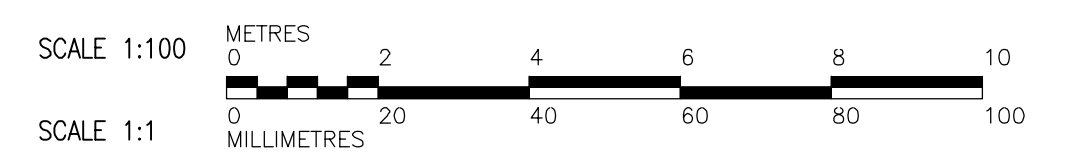


THIRD FLOOR PLAN
1:100

- NOTES:
1. CONSTANT VOLUME VENTURI VALVE BY E.H. PRICE, MODEL MA-CV SIZE 200. ADJUST FOR 118 L/S
 2. PROVIDE FIRE DAMPER AT ALL DUCT PENETRATION THRU FLOOR. LOUVERS BY OTHERS
 3. PROVIDE DRIP LEG ON GAS PIPES AS REQUIRED BY APPLICABLE GAS CODE.

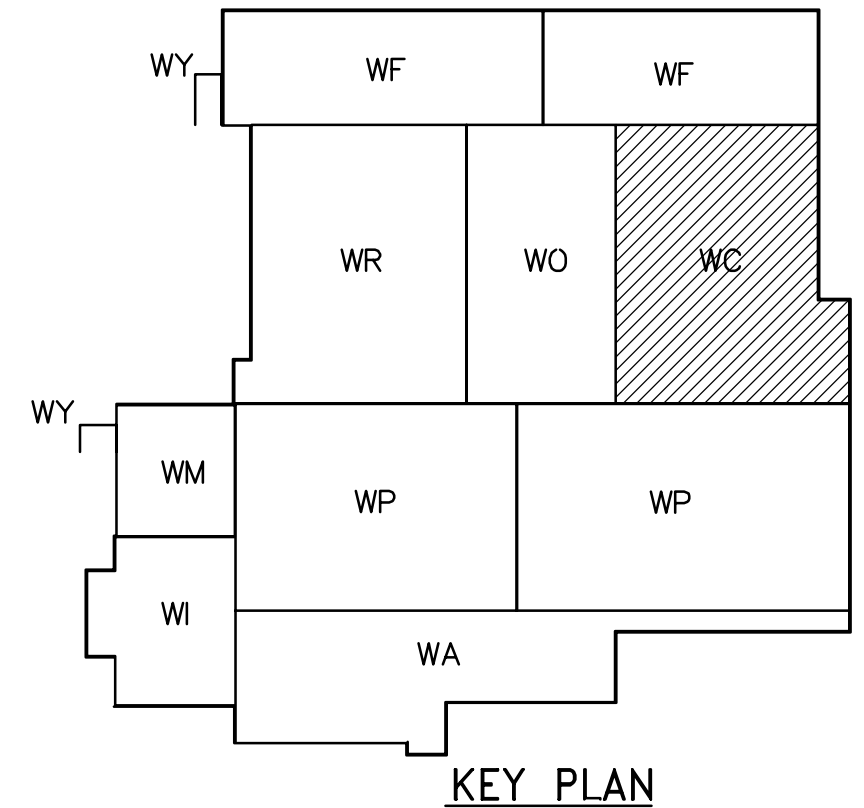

<p>Certificate of Authorization CH2M HILL Canada Ltd. No. 1441 Expiry: April 30, 2007</p>	<p>INFORMATION ONLY</p>		<p>Frederickson Cooper ARCHITECTS</p>	<p>A Tyco International Ltd. Company</p>	ENGINEER'S SEAL	<p>THE CITY OF WINNIPEG WATER AND WASTE DEPARTMENT ENGINEERING DIVISION</p>
	DESIGNED BY TT	CHECKED BY DL			ORIGINAL SIGNED BY D.K. CUDDINGTON	
03 ISSUED FOR CONSTRUCTION 06/07/28 TT	02 742-2005 ADDENDUM 6 06/05/26 TT	01 742-2005 ADDENDUM 5 06/05/19 TT	SCALE: 1:100	RELEASED FOR CONSTRUCTION BY: R. SOROKOWSKI	CONSULTANT DRAWING NO. WC-H0131	SHEET OF
NO. REVISIONS	DATE	BY	DATE	DATE	DATE	CITY DRAWING NUMBER 1-0601C-A-H0131-001-030
			2005/07/04	2006/03/29		HVAC CHEMICAL AREA THIRD FLOOR PLAN