
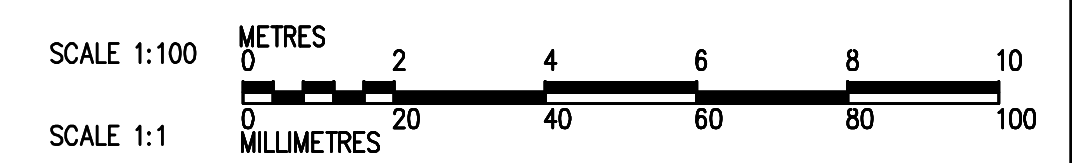


FIRST FLOOR PLAN
1:100

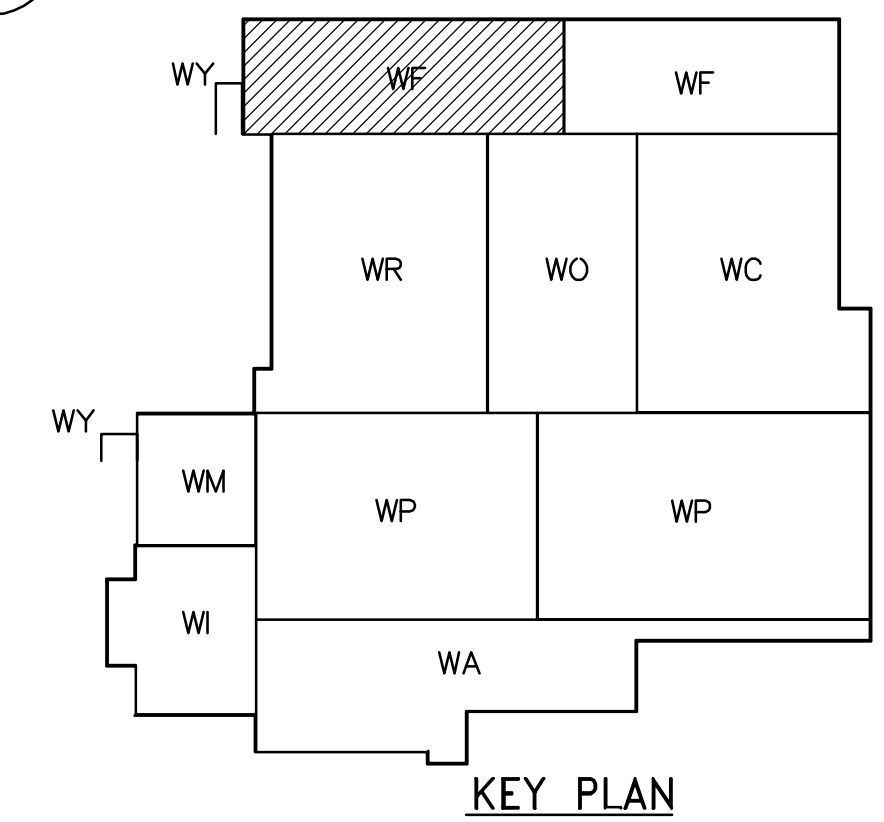

 Certificate of Authorization CH2M HILL Canada Ltd. No. 1441 Expiry: April 30, 2007	INFORMATION ONLY		 Frederickson Cooper ARCHITECTS	 A Tyco International US Company	ENGINEER'S SEAL ORIGINAL SIGNED BY D.K. CUDDINGTON 2006/03/29	 THE CITY OF WINNIPEG WATER AND WASTE DEPARTMENT ENGINEERING DIVISION WATER TREATMENT PLANT FILTRATION MECHANICAL AND ELECTRICAL	CITY FILE NUMBER
	DESIGNED BY: JZ/SW DRAWN BY: JMcP SCALE: 1:100	CHECKED BY: DL APPROVED BY: AHL RELEASED FOR CONSTRUCTION BY: R. SOROKOWSKI	CONSULTANT DRAWING NO. WF-H0113	SHEET OF			
01 ISSUED FOR CONSTRUCTION 06/07/28 SW 00 ISSUED FOR TENDER 06/03/29 SW NO. REVISIONS DATE BY	DATE 2005/08/02	DATE 2006/03/29	PLUMBING FILTRATION AREA 1 FIRST FLOOR PLAN		CITY DRAWING NUMBER 1-0601F-A-H0113-001-010		