
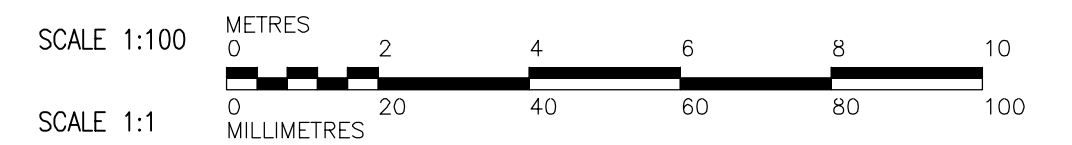


- NOTES:
1. PROVIDE FIRE DAMPER AT ALL DUCT PENETRATION THRU FLOOR.

THIRD FLOOR PLAN
1:100

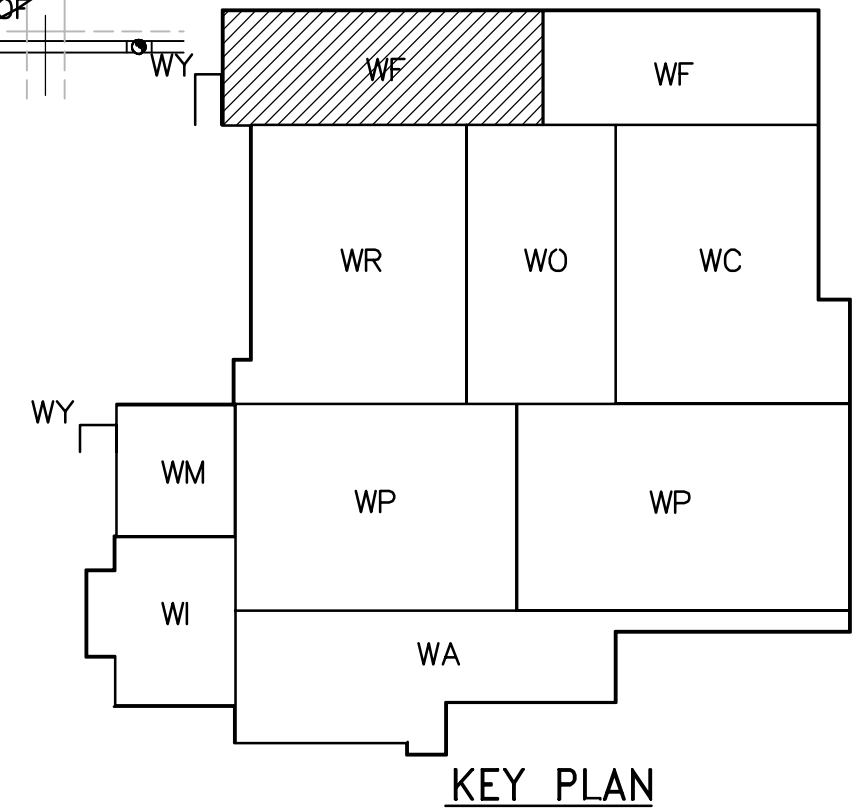

<p>APEGM Certificate of Authorization CH2M HILL Canada Ltd. No. 1441 Expiry: April 30, 2007</p>	<p>INFORMATION ONLY</p> <table border="1"> <tr> <th>NO.</th> <th>REVISIONS</th> <th>DATE</th> <th>BY</th> </tr> <tr> <td>02</td> <td>ISSUED FOR CONSTRUCTION</td> <td>06/07/28</td> <td>TT</td> </tr> <tr> <td>01</td> <td>742-2005 ADDENDUM 5</td> <td>06/05/19</td> <td>TT</td> </tr> <tr> <td>00</td> <td>ISSUED FOR TENDER</td> <td>06/03/29</td> <td>TT</td> </tr> </table>	NO.	REVISIONS	DATE	BY	02	ISSUED FOR CONSTRUCTION	06/07/28	TT	01	742-2005 ADDENDUM 5	06/05/19	TT	00	ISSUED FOR TENDER	06/03/29	TT	<p>CH2M HILL Frederickson Cooper ARCHITECTS</p> <p>EarthTech A Tyco International US Company</p>	<p>ENGINEER'S SEAL</p> <p>ORIGINAL SIGNED BY D.K. CUDDINGTON</p> <p>2006/03/29</p>	<p>THE CITY OF WINNIPEG WATER AND WASTE DEPARTMENT ENGINEERING DIVISION</p> <p>WATER TREATMENT PLANT FILTRATION MECHANICAL AND ELECTRICAL</p>	<p>CITY FILE NUMBER</p> <p>SHEET OF</p>
		NO.	REVISIONS	DATE	BY																
02	ISSUED FOR CONSTRUCTION	06/07/28	TT																		
01	742-2005 ADDENDUM 5	06/05/19	TT																		
00	ISSUED FOR TENDER	06/03/29	TT																		
<p>DESIGNED BY TT</p> <p>CHECKED BY DL</p> <p>DRAWN BY AM</p> <p>APPROVED BY AHL</p> <p>SCALE: 1:100</p> <p>RELEASED FOR CONSTRUCTION BY: R. SOROKOWSKI</p> <p>DATE 2005/08/19</p> <p>DATE 2006/03/29</p>	<p>CONSULTANT DRAWING NO. WF-H0131</p>	<p>HVAC FILTRATION AREA 1 THIRD FLOOR PLAN</p> <p>CITY DRAWING NUMBER 1-0601F-A-H0131-001-020</p>																			