


THIRD FLOOR PLAN
1:100

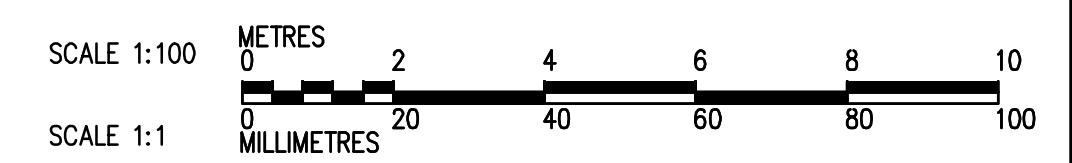

 Certificate of Authorization CH2M HILL Canada Ltd. No. 1441 Expiry: April 30, 2007	INFORMATION ONLY		 Frederickson Cooper ARCHITECTS	 A Tyco International US Company	ENGINEER'S SEAL ORIGINAL SIGNED BY D.K. CUDDINGTON 2006/03/29	 THE CITY OF WINNIPEG WATER AND WASTE DEPARTMENT ENGINEERING DIVISION	CITY FILE NUMBER
	DESIGNED BY: JZ/SW DRAWN BY: JMcP SCALE: 1:100 DATE: 2005/07/15	CHECKED BY: DL APPROVED BY: AHL RELEASED FOR CONSTRUCTION BY: R. SOROKOWSKI DATE: 2006/03/29			CONSULTANT DRAWING NO. WP-H0134		WATER TREATMENT PLANT FLOCCULATION AND DAF MECHANICAL AND ELECTRICAL SHEET OF
NO. REVISIONS DATE BY	02 ISSUED FOR CONSTRUCTION 06/07/28 SW 01 742-2005 ADDENDUM 5 06/05/19 SW 00 ISSUED FOR TENDER 06/03/29 SW	DATE: 2005/07/15	DATE: 2006/03/29	PLUMBING FLOC/DAF AREA 2 THIRD FLOOR PLAN	CITY DRAWING NUMBER 1-0601P-A-H0134-001-020		