




8 ACCESSIBLE CONTROL DETAIL  
E5.0 NTS

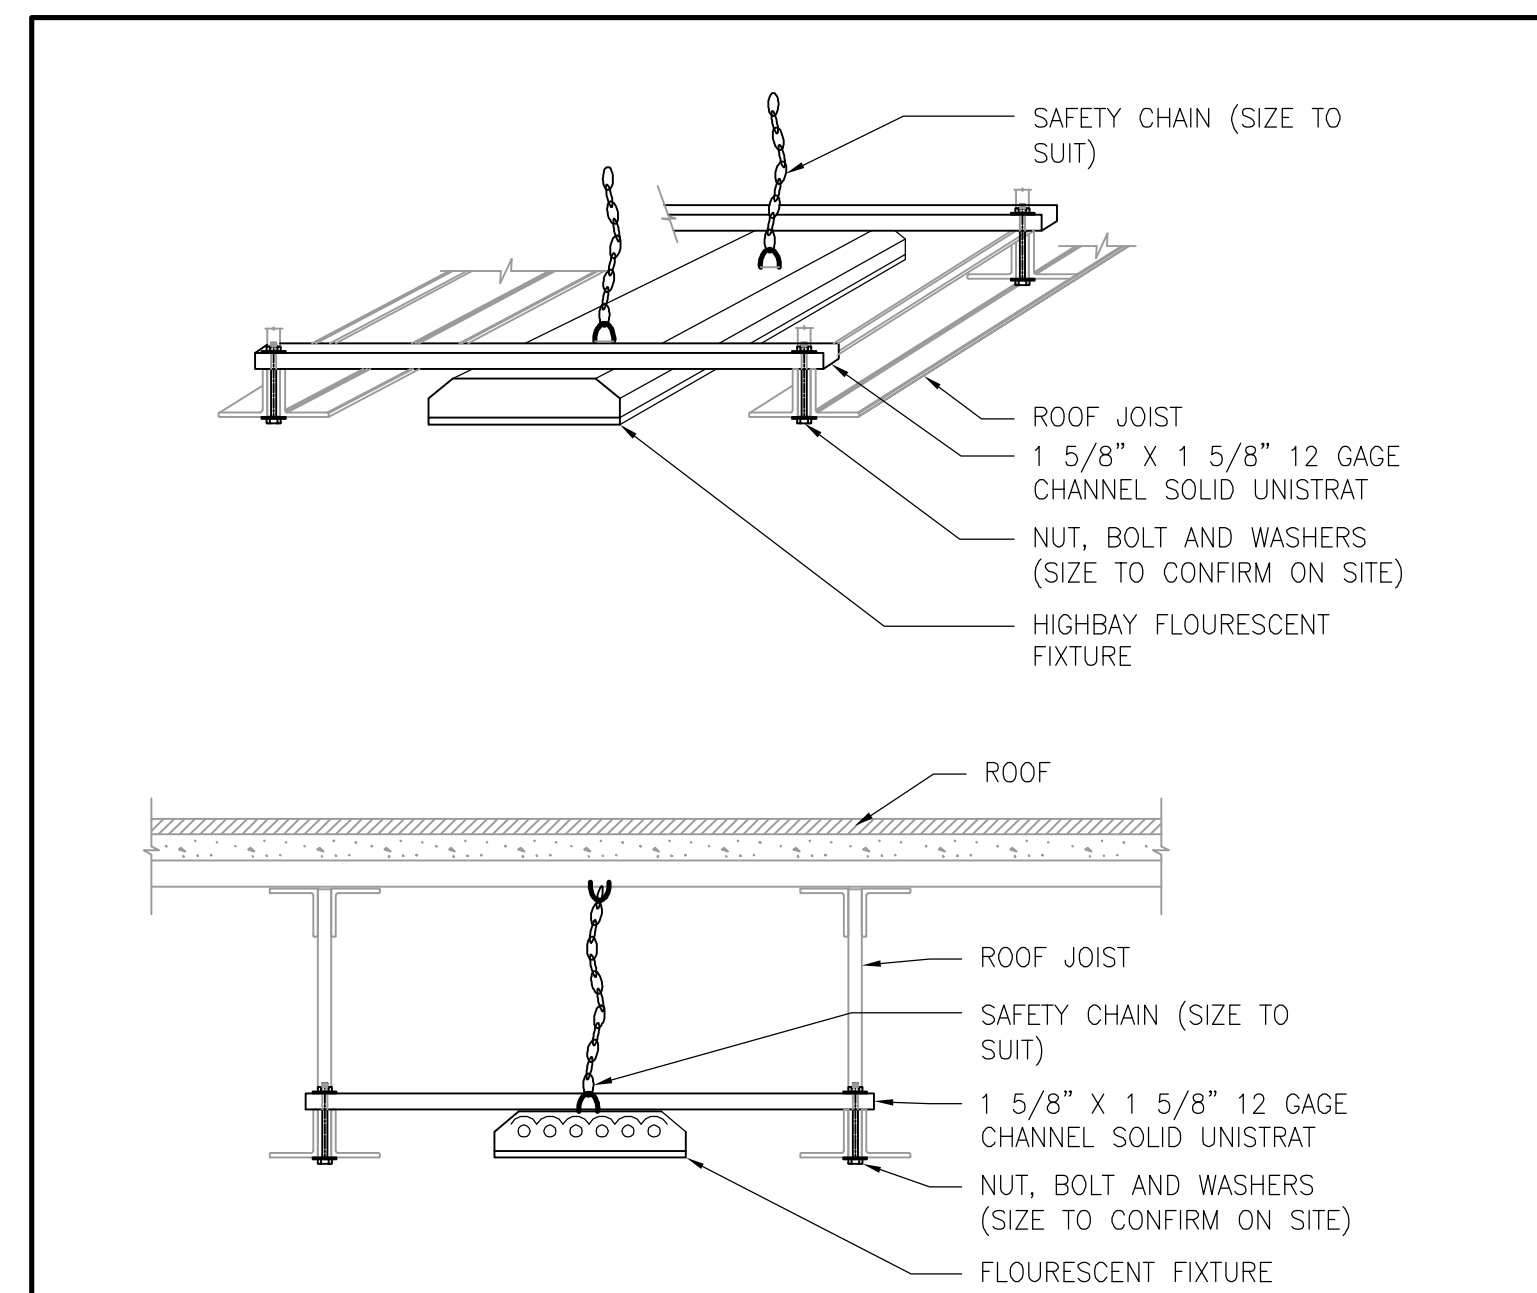


6 FIXTURE MOUNTING DETAIL  
E5.0 SCALE: N.T.S.

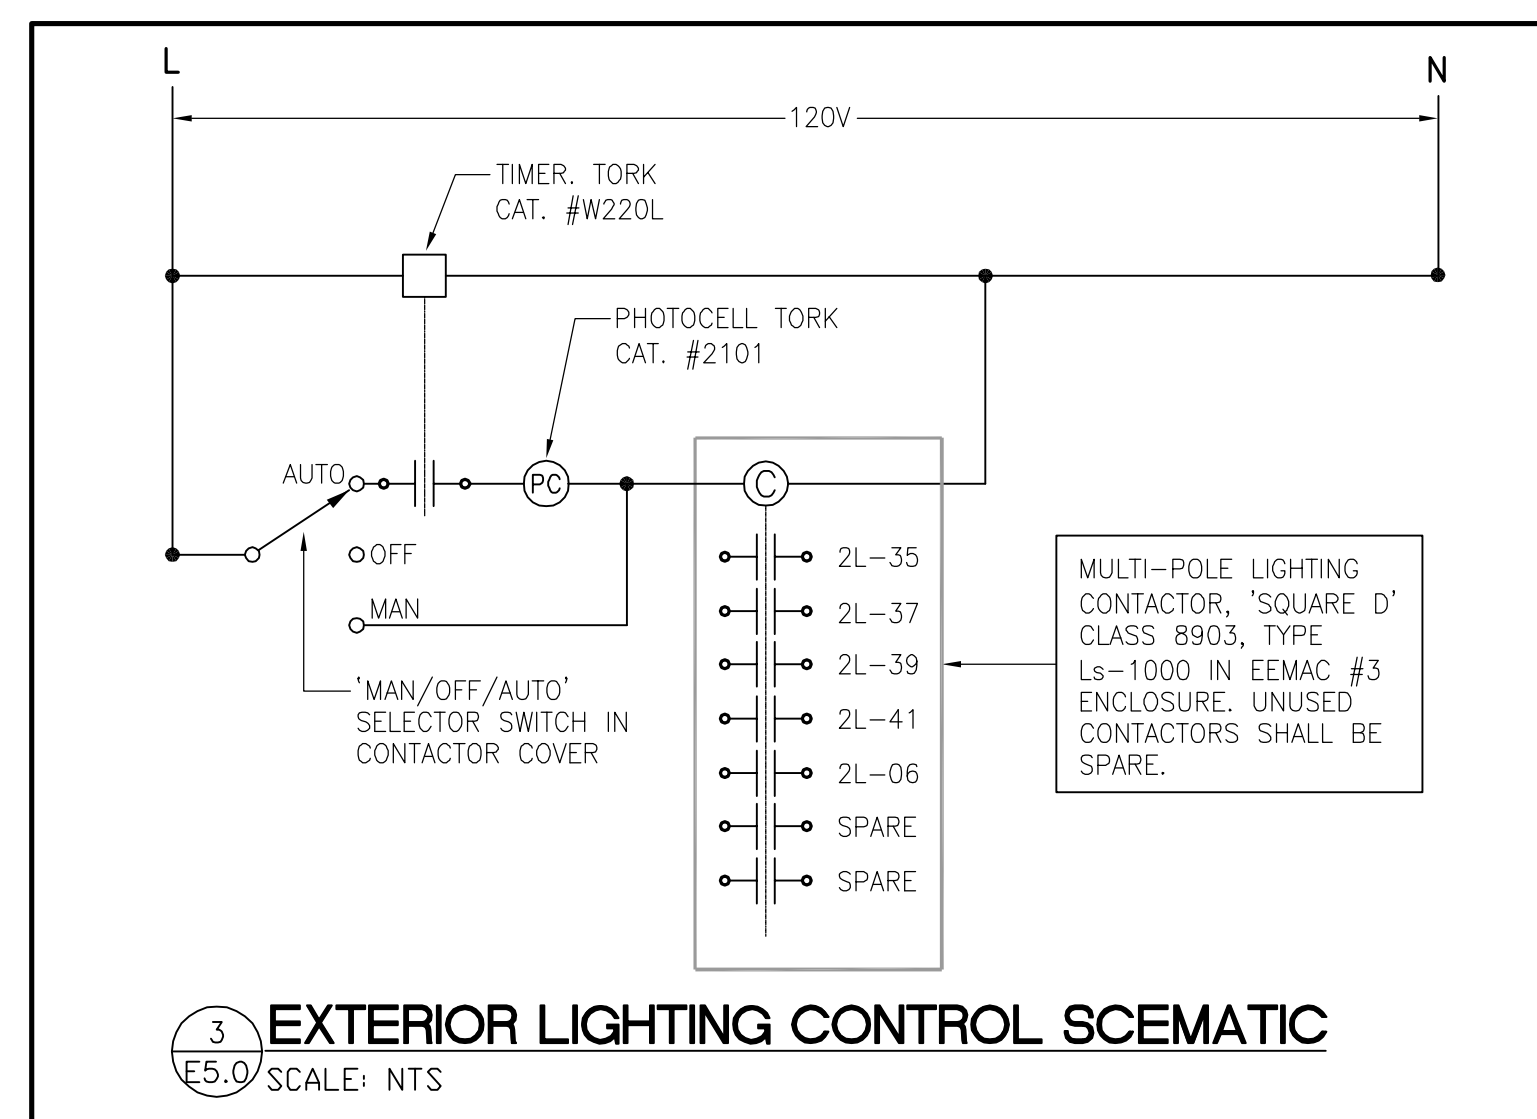


3 EXTERIOR LIGHTING CONTROL SCHEMATIC  
E5.0 SCALE: NTS

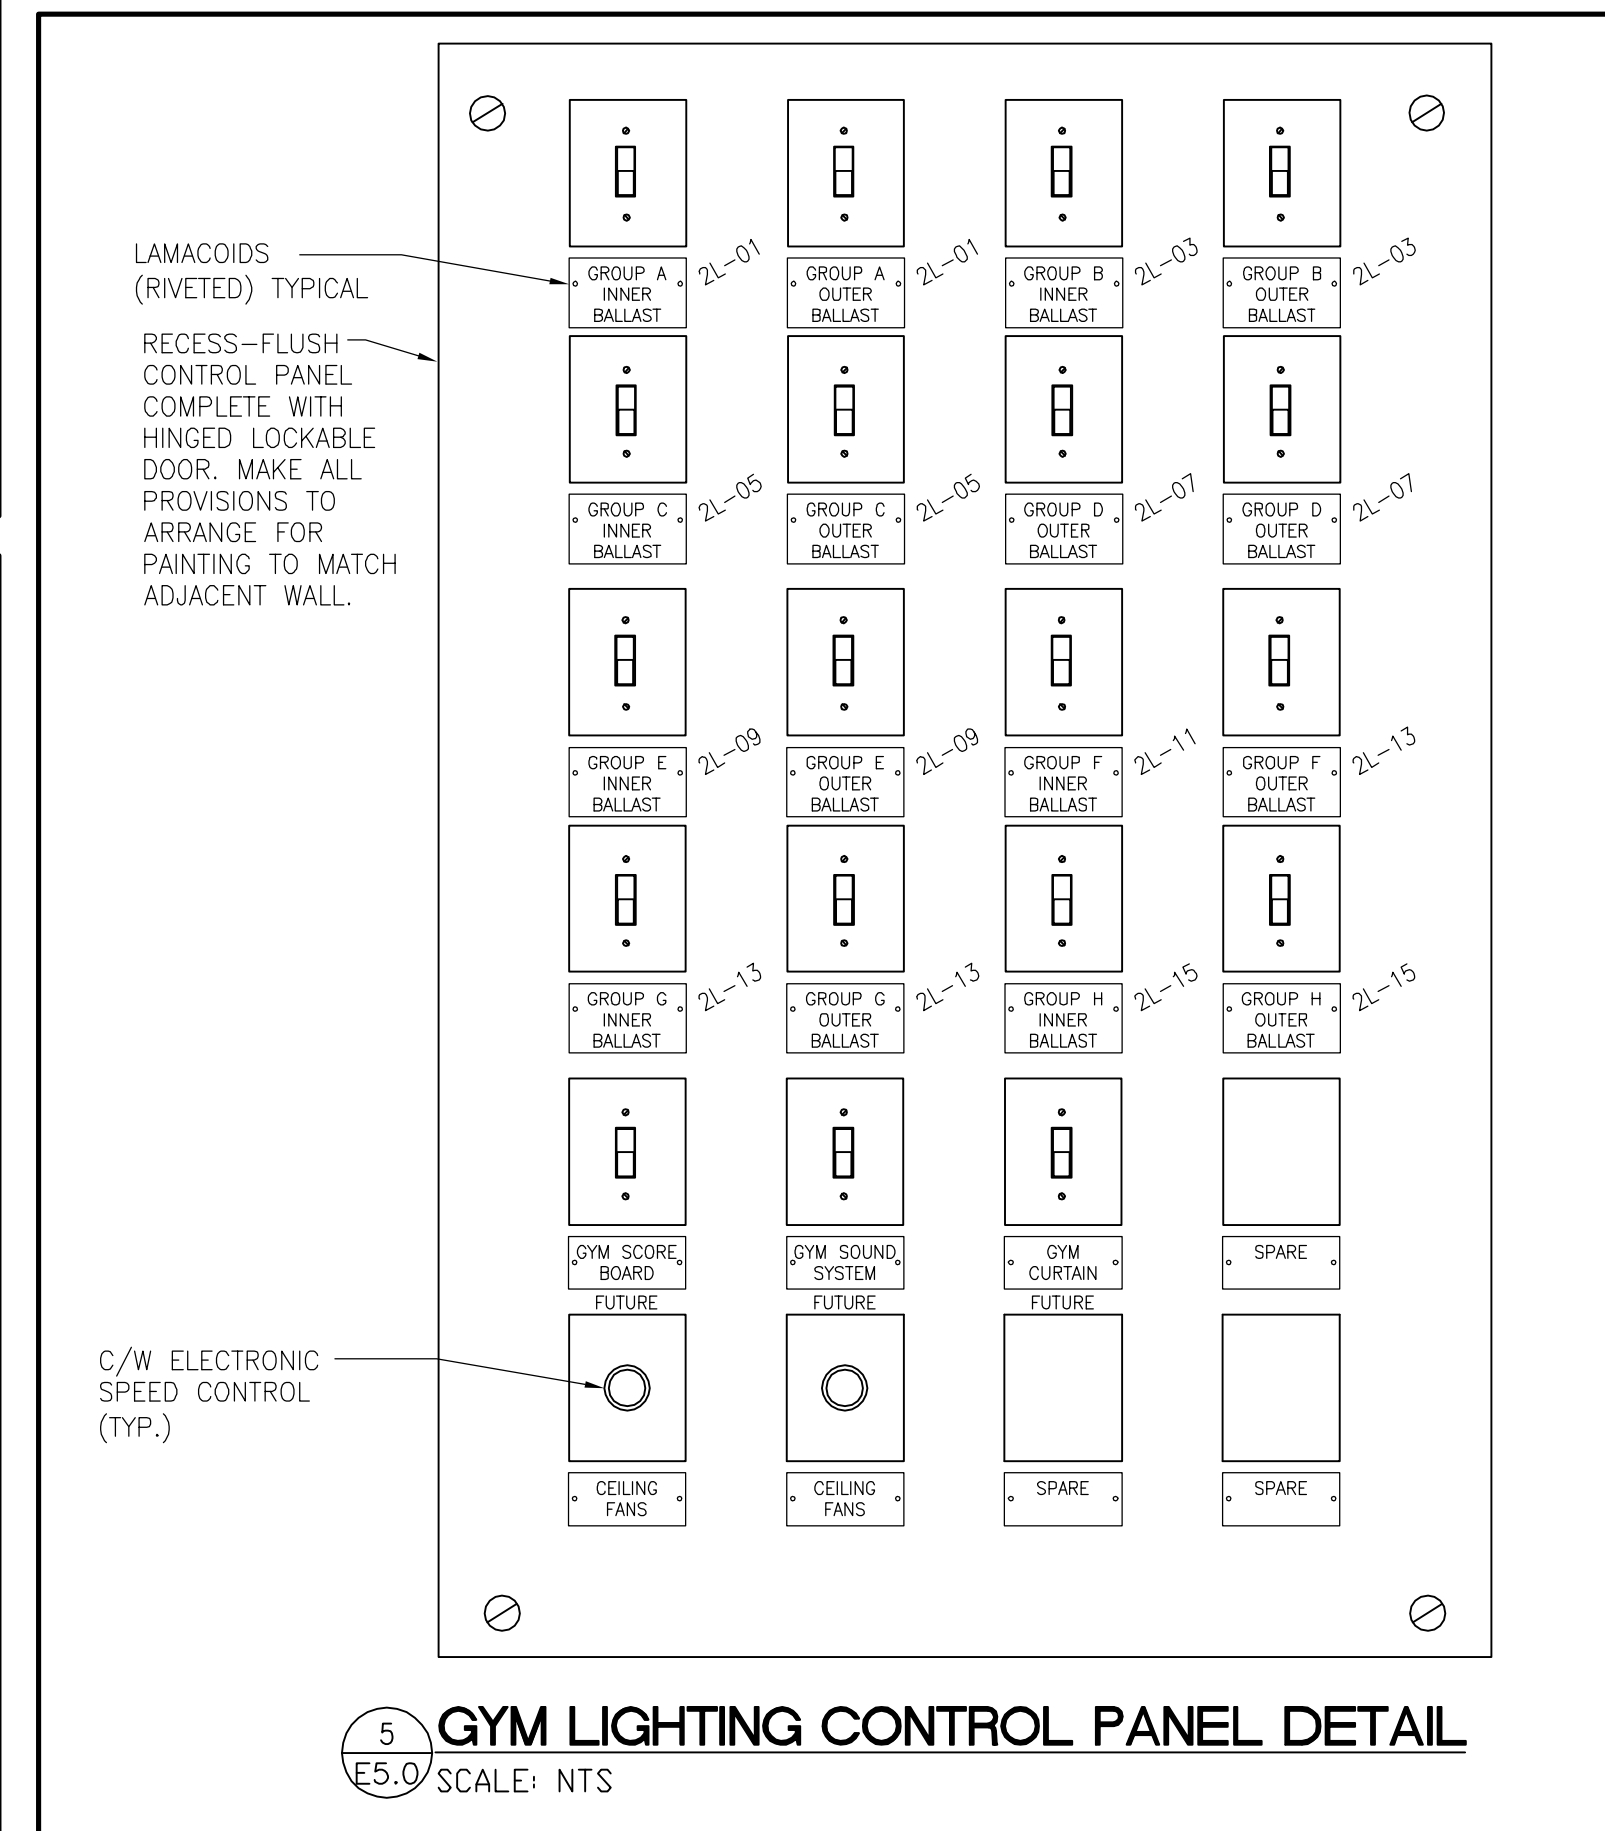


5 GYM LIGHTING CONTROL PANEL DETAIL  
E5.0 SCALE: NTS

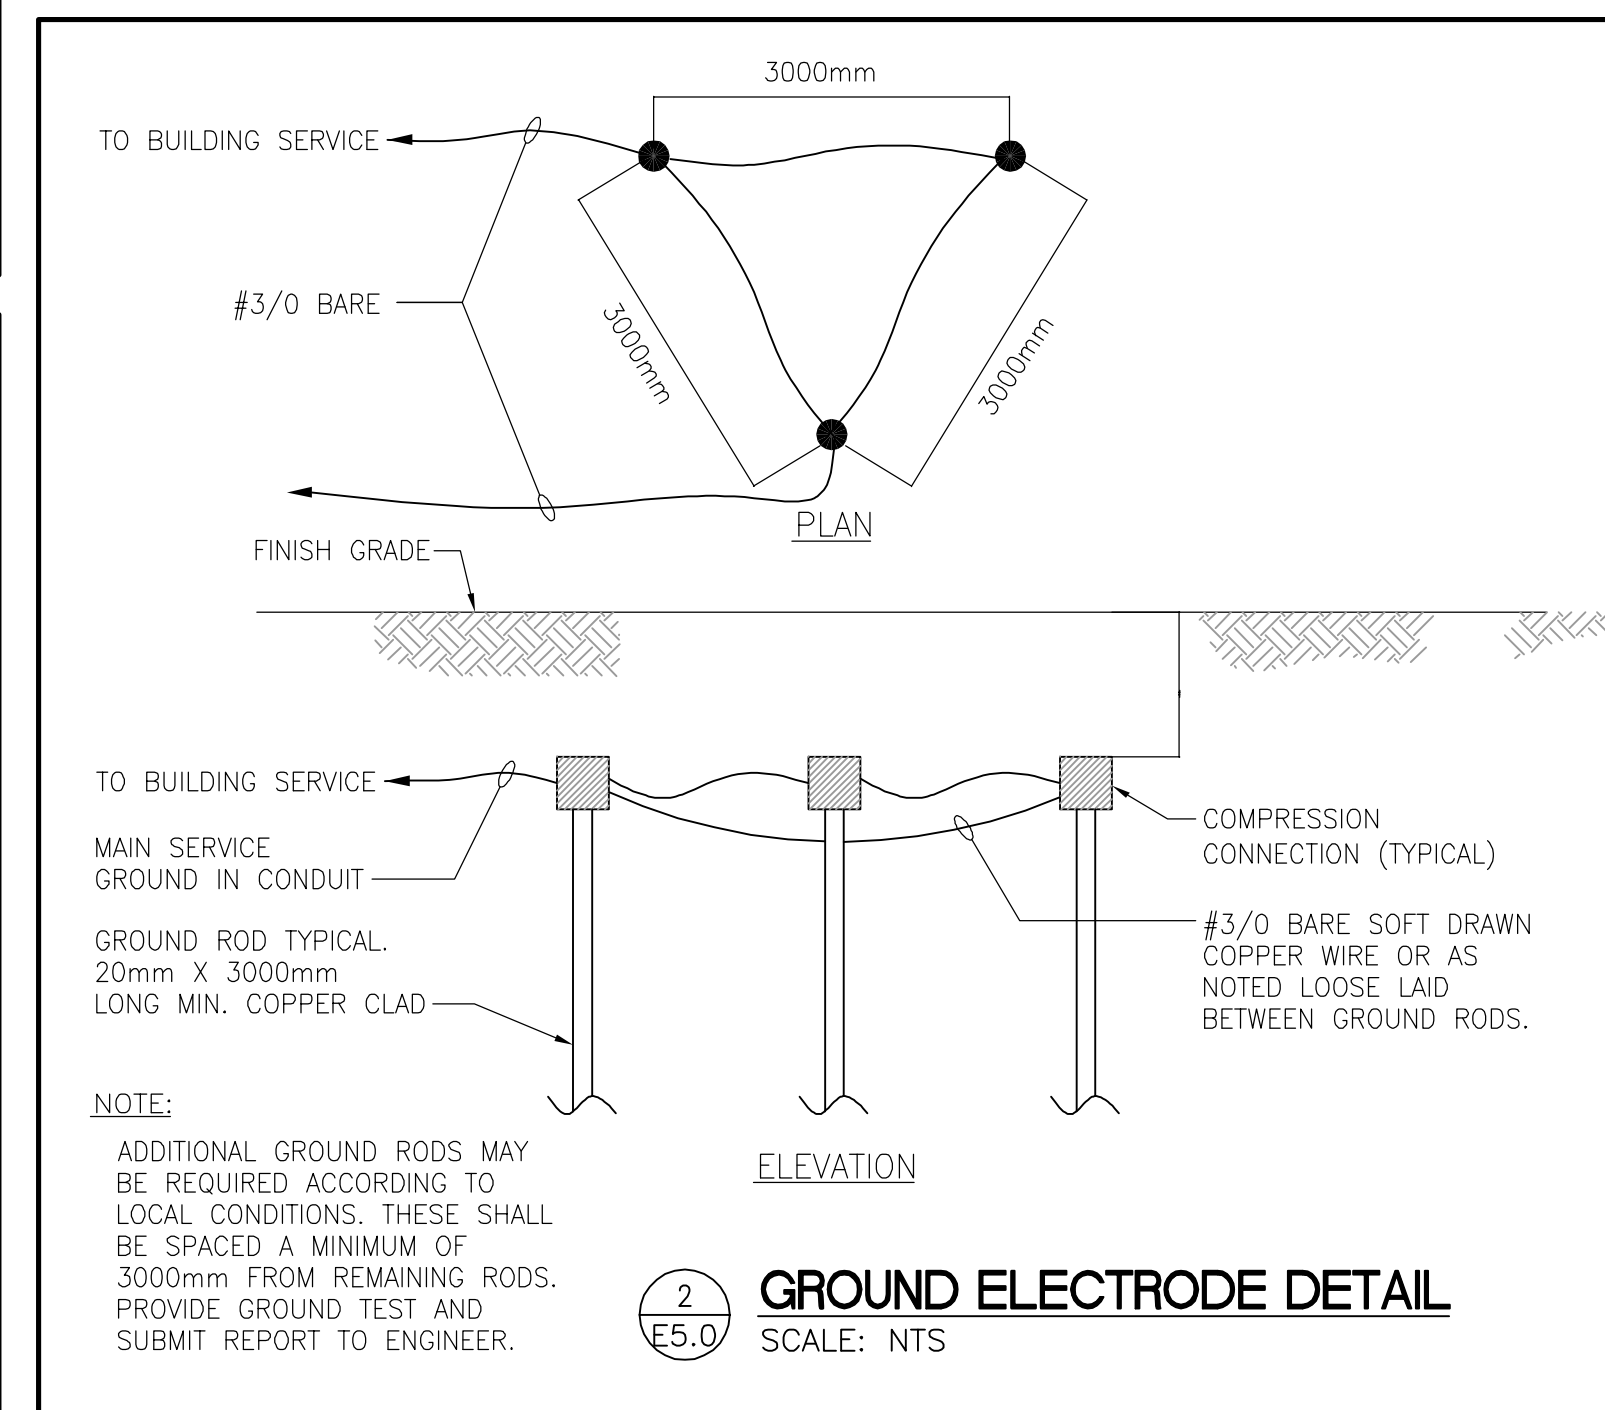


2 GROUND ELECTRODE DETAIL  
E5.0 SCALE: NTS

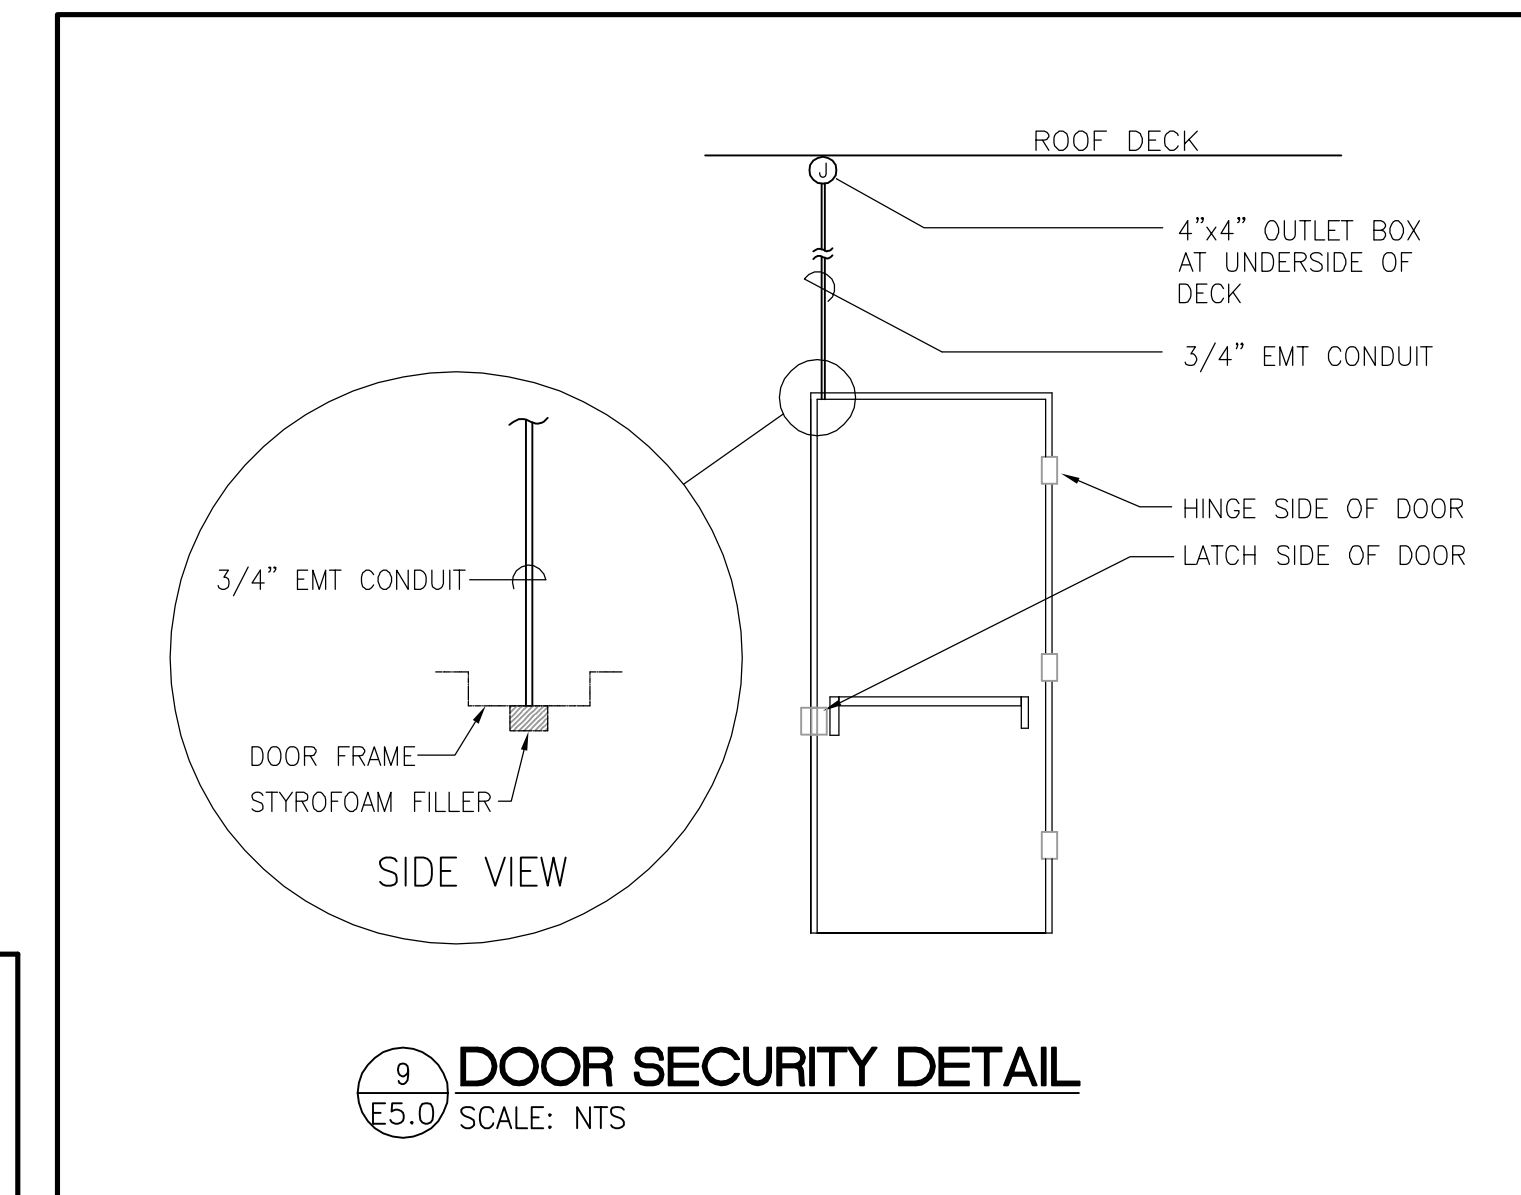


9 DOOR SECURITY DETAIL  
E5.0 SCALE: NTS

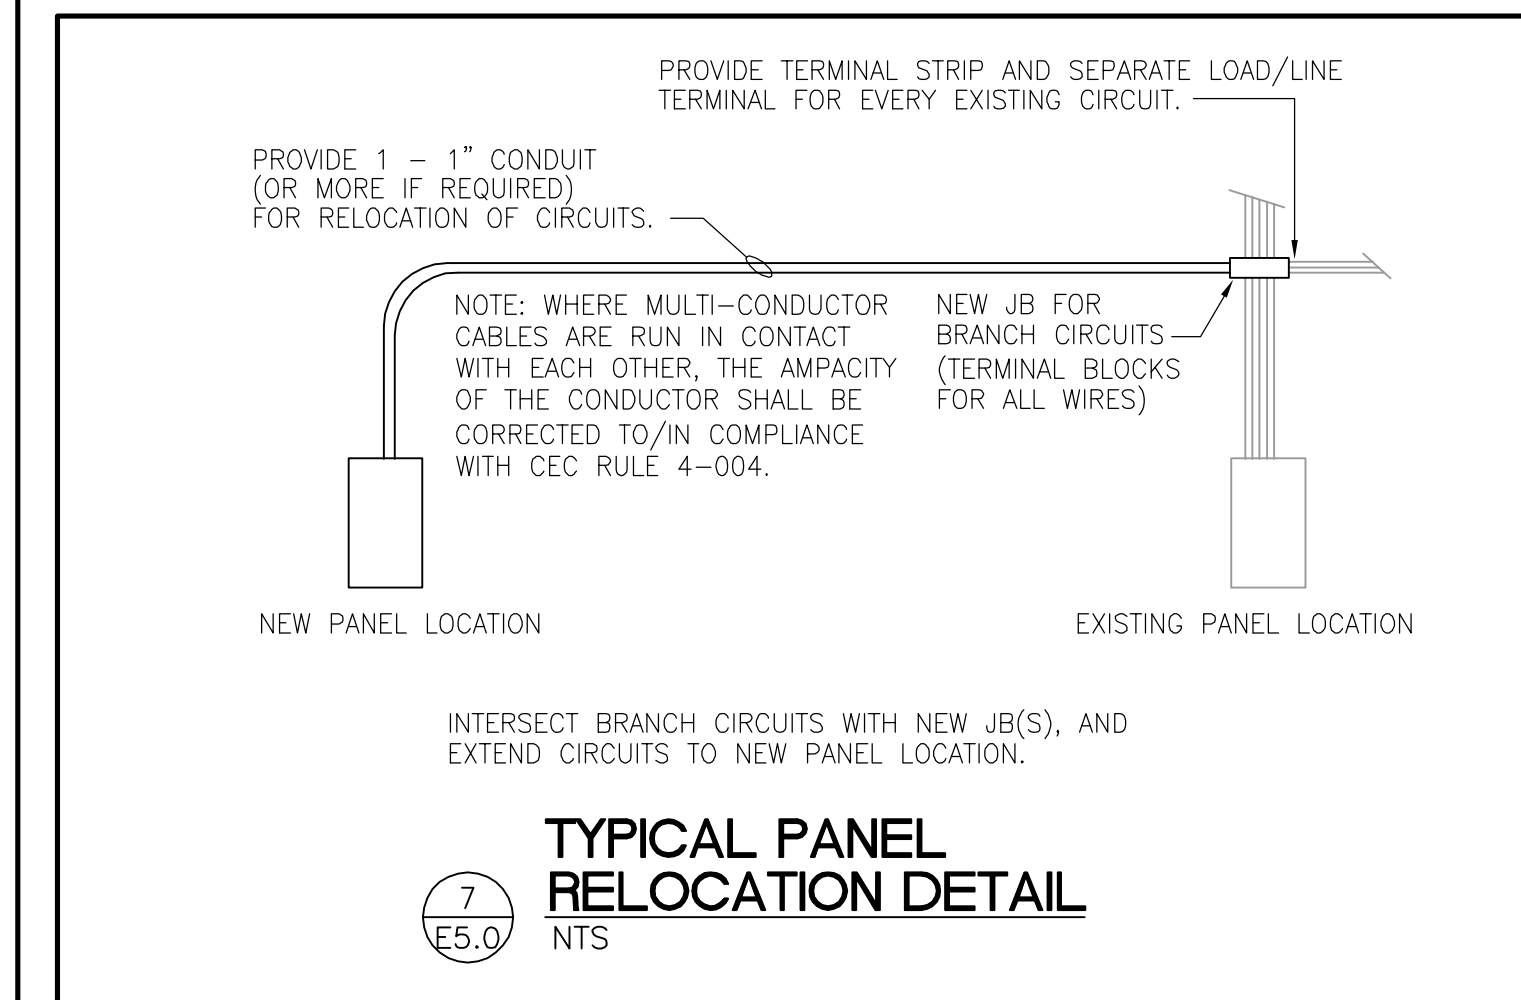

7 TYPICAL PANEL RELOCATION DETAIL  
E5.0 NTS

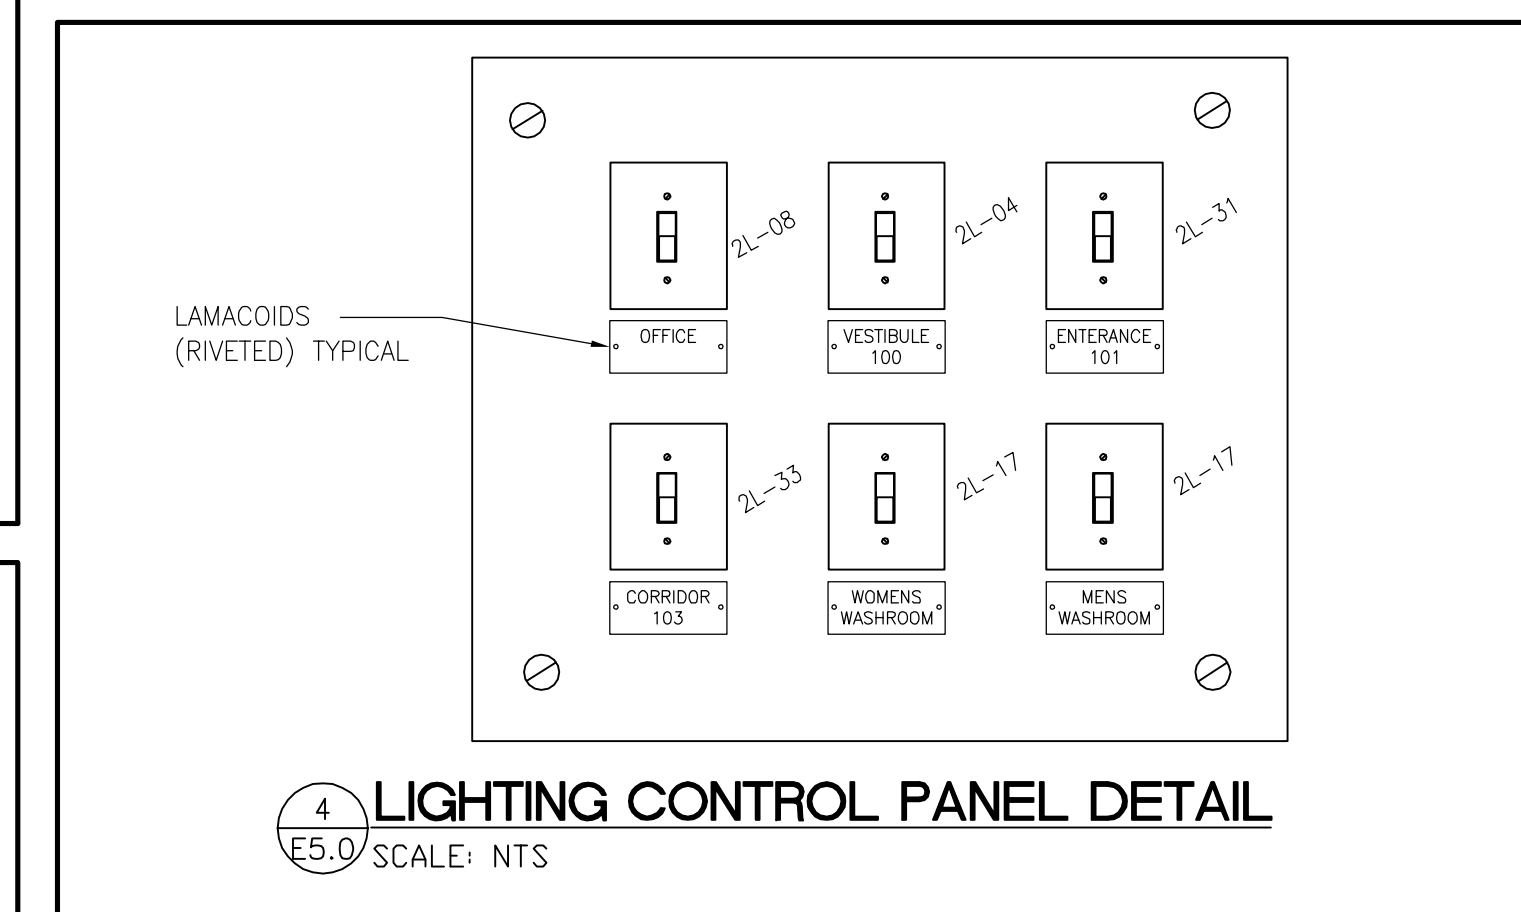

4 LIGHTING CONTROL PANEL DETAIL  
E5.0 SCALE: NTS

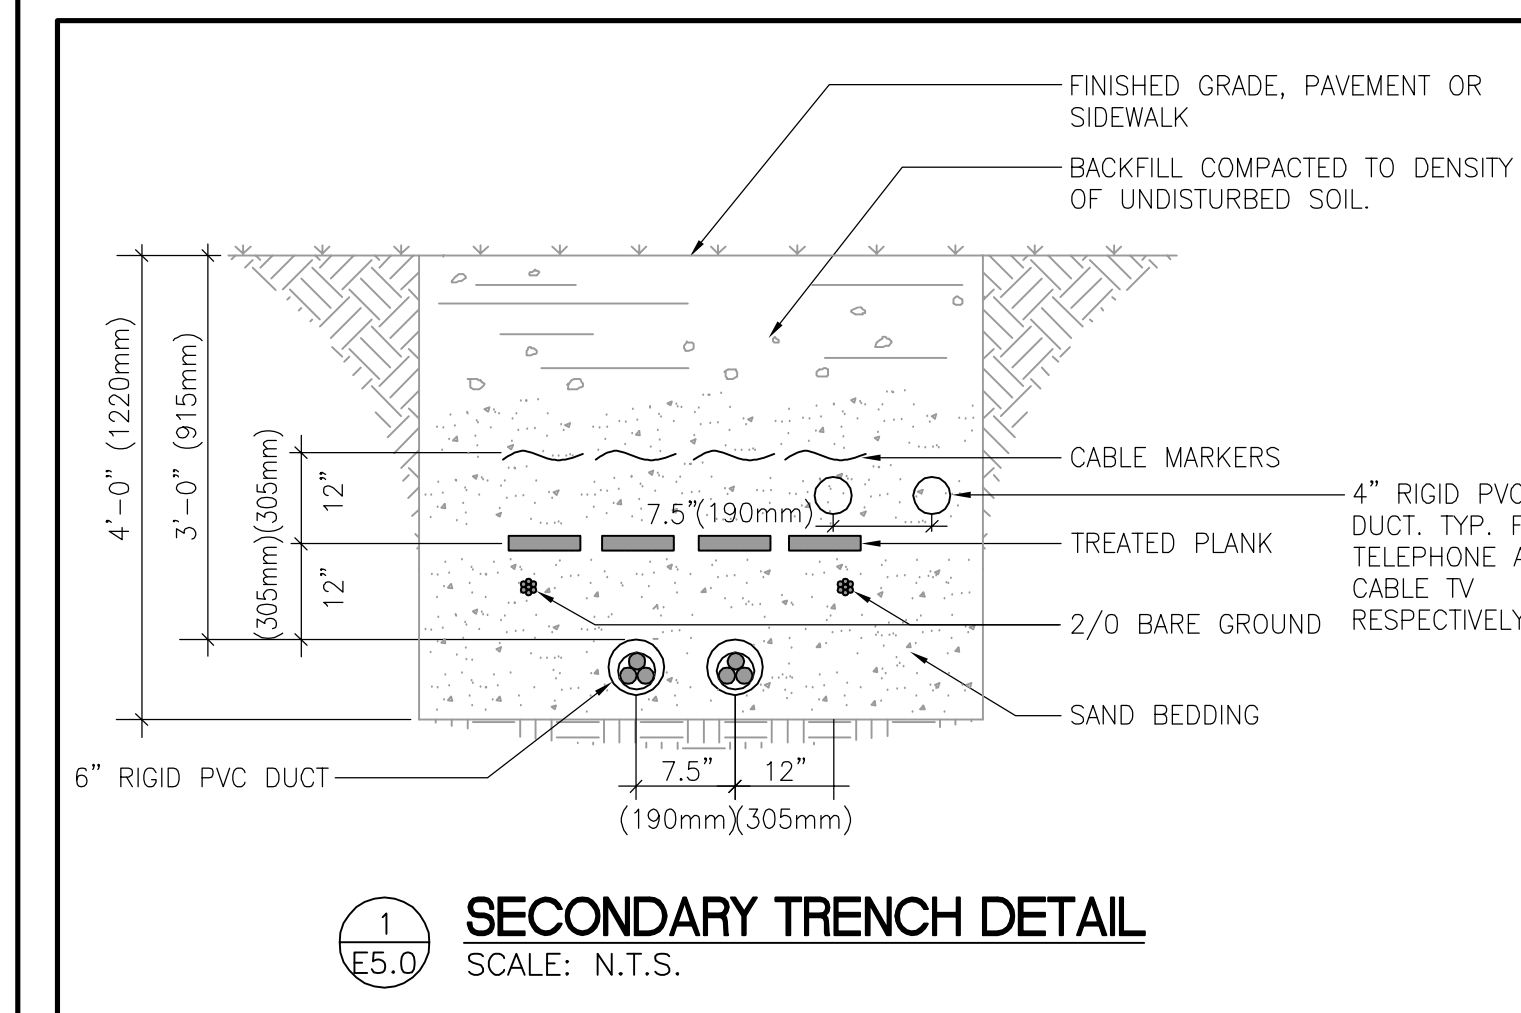

1 SECONDARY TRENCH DETAIL  
E5.0 SCALE: N.T.S.

| NO. | REVISION                   | DATE     | BY |
|-----|----------------------------|----------|----|
| 3   | ISSUED FOR BID OPPORTUNITY | 03/27/08 | TT |
| 2   | ISSUED FOR 90% REVIEW      | 02/07/08 | TT |
| 1   | ISSUED FOR 75% REVIEW      | 01/22/08 | TT |
| 0   | ISSUED FOR 50% REVIEW      | 12/05/07 | TT |

THIS DRAWING IS THE EXCLUSIVE PROPERTY OF THE ARCHITECT AND CAN BE REPRODUCED ONLY WITH THE PERMISSION OF THE ARCHITECT IN WHICH CASE THE REPRODUCTION MUST BEAR THE NAME OF THE ARCHITECT.

THIS DRAWING SHALL NOT BE SCALED. FOLLOW GIVEN DIMENSIONS ONLY. THE CONTRACTOR SHALL SATISFY HIMSELF THAT ALL DIMENSIONS AND INFORMATION SHOWN ARE CORRECT.

PRIOR TO COMMENCEMENT OF WORK REPORT ANY DISCREPANCIES TO THE ARCHITECT. VARIATIONS AND MODIFICATIONS TO WORK SHOWN WILL NOT BE ALLOWED WITHOUT WRITTEN PERMISSION OF THE ARCHITECT.

CONSULTANT: TOWER PROJECT NO. : 6174

**TOWER ENGINEERING GROUP INC.**  
208 - 897 CORDON AVE. WINNIPEG, MB R3M 0W7  
TEL: (204) 925-1150 FAX: (204) 925-1155  
EMAIL: towereng@towereng.ca WEB: www.towereng.ca

**APEGM**  
Certificate of Authorization  
Tower Engineering Group  
No. 1918 Expiry: April 30, 2008

ORIGINAL STAMPED BY:  
THAI TONTHAT, P.ENG  
DATE: 03.27.08

**CALNISKY ASSOCIATES ARCHITECTS**

ARCHITECTURE: 124 Nassau Street North Winnipeg, Manitoba R3L 2H1  
Tel: (204) 453-6441 Fax: (204) 453-3392  
E-mail: caa@escape.ca

PROJECT TITLE: NORBERRY-GLENLEE COMMUNITY CENTRE EXPANSION  
26 MOLGAT AVENUE WINNIPEG, MB

SHEET TITLE: ELECTRICAL DETAILS

| DRAWN BY       | SCALE    | SHEET NUMBER |
|----------------|----------|--------------|
| DR             | AS NOTED | E-5.0        |
| CHECKED BY     | DATE     |              |
| TT             | 03/27/08 |              |
| PROJECT NUMBER | REVISION |              |
| 06-017         | 3        |              |