



PARTIAL SITE PLAN
1 : 2000

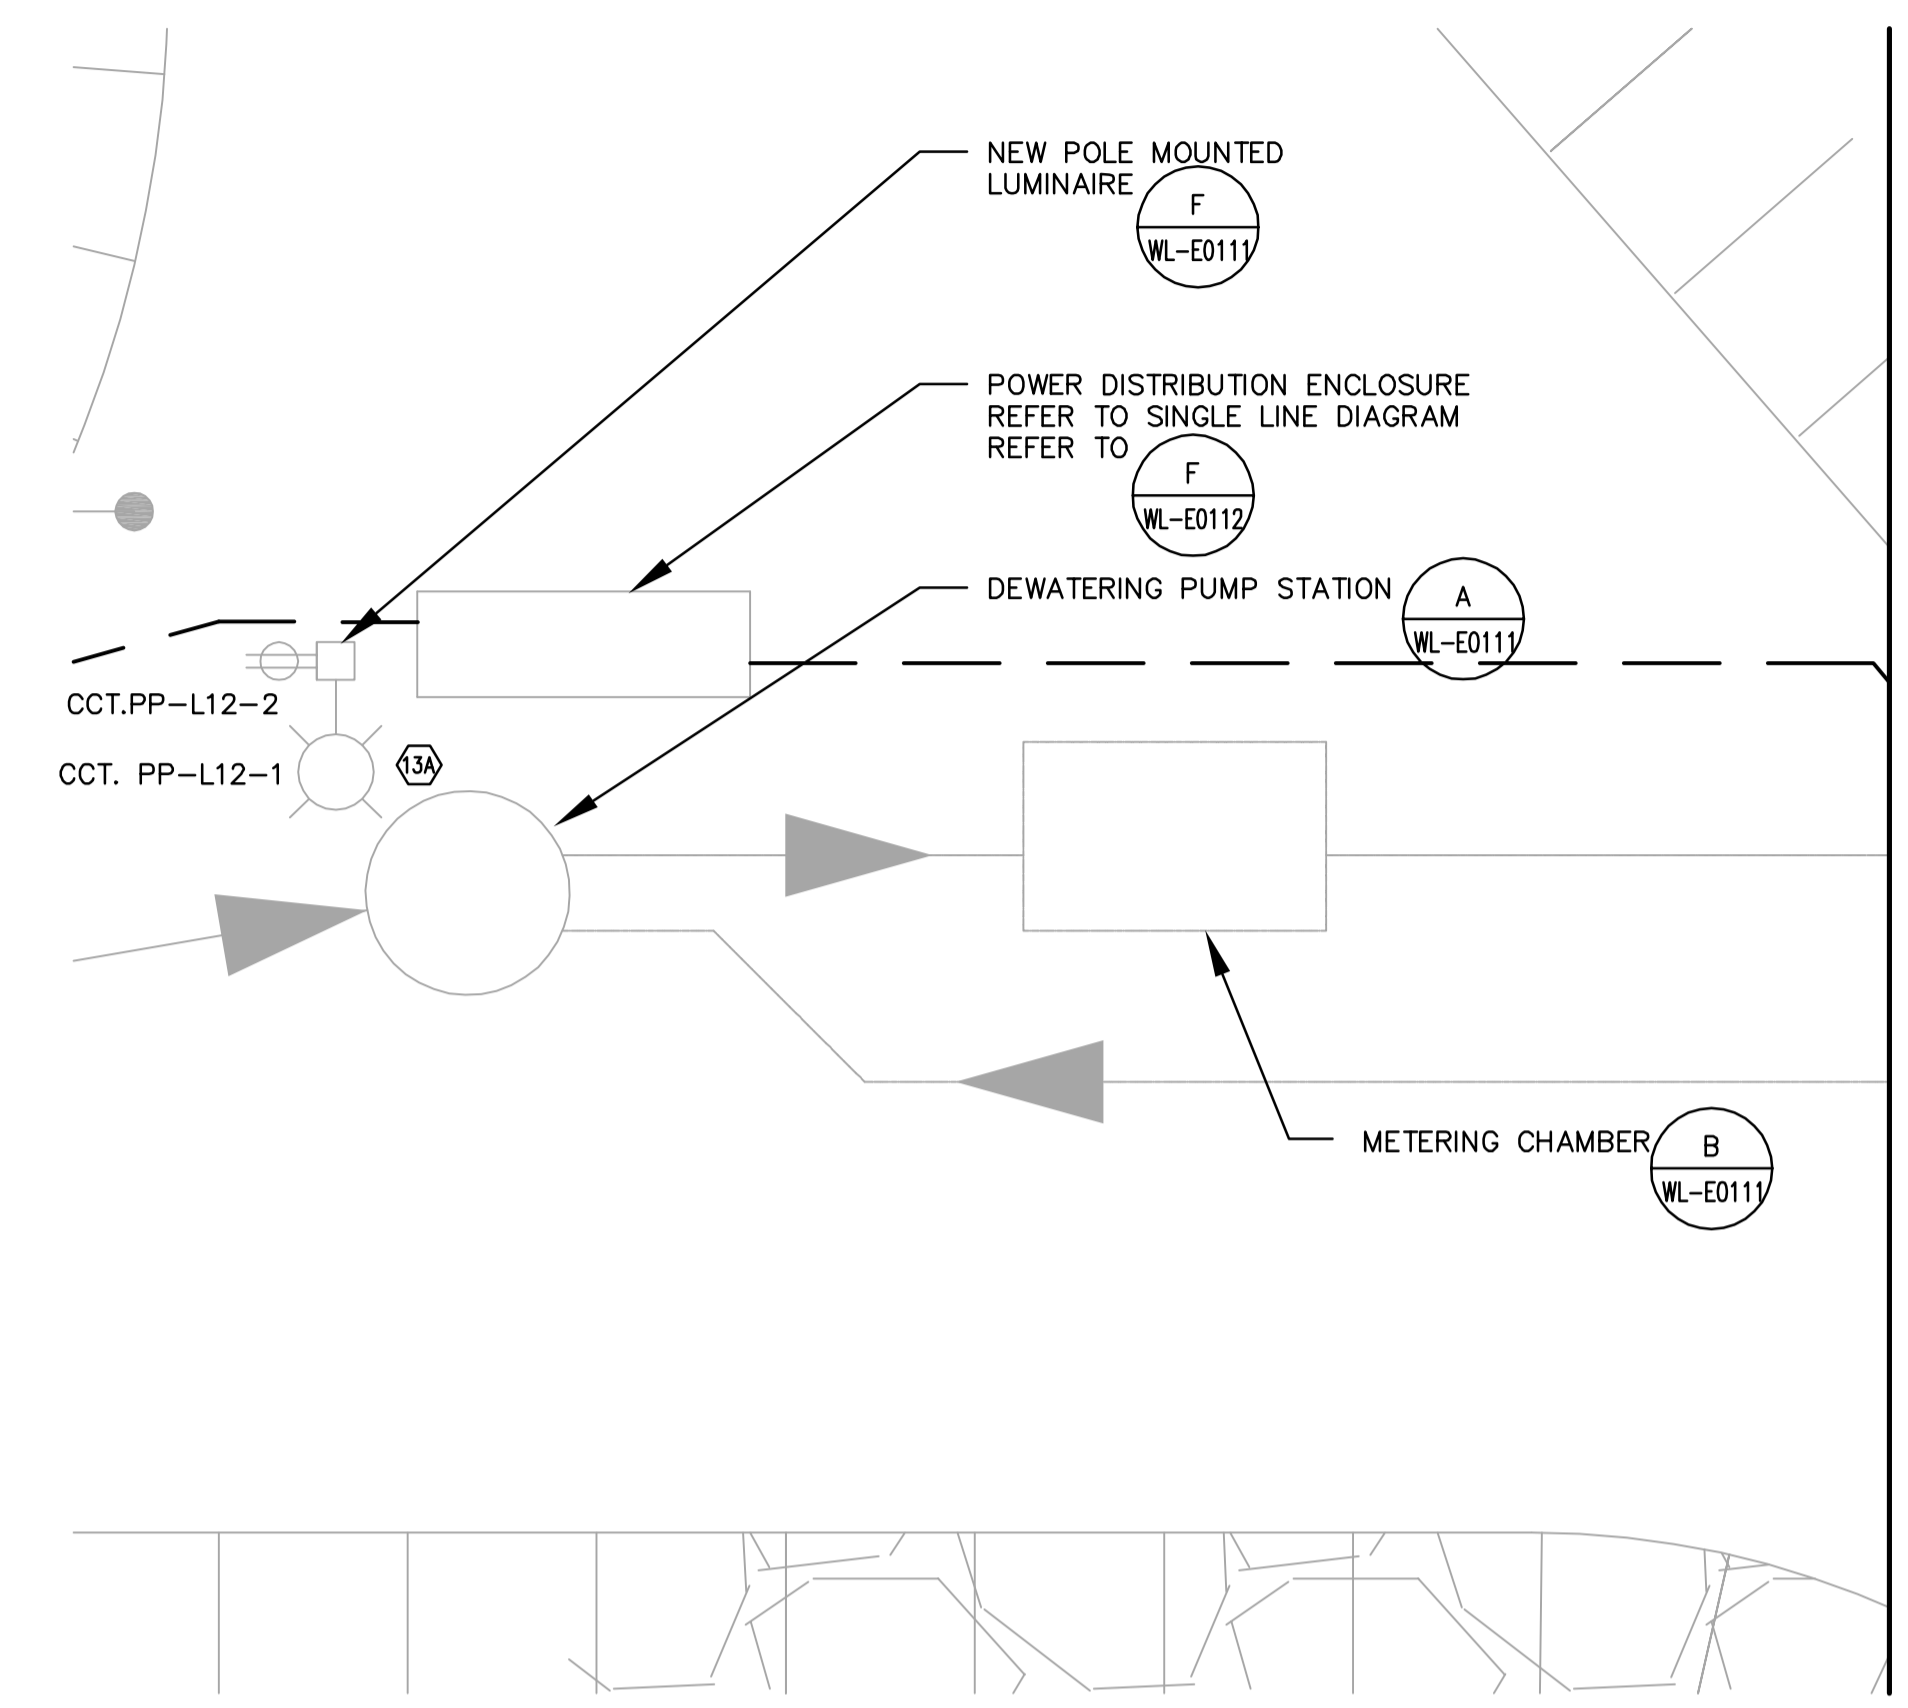

A DETAIL
1 : 100

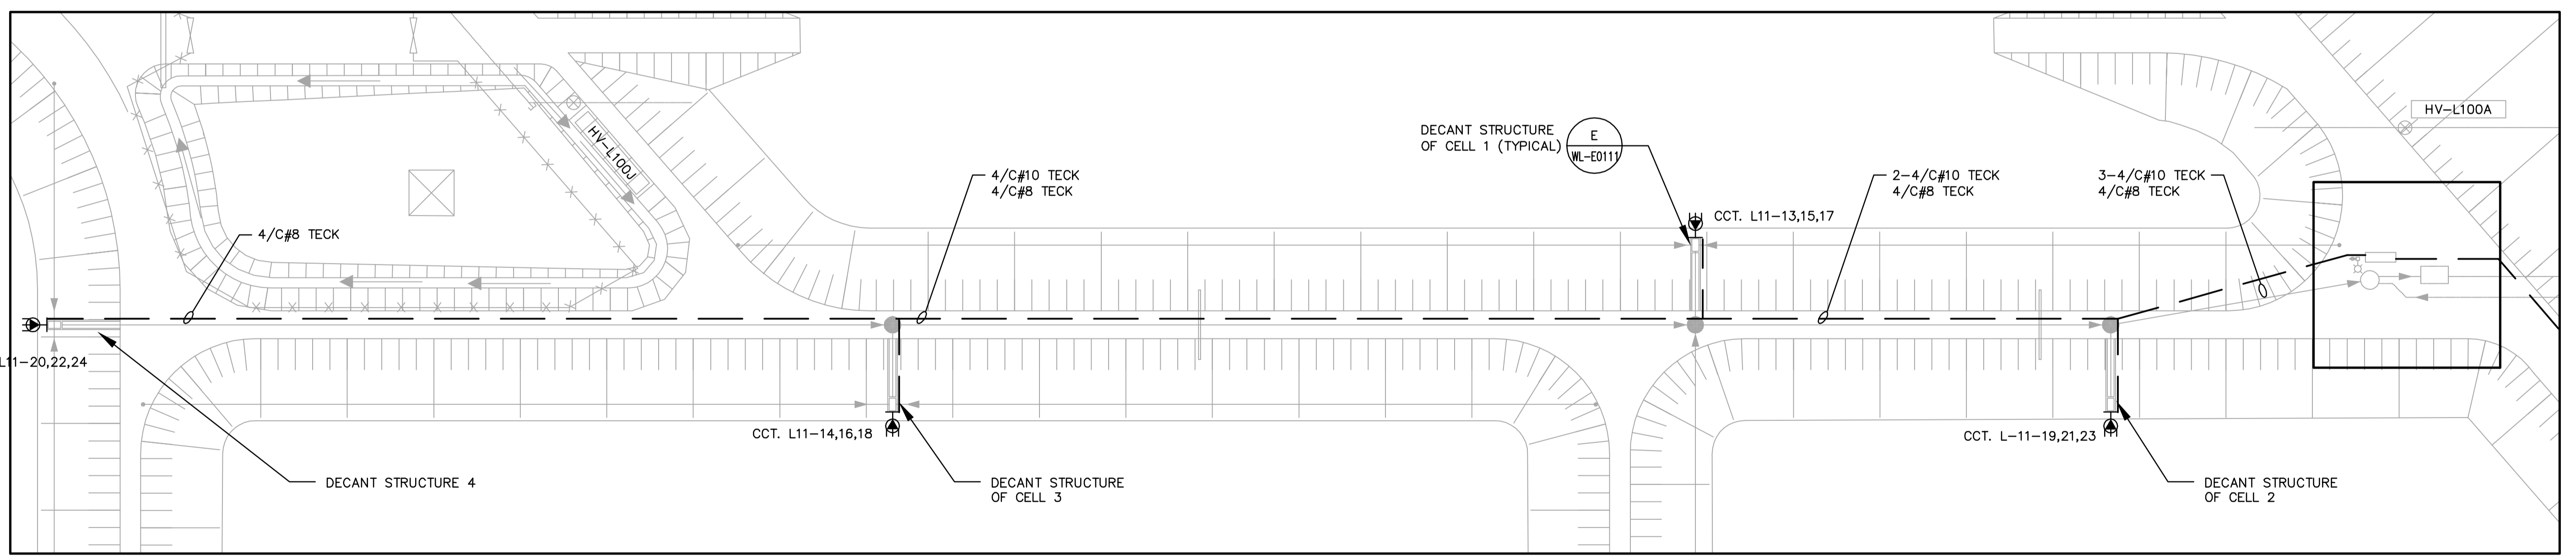

B DETAIL
1 : 500

APEGM
Certificate of Authorization
Earth Tech Canada Inc.
No. 730 Expiry: April 30, 2007

NO.	REVISIONS	DATE	BY
02	ISSUED FOR TENDER (94-2007)	07/02/20	ERC
01	ISSUED FOR CONSTRUCTION	06/06/06	JBC
00	ISSUED FOR TENDER	06/03/07	ERC

CH2M HILL Frederickson Cooper ARCHITECTS		EarthTech A Tyco International Ltd. Company	
DESIGNED BY	BLM	CHECKED BY	PS
DRAWN BY	ERC	APPROVED BY	DJT
SCALE:	AS SHOWN	RELEASED FOR CONSTRUCTION BY:	R. SOROKOWSKI
DATE	2006/01/03	DATE	06/03/07

ENGINEER'S SEAL
ORIGINAL SIGNED BY
B.L. MOORE
2006/03/07
CONSULTANT DRAWING NO.
WL-E0110

THE CITY OF WINNIPEG
WATER AND WASTE DEPARTMENT
ENGINEERING DIVISION

WATER TREATMENT PLANT
CONSTRUCTION OF DEWATERING CELLS

ELECTRICAL
DECANT SYSTEMS
PLANS AND DETAILS

CITY FILE NUMBER
SHEET OF
CITY DRAWING NUMBER
1-0601L-A-E0110-001-02D