



SEE BELOW FOR CONTINUATION

SEE ABOVE FOR CONTINUATION

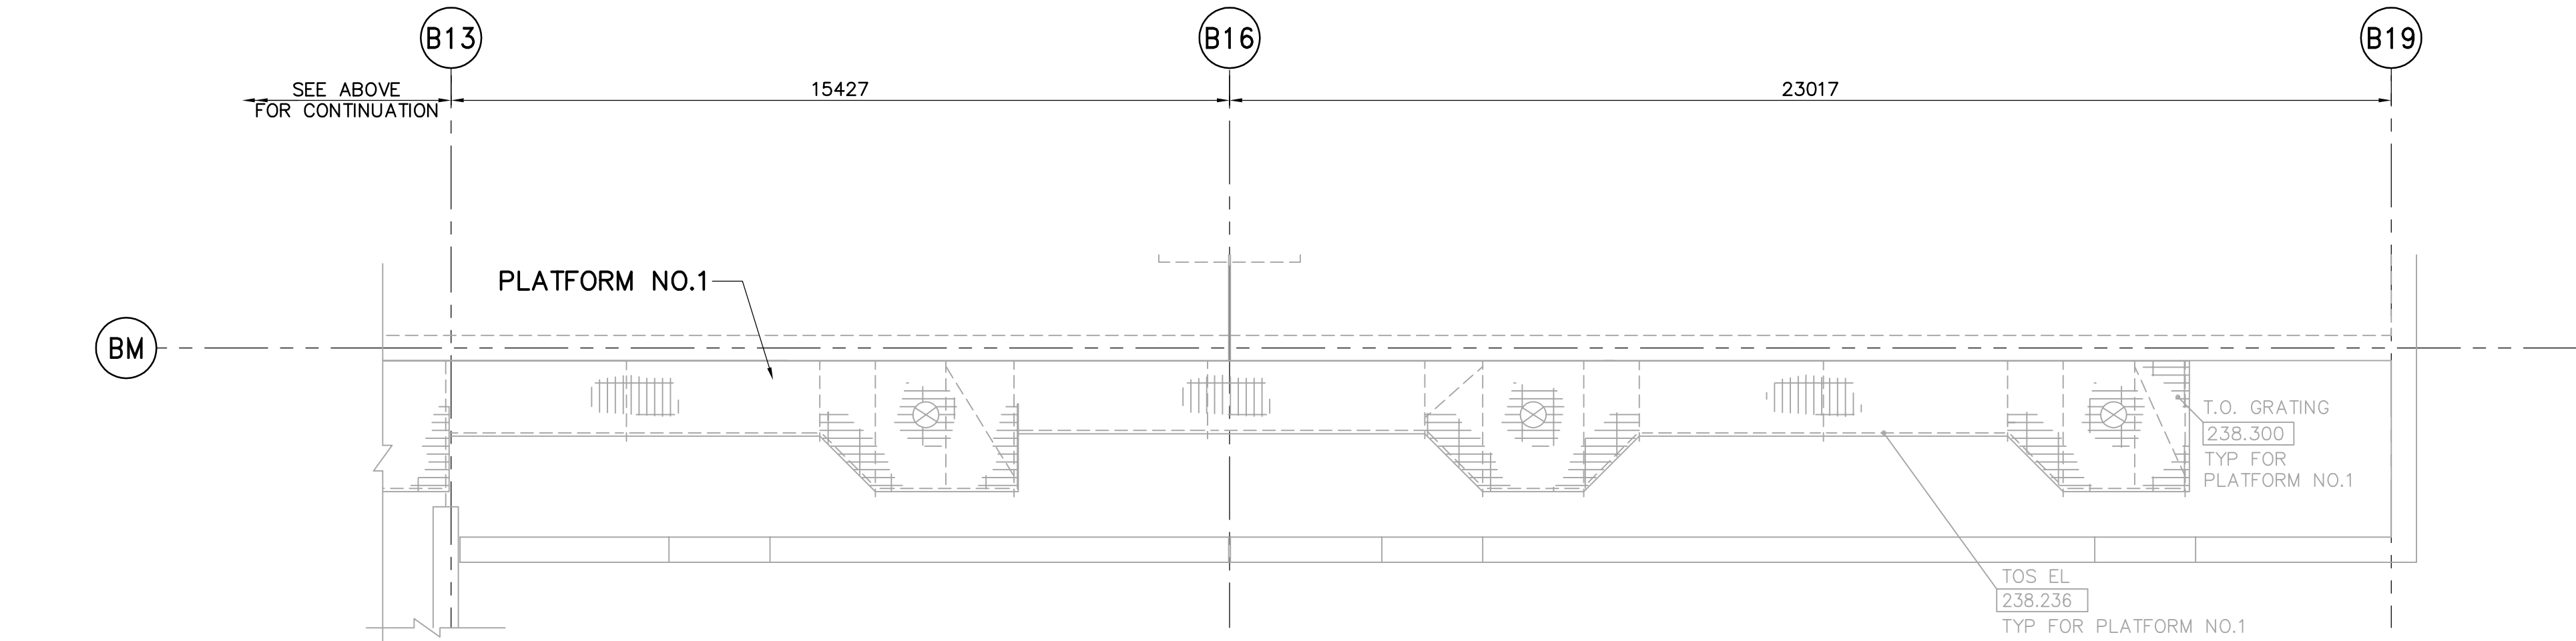


**NOTES:**

1. FOR STAIRS AND HANDRAILS TO PLATFORMS AT ALL LEVELS, SEE ARCHITECTURAL DRAWINGS.
2. COORDINATE ALL FABRICATION WITH BO 742-2005 CONTRACTOR.

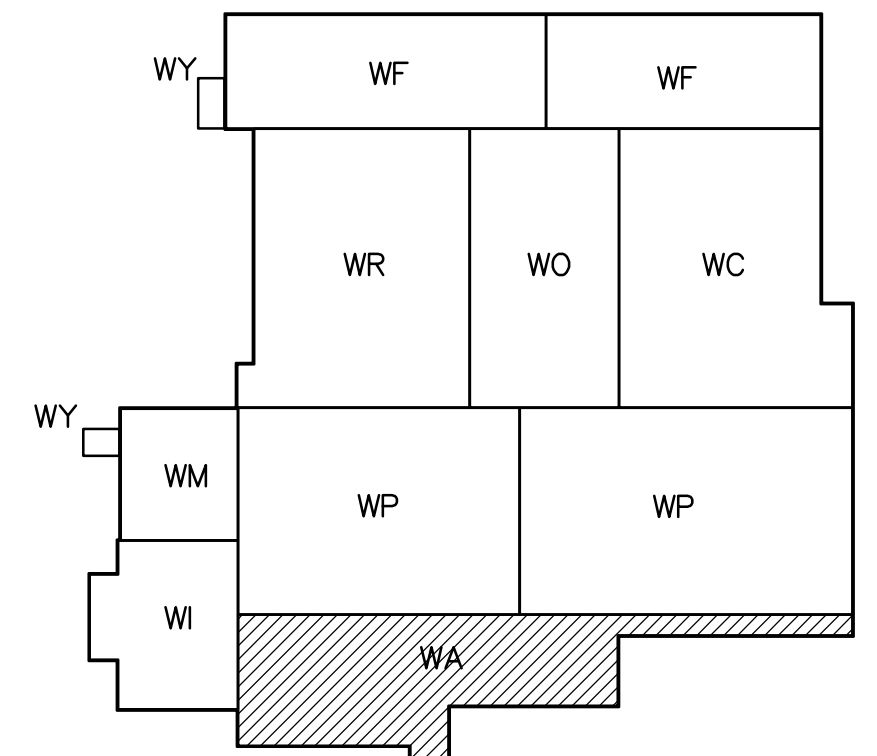

KEY PLAN

FIRST FLOOR PLAN  
1:100

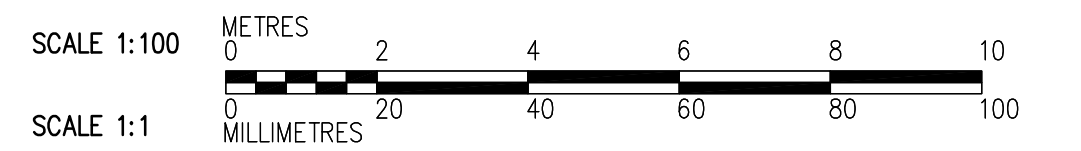

<p>Certificate of Authorization CH2M HILL Canada Ltd. No. 1441 Expiry: April 30, 2008</p>					ENGINEER'S SEAL ORIGINAL SIGNED BY C. MILITANO 2007/06/05	<p>THE CITY OF WINNIPEG WATER AND WASTE DEPARTMENT ENGINEERING DIVISION</p>
	DESIGNED BY	EL	CHECKED BY	AP	WATER TREATMENT PLANT ADMINISTRATION OFFICE AND PLANT INTERIOR FINISHES	
	DRAWN BY	CR	APPROVED BY	AHL		
	SCALE:	1:100	RELEASED FOR CONSTRUCTION BY:	R. SOROKOWSKI	CITY FILE NUMBER SHEET OF CITY DRAWING NUMBER 1-0601A-A-S4116-001-000	
NO.	ISSUED FOR TENDER	07/06/05	EL	DATE	2007/06/05	STRUCTURAL ADMINISTRATION AREA FIRST FLOOR PLAN
NO.	REVISIONS	DATE	BY	DATE	2007/05/06	CONSULTANT DRAWING NO. WA-S4116