



NOTE: CEILING HEIGHTS SHOWN ARE TO BE MEASURED FROM EACH ROOM'S RESPECTIVE FINISH FLOOR ELEVATIONS.

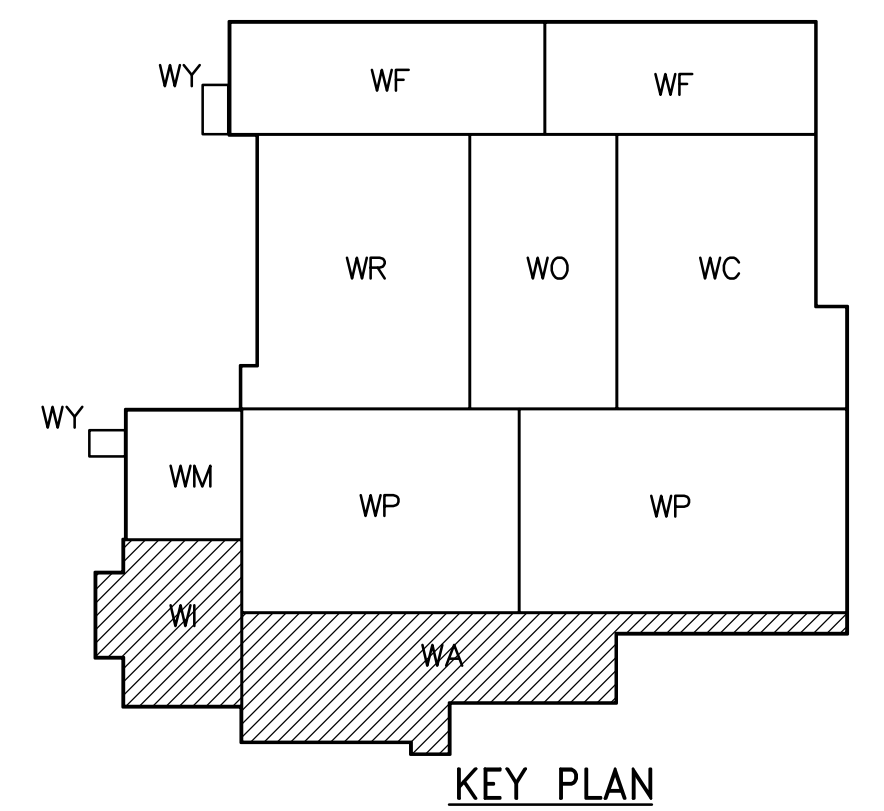

1 PARTIAL REFLECTED CEILING PLAN - ADMINISTRATION AREA (SECOND FLOOR)
WB-B0152 1:100

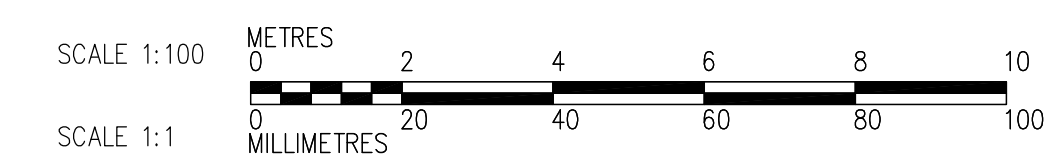

B.M. ELEV.	
DESIGNED BY	TWS
DRAWN BY	AL/LK
SCALE:	1:100
00 ISSUED FOR TENDER	07/06/05 LK
NO. REVISIONS	DATE BY
	DATE 2005/08/03

CH2MHILL Frederickson Cooper ARCHITECTS	EarthTech A Top International Lic. Company
DESIGNED BY: TWS	CHECKED BY: BJS
DRAWN BY: AL/LK	APPROVED BY: AHL
SCALE: 1:100	RELEASED FOR CONSTRUCTION BY: R. SOROKOWSKI
DATE: 2005/08/03	DATE: 2007/06/05

ENGINEER'S SEAL	
ORIGINAL SIGNED BY	NEIL COOPER
	2007/06/05
CONSULTANT DRAWING NO.	WB-B0152

THE CITY OF WINNIPEG	
WATER AND WASTE DEPARTMENT	
ENGINEERING DIVISION	
WATER TREATMENT PLANT MAIN BUILDING OFFICE AND PLANT INTERIOR FINISHES	CITY FILE NUMBER
ARCHITECTURAL PARTIAL REFLECTED CEILING PLAN OF ADMINISTRATION AREA	SHEET OF
	CITY DRAWING NUMBER
	1-060B-A-B0152-001-000