 
 
 




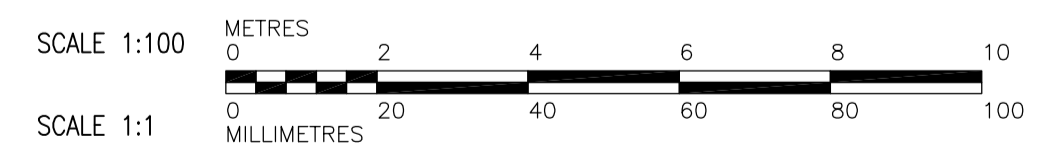

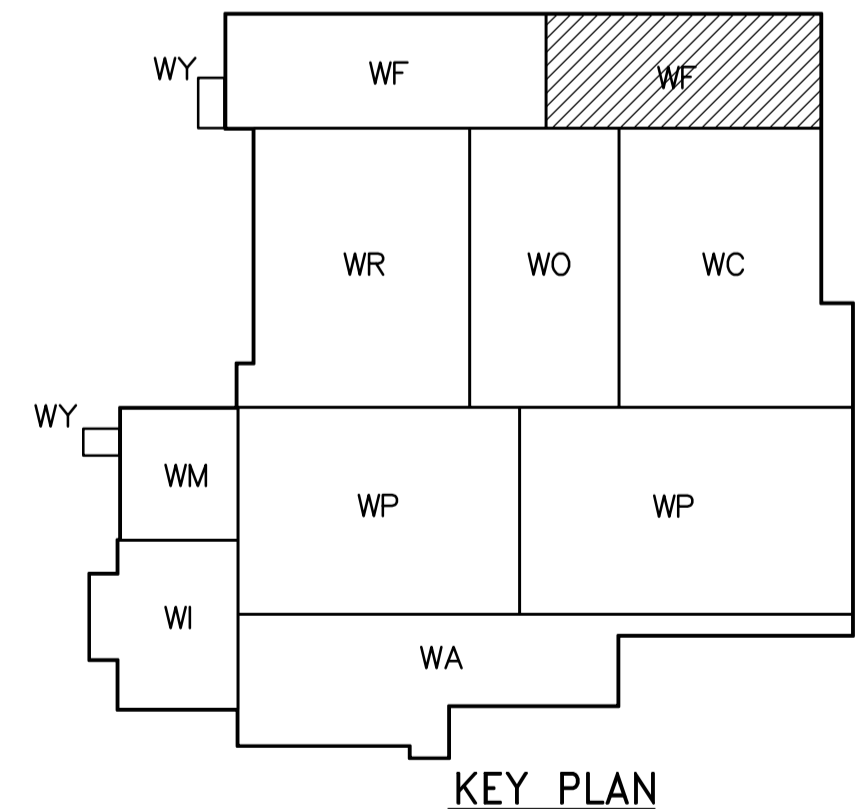

THIRD FLOOR PLAN AT EL 245.000
1:100

NOTES:

1. FOR WALL CONTROL JOINTS SEE ARCHITECTURAL DRAWINGS.
2. SEE DETAIL  FOR OPENING REINFORCING.
WB-S4451
3. USE NO.9 ASWG@400 FOR JOINT REINFORCEMENT.
4. FOR DETAILS OF LINTELS, BOND BEAMS, AND CORE FILLS REFER TO  AND .
WB-S4451 WB-S4451
5. COORDINATE EXACT DIMENSIONS AND LOCATIONS OF OPENINGS WITH B0 742-2005 CONTRACTOR.



 Certificate of Authorization CH2M HILL Canada Ltd. No. 1441 Expiry: April 30, 2008	B.M. ELEV.	 Frederickson Cooper ARCHITECTS	 A Tyco International Ltd. Company	ENGINEER'S SEAL	 THE CITY OF WINNIPEG WATER AND WASTE DEPARTMENT ENGINEERING DIVISION		
				DESIGNED BY: MH		CHECKED BY: AP	ORIGINAL SIGNED BY: C. MILITANO
				DRAWN BY: CR		APPROVED BY: AHL	2007/06/05
	SCALE: 1:100	RELEASED FOR CONSTRUCTION BY: R. SOROKOWSKI		CONSULTANT DRAWING NO. WF-S4132	WATER TREATMENT PLANT FILTRATION OFFICE AND PLANT INTERIOR FINISHES		
	NO. REVISIONS	DATE	BY	DATE	CITY FILE NUMBER		
	00	ISSUED FOR TENDER	07/06/05	MH	SHEET OF		
				2007/06/05	CITY DRAWING NUMBER		
				2007/05/06	1-0601F-A-S4132-001-000		
					STRUCTURAL FILTRATION AREA 2 THIRD FLOOR PLAN		