
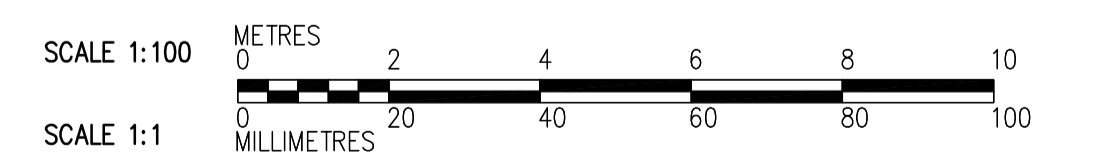


THIRD FLOOR PLAN
1:100

NOTES:

- FOR WALL CONTROL JOINTS SEE ARCHITECTURAL DRAWINGS.
- SEE DETAIL FOR OPENING REINFORCING.
WB-S4451
- USE NO.9 ASWG@400 FOR JOINT REINFORCEMENT.
- FOR DETAILS OF LINTELS, BOND BEAMS, AND CORE FILLS REFER TO AND .
WB-S4451 WB-S4451
- COORDINATE EXACT DIMENSIONS AND LOCATIONS OF OPENINGS WITH B0 742-2005 CONTRACTOR.

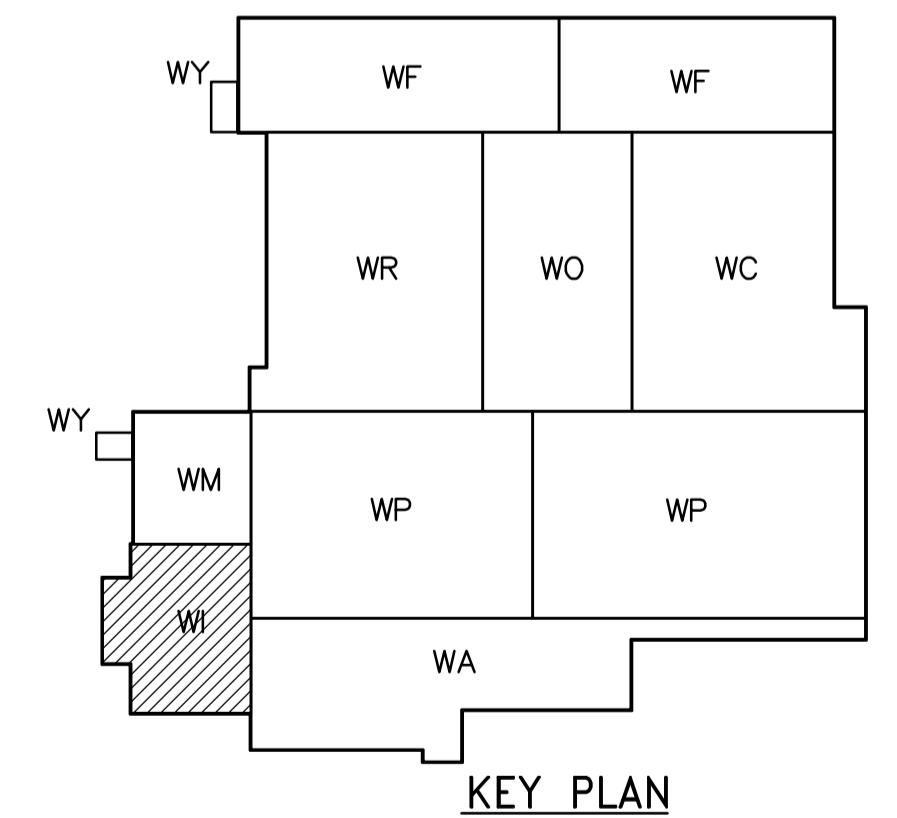

<p>Certificate of Authorization CH2M HILL Canada Ltd. No. 1441 Expiry: April 30, 2008</p>					ENGINEER'S SEAL ORIGINAL SIGNED BY C. MILITANO 2007/06/05		THE CITY OF WINNIPEG WATER AND WASTE DEPARTMENT ENGINEERING DIVISION	
	DESIGNED BY EL CHECKED BY AP		DRAWN BY CR APPROVED BY AHL		CONSULTANT DRAWING NO. WI-S4131		WATER TREATMENT PLANT INLET WORKS AND RAW WATER PUMPING OFFICE AND PLANT INTERIOR FINISHES	
	SCALE: 1:100 RELEASED FOR CONSTRUCTION BY: R. SOROKOWSKI		DATE 2007/06/05 DATE 2007/05/06		STRUCTURAL RAW WATER PUMP STATION AREA THIRD FLOOR PLAN		CITY FILE NUMBER SHEET OF CITY DRAWING NUMBER 1-06011-A-S4131-001-000	
	B.M. ELEV.		NO. REVISIONS DATE BY		00 ISSUED FOR TENDER 07/06/05 EL		1-06011-A-S4131-001-000	