



FIRST FLOOR PLAN
1:100

NOTES:

1. FOR WALL CONTROL JOINTS SEE ARCHITECTURAL DRAWINGS.
2. SEE DETAIL FOR OPENING REINFORCING.
3. USE NO.9 ASWG@400 FOR JOINT REINFORCEMENT.
4. FOR DETAILS OF LINTELS, BOND BEAMS, AND CORE FILLS REFER TO AND .
5. COORDINATE EXACT DIMENSIONS AND LOCATIONS OF OPENINGS WITH B0 742-2005 CONTRACTOR.

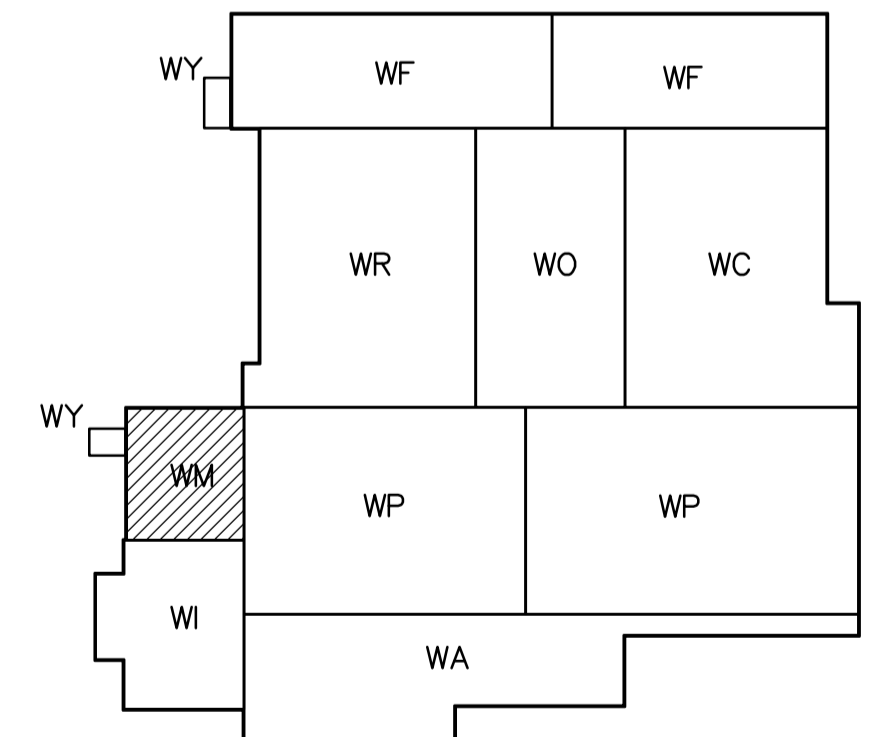

KEY PLAN

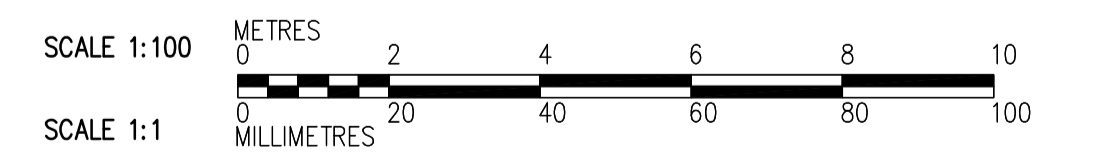

 APEGM Certificate of Authorization CH2M HILL Canada Ltd. No. 1441 Expiry: April 30, 2008	B.M. ELEV.	 Frederickson Cooper ARCHITECTS	 EarthTech A Tyco International Ltd. Company	ENGINEER'S SEAL	 THE CITY OF WINNIPEG WATER AND WASTE DEPARTMENT ENGINEERING DIVISION WATER TREATMENT PLANT GENERAL PLANT SERVICES/MISCELLANEOUS OFFICE AND PLANT INTERIOR FINISHES STRUCTURAL ELECTRICAL ROOM FIRST FLOOR PLAN	CITY FILE NUMBER
		DESIGNED BY: MH	CHECKED BY: AP	ORIGINAL SIGNED BY: C. MILITANO		SHEET OF
		DRAWN BY: CR	APPROVED BY: AHL	2007/06/05		
		SCALE: AS NOTED	RELEASED FOR CONSTRUCTION BY: R. SOROKOWSKI	CONSULTANT DRAWING NO. WM-S4111		CITY DRAWING NUMBER 1-0601M-A-S4111-001-000
	NO. REVISIONS	DATE	BY	DATE		
	00	ISSUED FOR TENDER	07/06/05	MH	2007/06/05	2007/05/06