 
 

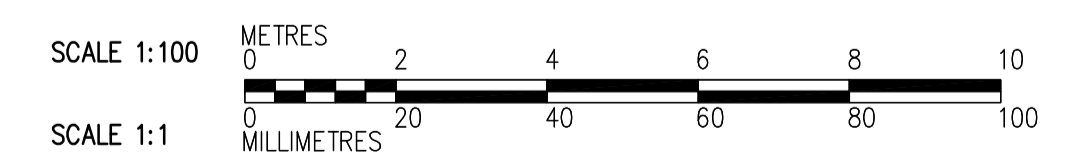
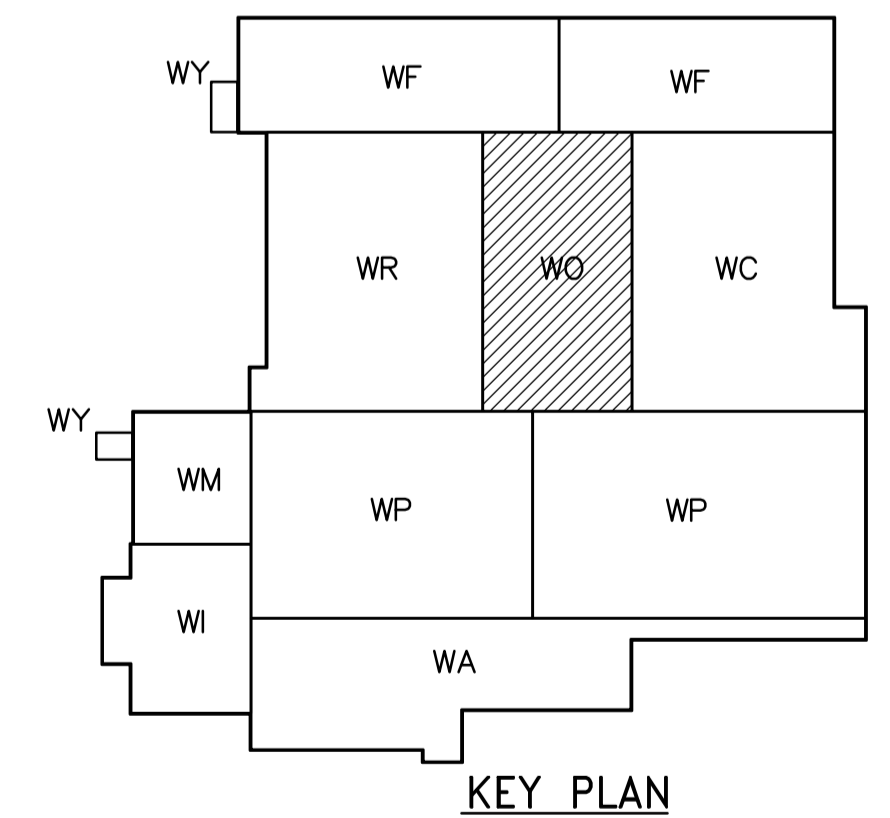
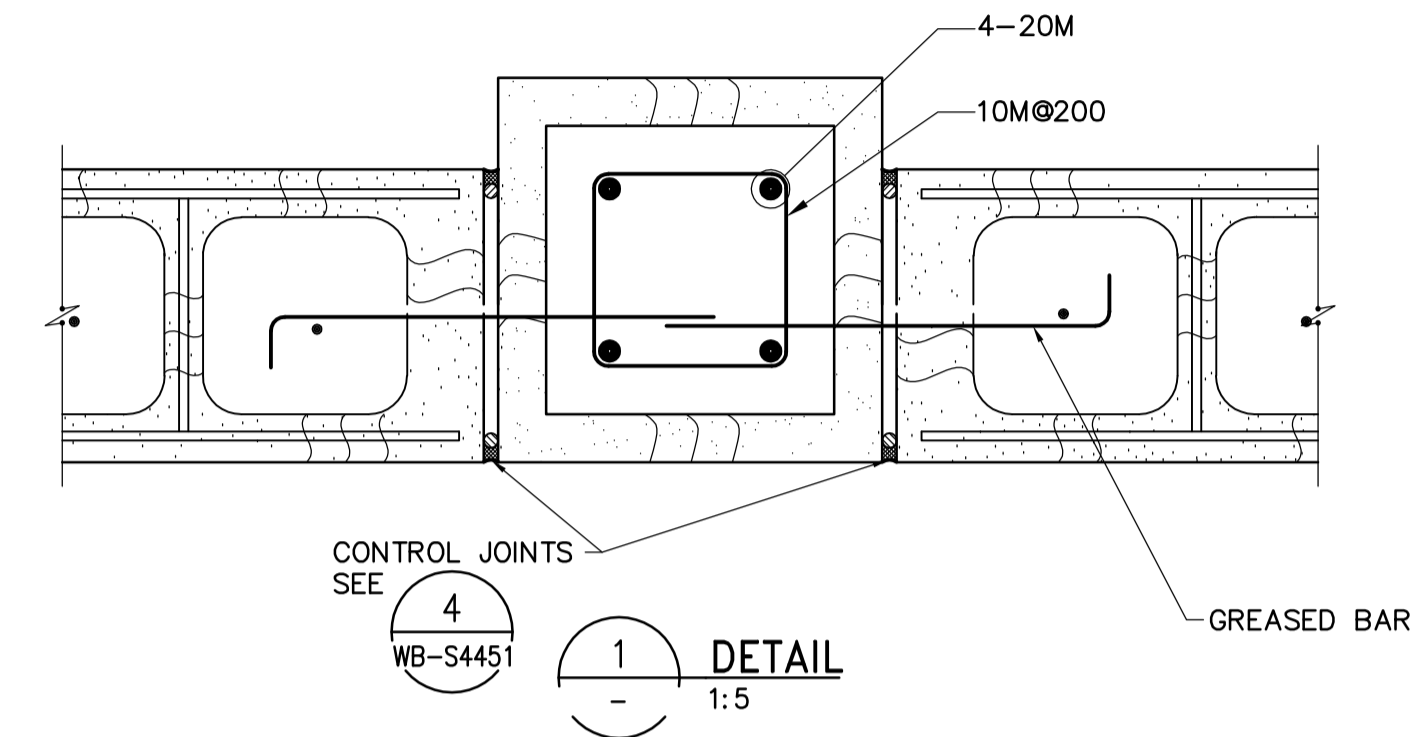






THIRD FLOOR PLAN
1:100

NOTES:

- FOR WALL CONTROL JOINTS SEE ARCHITECTURAL DRAWINGS.
- SEE DETAIL  FOR OPENING REINFORCING.
WB-S4451
- USE NO.9 ASWG@400 FOR JOINT REINFORCEMENT.
- FOR DETAILS OF LINTELS, BOND BEAMS, AND CORE FILLS REFER TO  AND .
WB-S4451 WB-S4451
- COORDINATE EXACT DIMENSIONS AND LOCATIONS OF OPENINGS WITH BO 742-2005 CONTRACTOR.



 Certificate of Authorization CH2M HILL Canada Ltd. No. 1441 Expiry: April 30, 2008	B.M. ELEV.		 Frederickson Cooper ARCHITECTS	 A Tyco International Ltd. Company	ENGINEER'S SEAL ORIGINAL SIGNED BY C. MILITANO 2007/06/05	 THE CITY OF WINNIPEG WATER AND WASTE DEPARTMENT ENGINEERING DIVISION WATER TREATMENT PLANT OZONE OFFICE AND PLAN INTERIOR FINISHES STRUCTURAL OZONATION AREA THIRD FLOOR PLAN	CITY FILE NUMBER
	DESIGNED BY MH CHECKED BY AP		RELEASED FOR CONSTRUCTION BY: R. SOROKOWSKI	CONSULTANT DRAWING NO. WO-S4131	SHEET OF		
	DRAWN BY CR APPROVED BY AHL		SCALE: 1:100	DATE 2007/06/05	CITY DRAWING NUMBER 1-06010-A-S4131-001-000		
	NO. REVISIONS DATE BY		DATE 2007/06/05	DATE 2007/05/06			