



- NOTES:**
- FOR WALL CONTROL JOINTS SEE ARCHITECTURAL DRAWINGS.
 - SEE DETAIL **2** FOR OPENING REINFORCING.
WB-S4451
 - USE NO.9 ASWG@400 FOR JOINT REINFORCEMENT.
 - FOR DETAILS OF LINTELS, BOND BEAMS, AND CORE FILLS REFER TO **2** AND **3**.
WB-S4451 WB-S4451
 - COORDINATE EXACT DIMENSIONS AND LOCATIONS OF OPENINGS WITH BO 742-2005 CONTRACTOR.

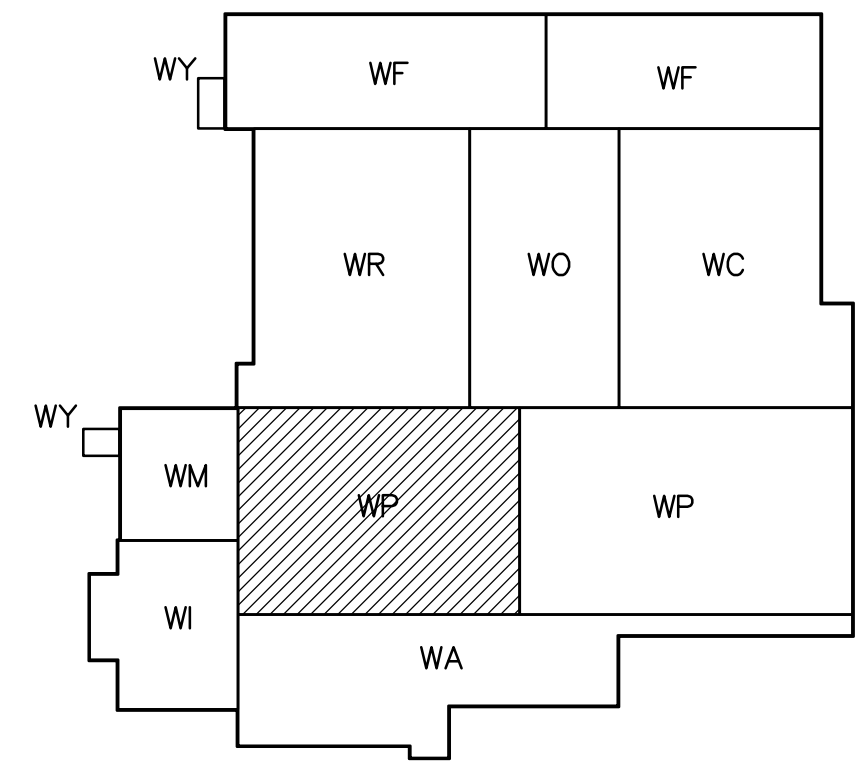

THIRD FLOOR PLAN
1:100

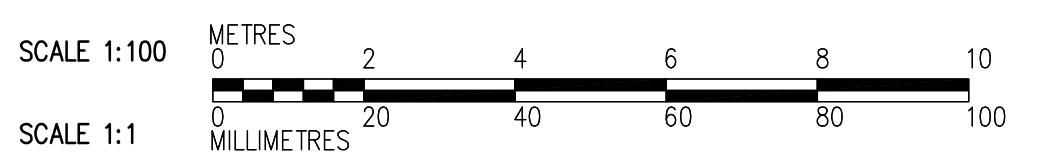

<p>Certificate of Authorization CH2M HILL Canada Ltd. No. 1441 Expiry: April 30, 2008</p>					ENGINEER'S SEAL ORIGINAL SIGNED BY C. MILITANO 2007/06/05	<p>THE CITY OF WINNIPEG WATER AND WASTE DEPARTMENT ENGINEERING DIVISION</p> <p>WATER TREATMENT PLANT FLOCCULATION AND DAF OFFICE AND PLANT INTERIOR FINISHES</p> <p>STRUCTURAL FLOC/DAF AREA 1 THIRD FLOOR PLAN</p>	CITY FILE NUMBER
	DESIGNED BY: MH CHECKED BY: AP	DRAWN BY: CR APPROVED BY: AHL	SCALE: 1:100		CONSULTANT DRAWING NO. WP-S4131		SHEET OF
	NO. REVISIONS		DATE: 2007/06/05	BY: MH	DATE: 2007/05/06		CITY DRAWING NUMBER 1-0601P-A-S4131-001-000
	00 ISSUED FOR TENDER		07/06/05	MH	R. SOROKOWSKI		