



**ROOF DRAINAGE PLAN**  
1:200

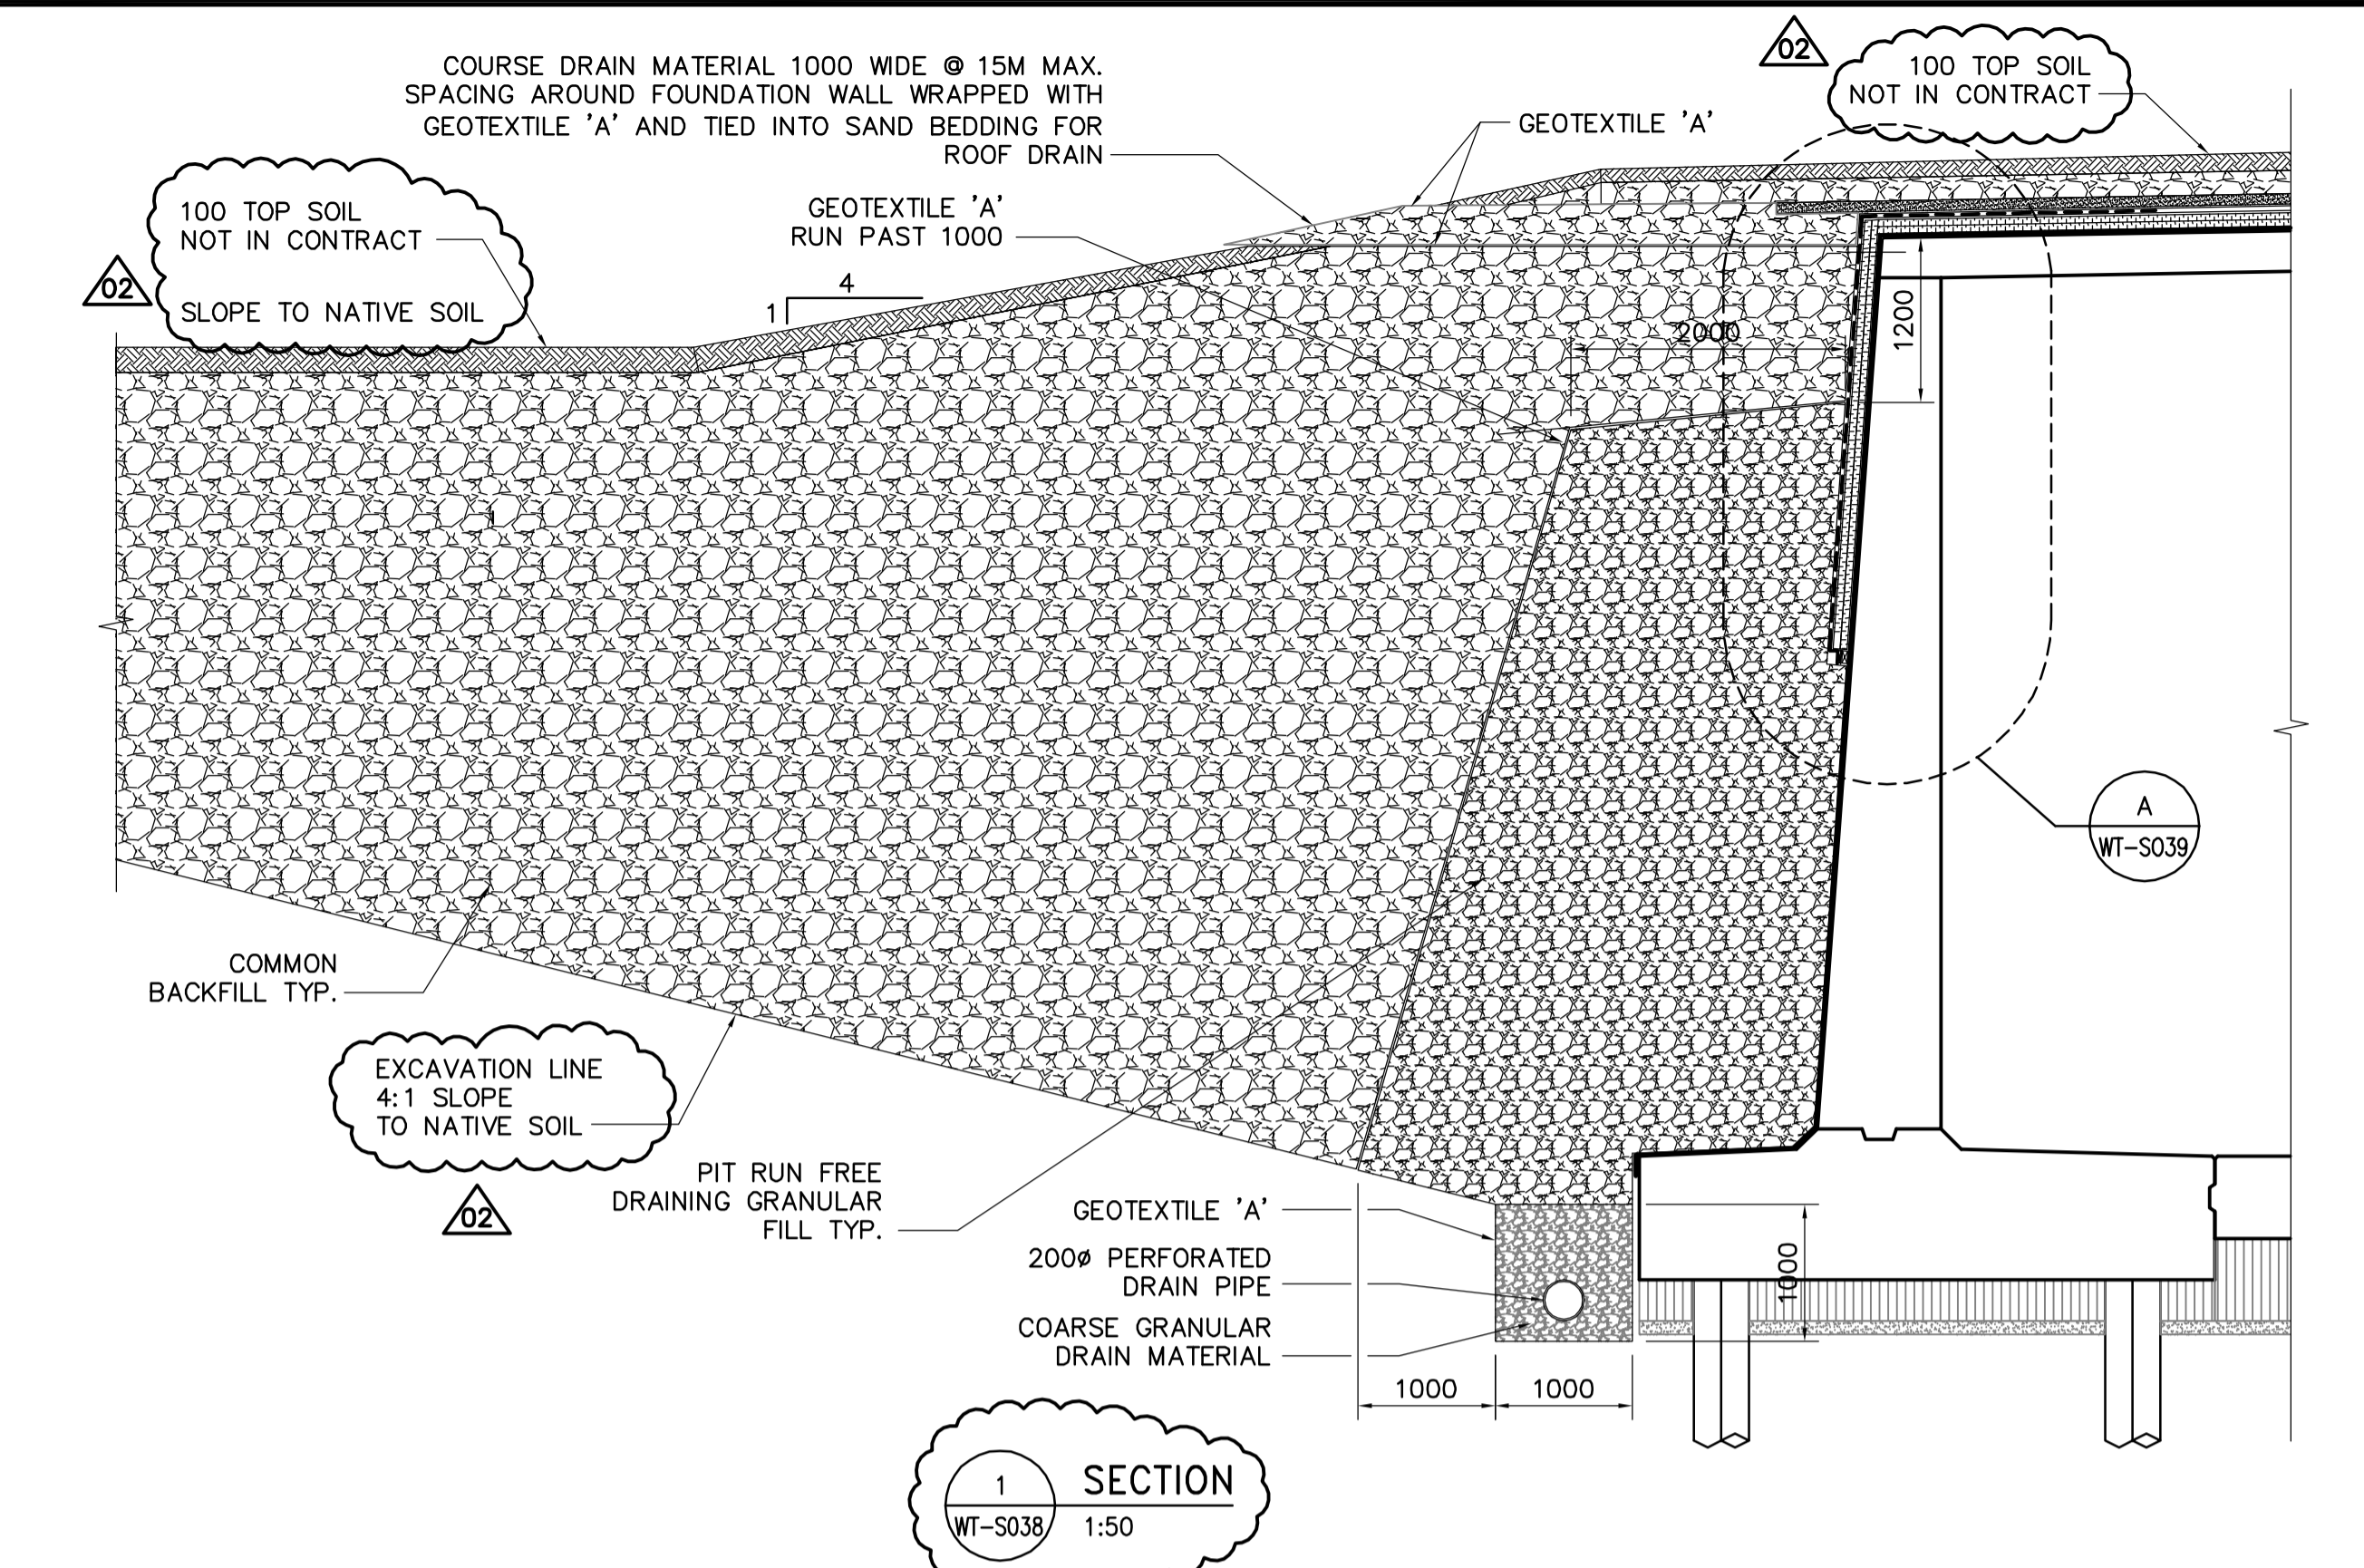

**SECTION 1**  
WT-S038 1:50

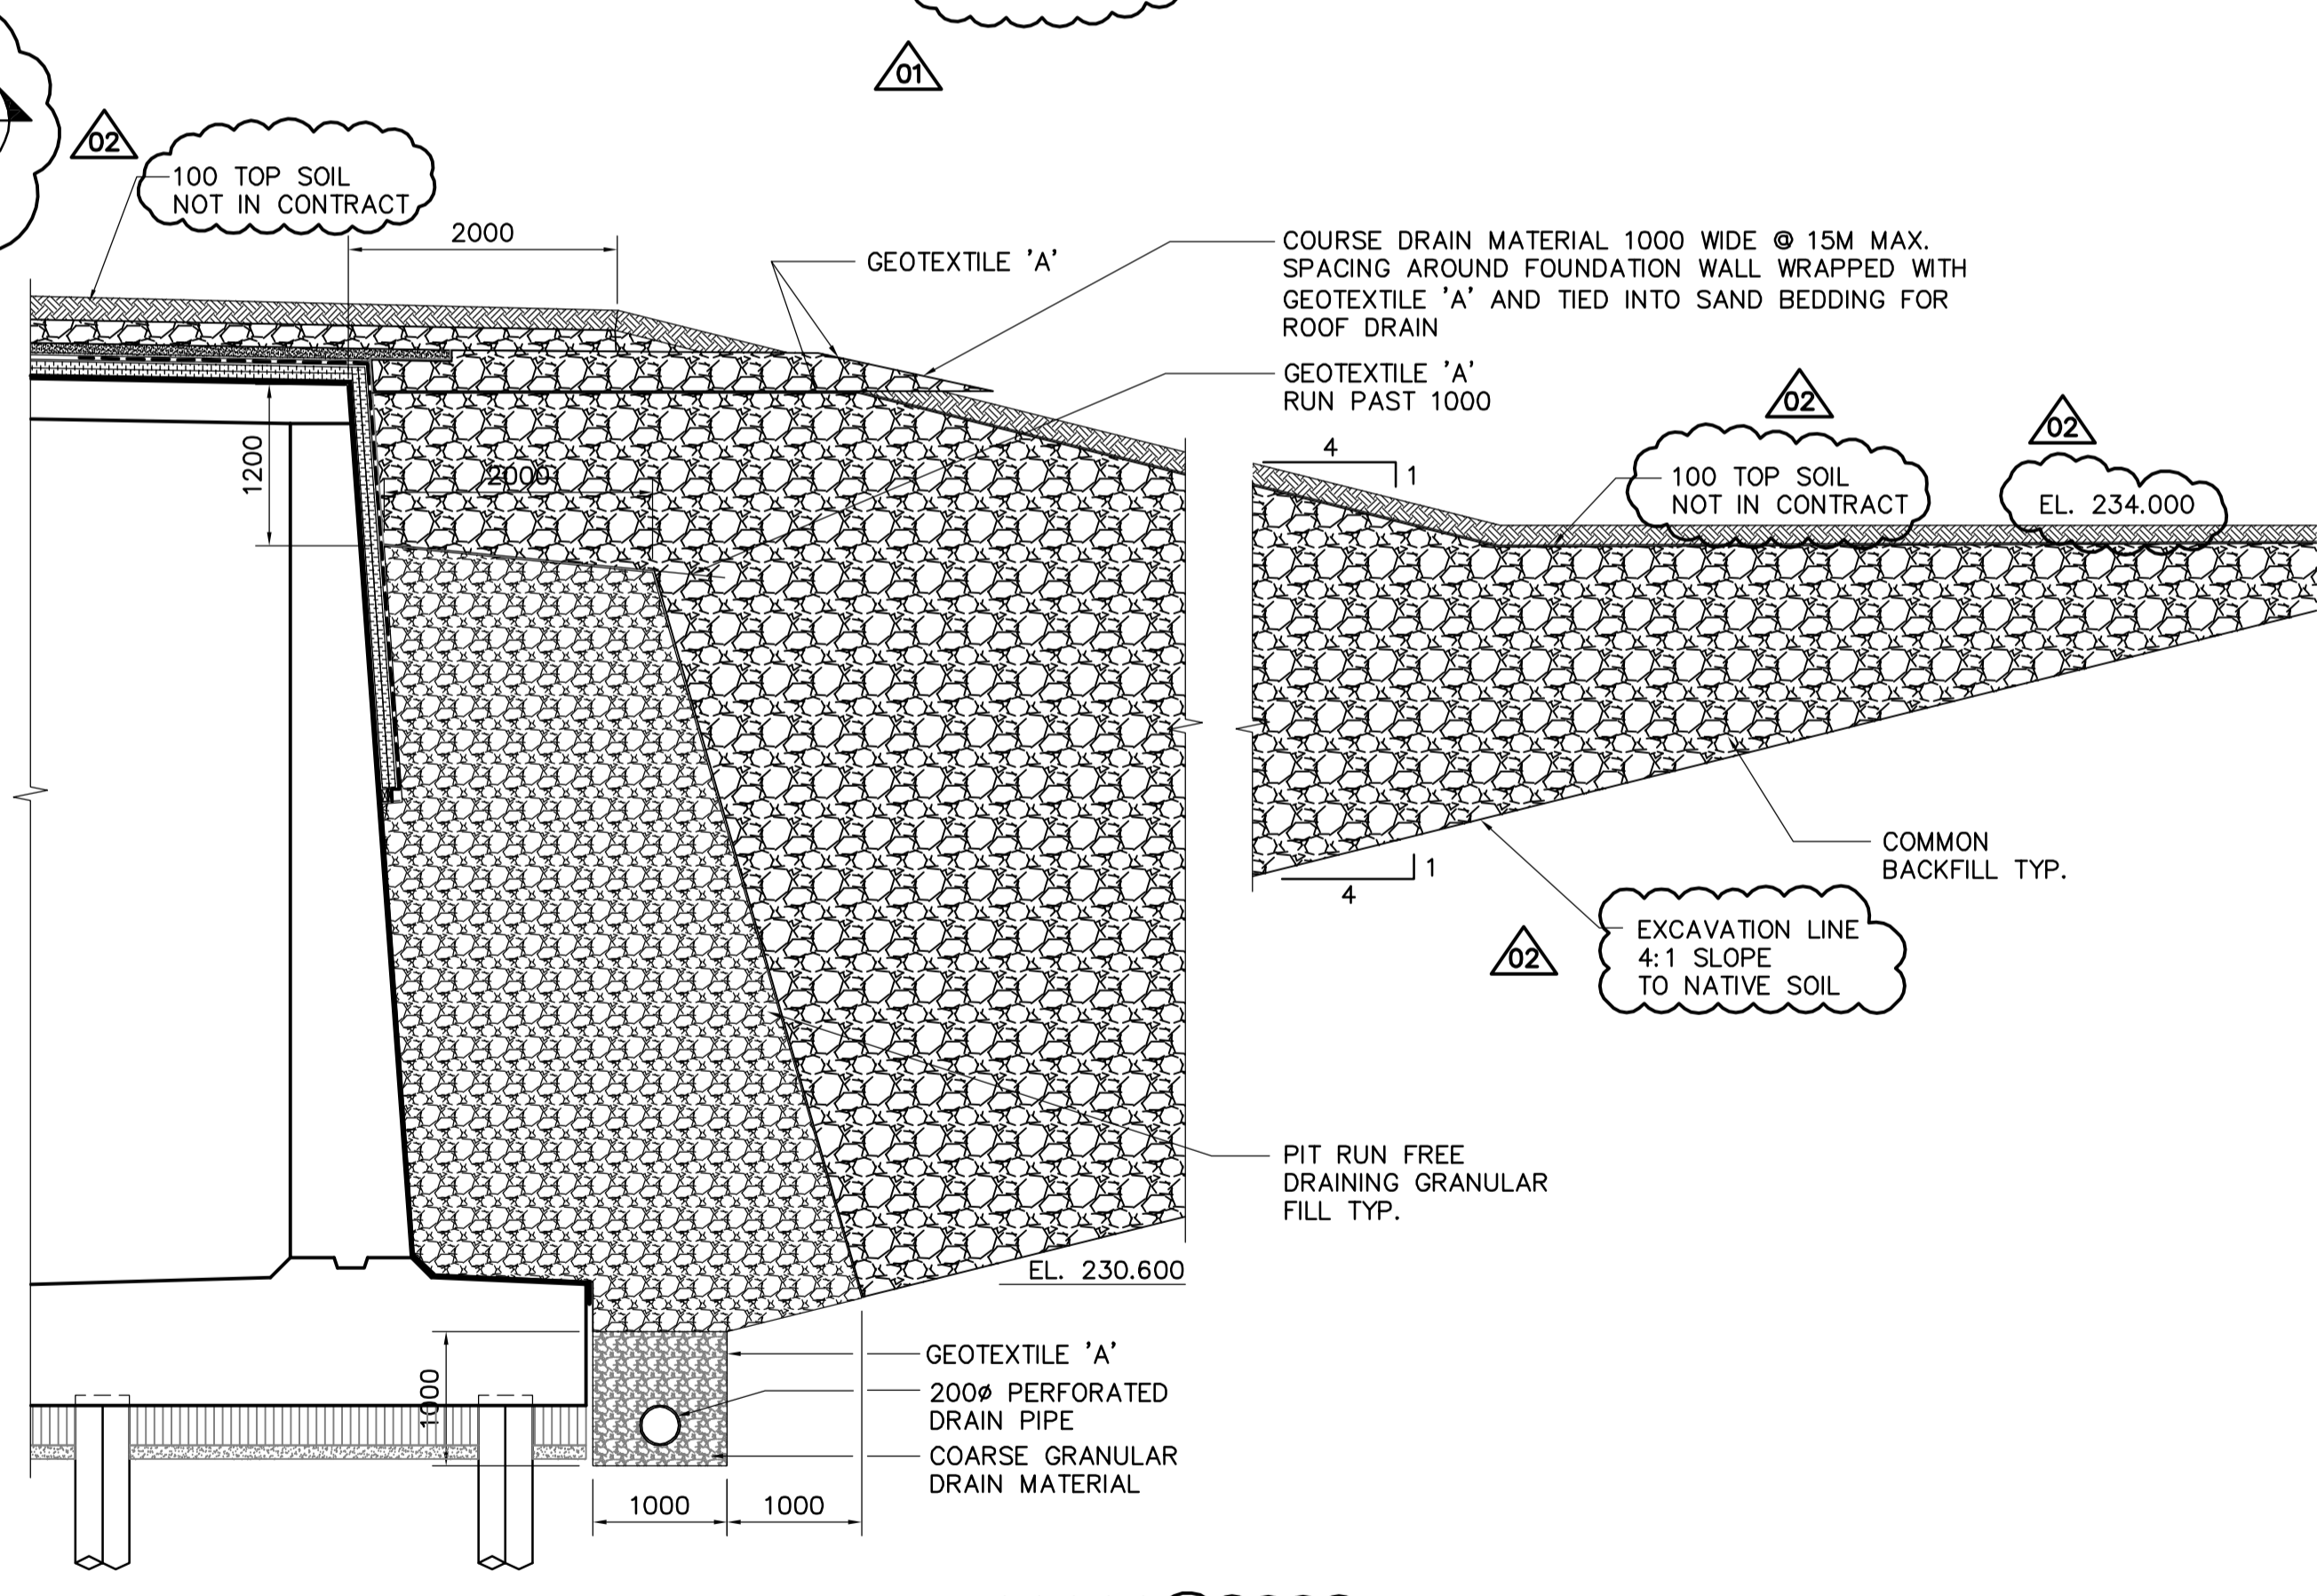

**SECTION 2**  
WT-S038 1:50

**INFORMATION ONLY**

**APEGM**  
Certificate of Authorization  
Earth Tech Canada Inc.  
No. 730 Expiry: April 30, 2006

NO.	REVISIONS	DATE	BY
03	ISSUED FOR CONSTRUCTION	05/06/08	C.T.
02	166-2005 ADDENDUM 2	05/05/12	C.T.
01	166-2005 ADDENDUM 1	05/05/06	C.T.
00	ISSUED FOR TENDER	05/04/17	C.T.

**CH2MHILL**  
Frederickson Cooper  
ARCHITECTS

DESIGNED BY: FK  
CHECKED BY: MK  
DRAWN BY: C.T. / WDB  
APPROVED BY: AHL

HOR. SCALE: AS NOTED  
VERTICAL SCALE: R. SOROKOWSKI

DATE: 2005/03/09  
DATE: 2005-04-17

ENGINEER'S SEAL  
ORIGINAL SIGNED BY: F.A. KEMP  
2005/04/17  
CONSULTANT DRAWING NO. WT-S038

**THE CITY OF WINNIPEG**  
WATER AND WASTE DEPARTMENT  
ENGINEERING DIVISION

**WATER TREATMENT PLANT CLEARWELL CONSTRUCTION**

STRUCTURAL ROOF DRAINAGE PLAN  
DETAIL SECTION OF MANHOLE

CITY FILE NUMBER  
SHEET OF  
CITY DRAWING NUMBER  
1-060T-A-S0038-001-03D