


NOTES:

DO NOT IMPART EXCESSIVE LOADING ON CLARIFIER WALLS AND UNDERGROUND STRUCTURES. PROVIDE CRANE PAD LOCATIONS AND DESIGN CALCULATIONS TO CONTRACT ADMINISTRATOR FOR REVIEW.

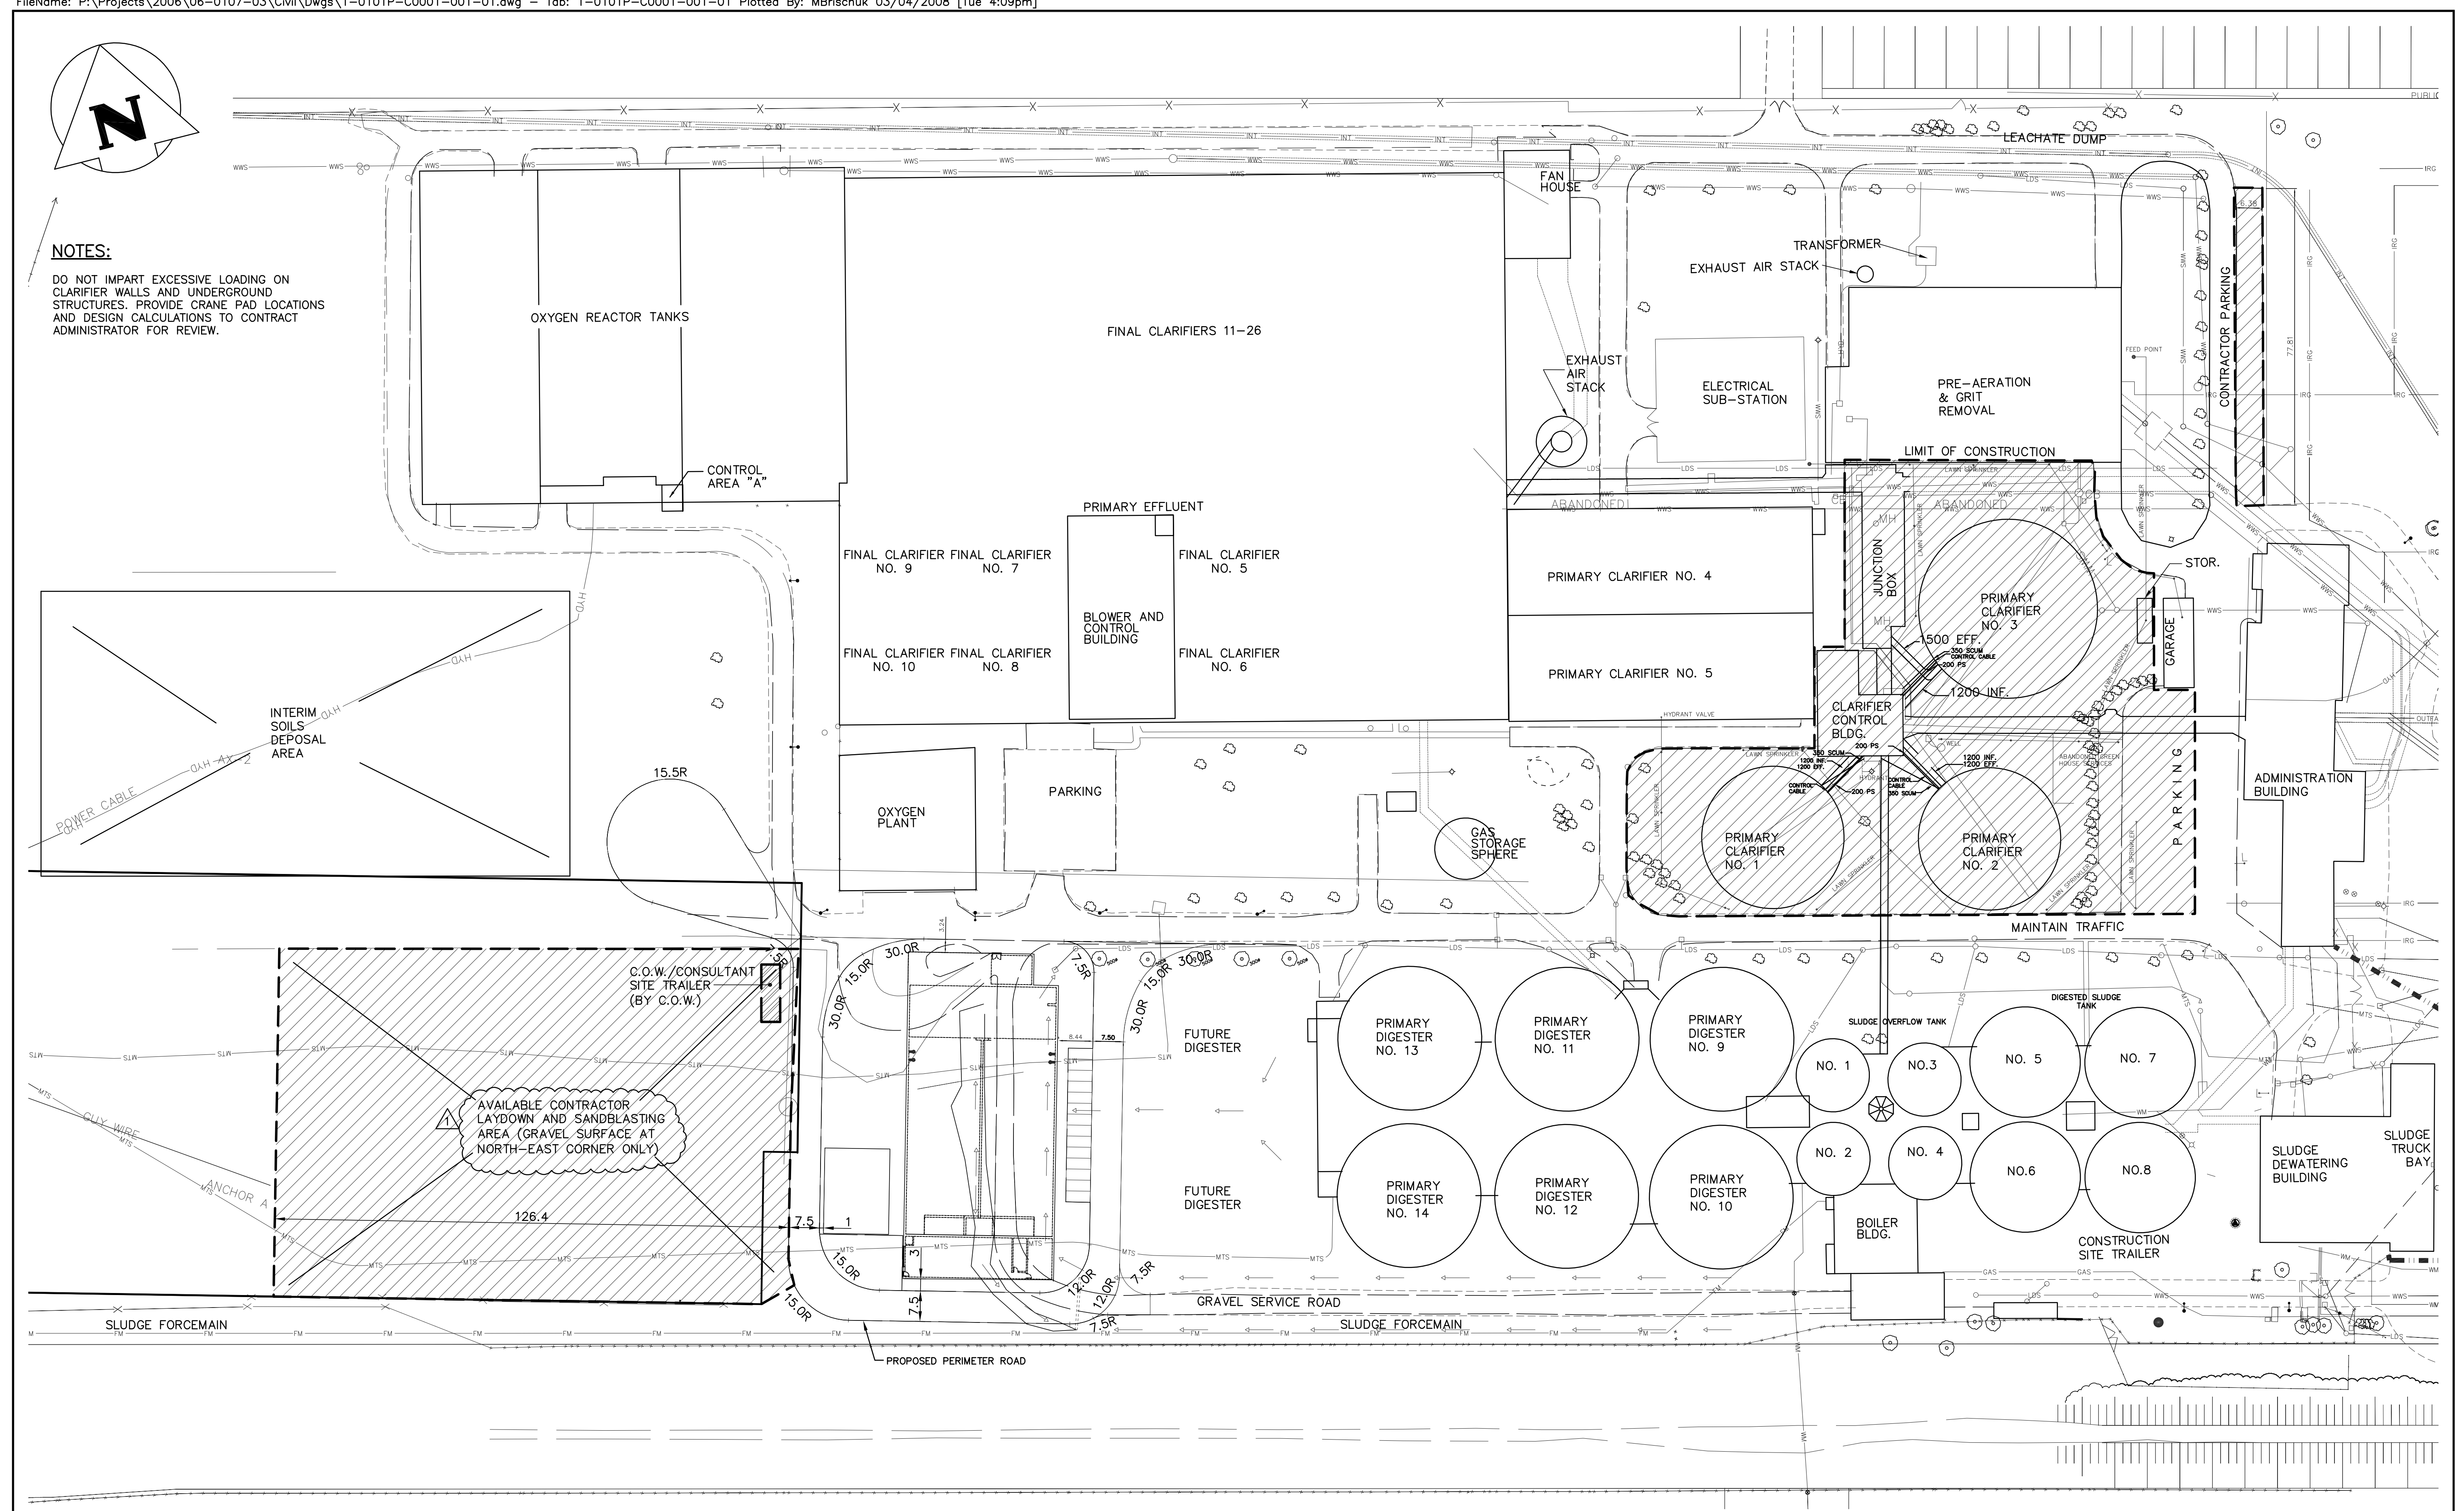

COMPLEGEND

APEGM
 Certificate of Authorization
 KGS Group
 No. 245 Date: _____

B.M. ELEV.			
DESIGNED BY	RJL	CHECKED BY	RJL
DRAWN BY	MB	APPROVED BY	
HOR. SCALE:	1:750	RELEASED FOR CONSTRUCTION:	
VERTICAL:		DATE	-/12/07
NO.	REVISIONS	DATE	BY

KGS GROUP
 CONSULTING ENGINEERS & PROJECT MANAGERS

CH2MHILL

ENGINEER'S SEAL

 R.J. LONG
 CONSULTANT DRAWING NO.
 1-0101P-C0001-001

THE CITY OF WINNIPEG
 WATER AND WASTE DEPARTMENT

PROJECT TITLE
 NORTH END WATER POLLUTION CONTROL CENTRE
 PARTIAL SITE PLAN

SHEET OF
 01 01

KGS JOB NUMBER
 06-0107-03

CITY DRAWING NUMBER
 1-0101P-C0001-001