


NOTES:

DO NOT IMPART EXCESSIVE LOADING ON CLARIFIER WALLS AND UNDERGROUND STRUCTURES. PROVIDE CRANE PAD LOCATIONS AND DESIGN CALCULATIONS TO CONTRACT ADMINISTRATOR FOR REVIEW.




COWLEGGEND

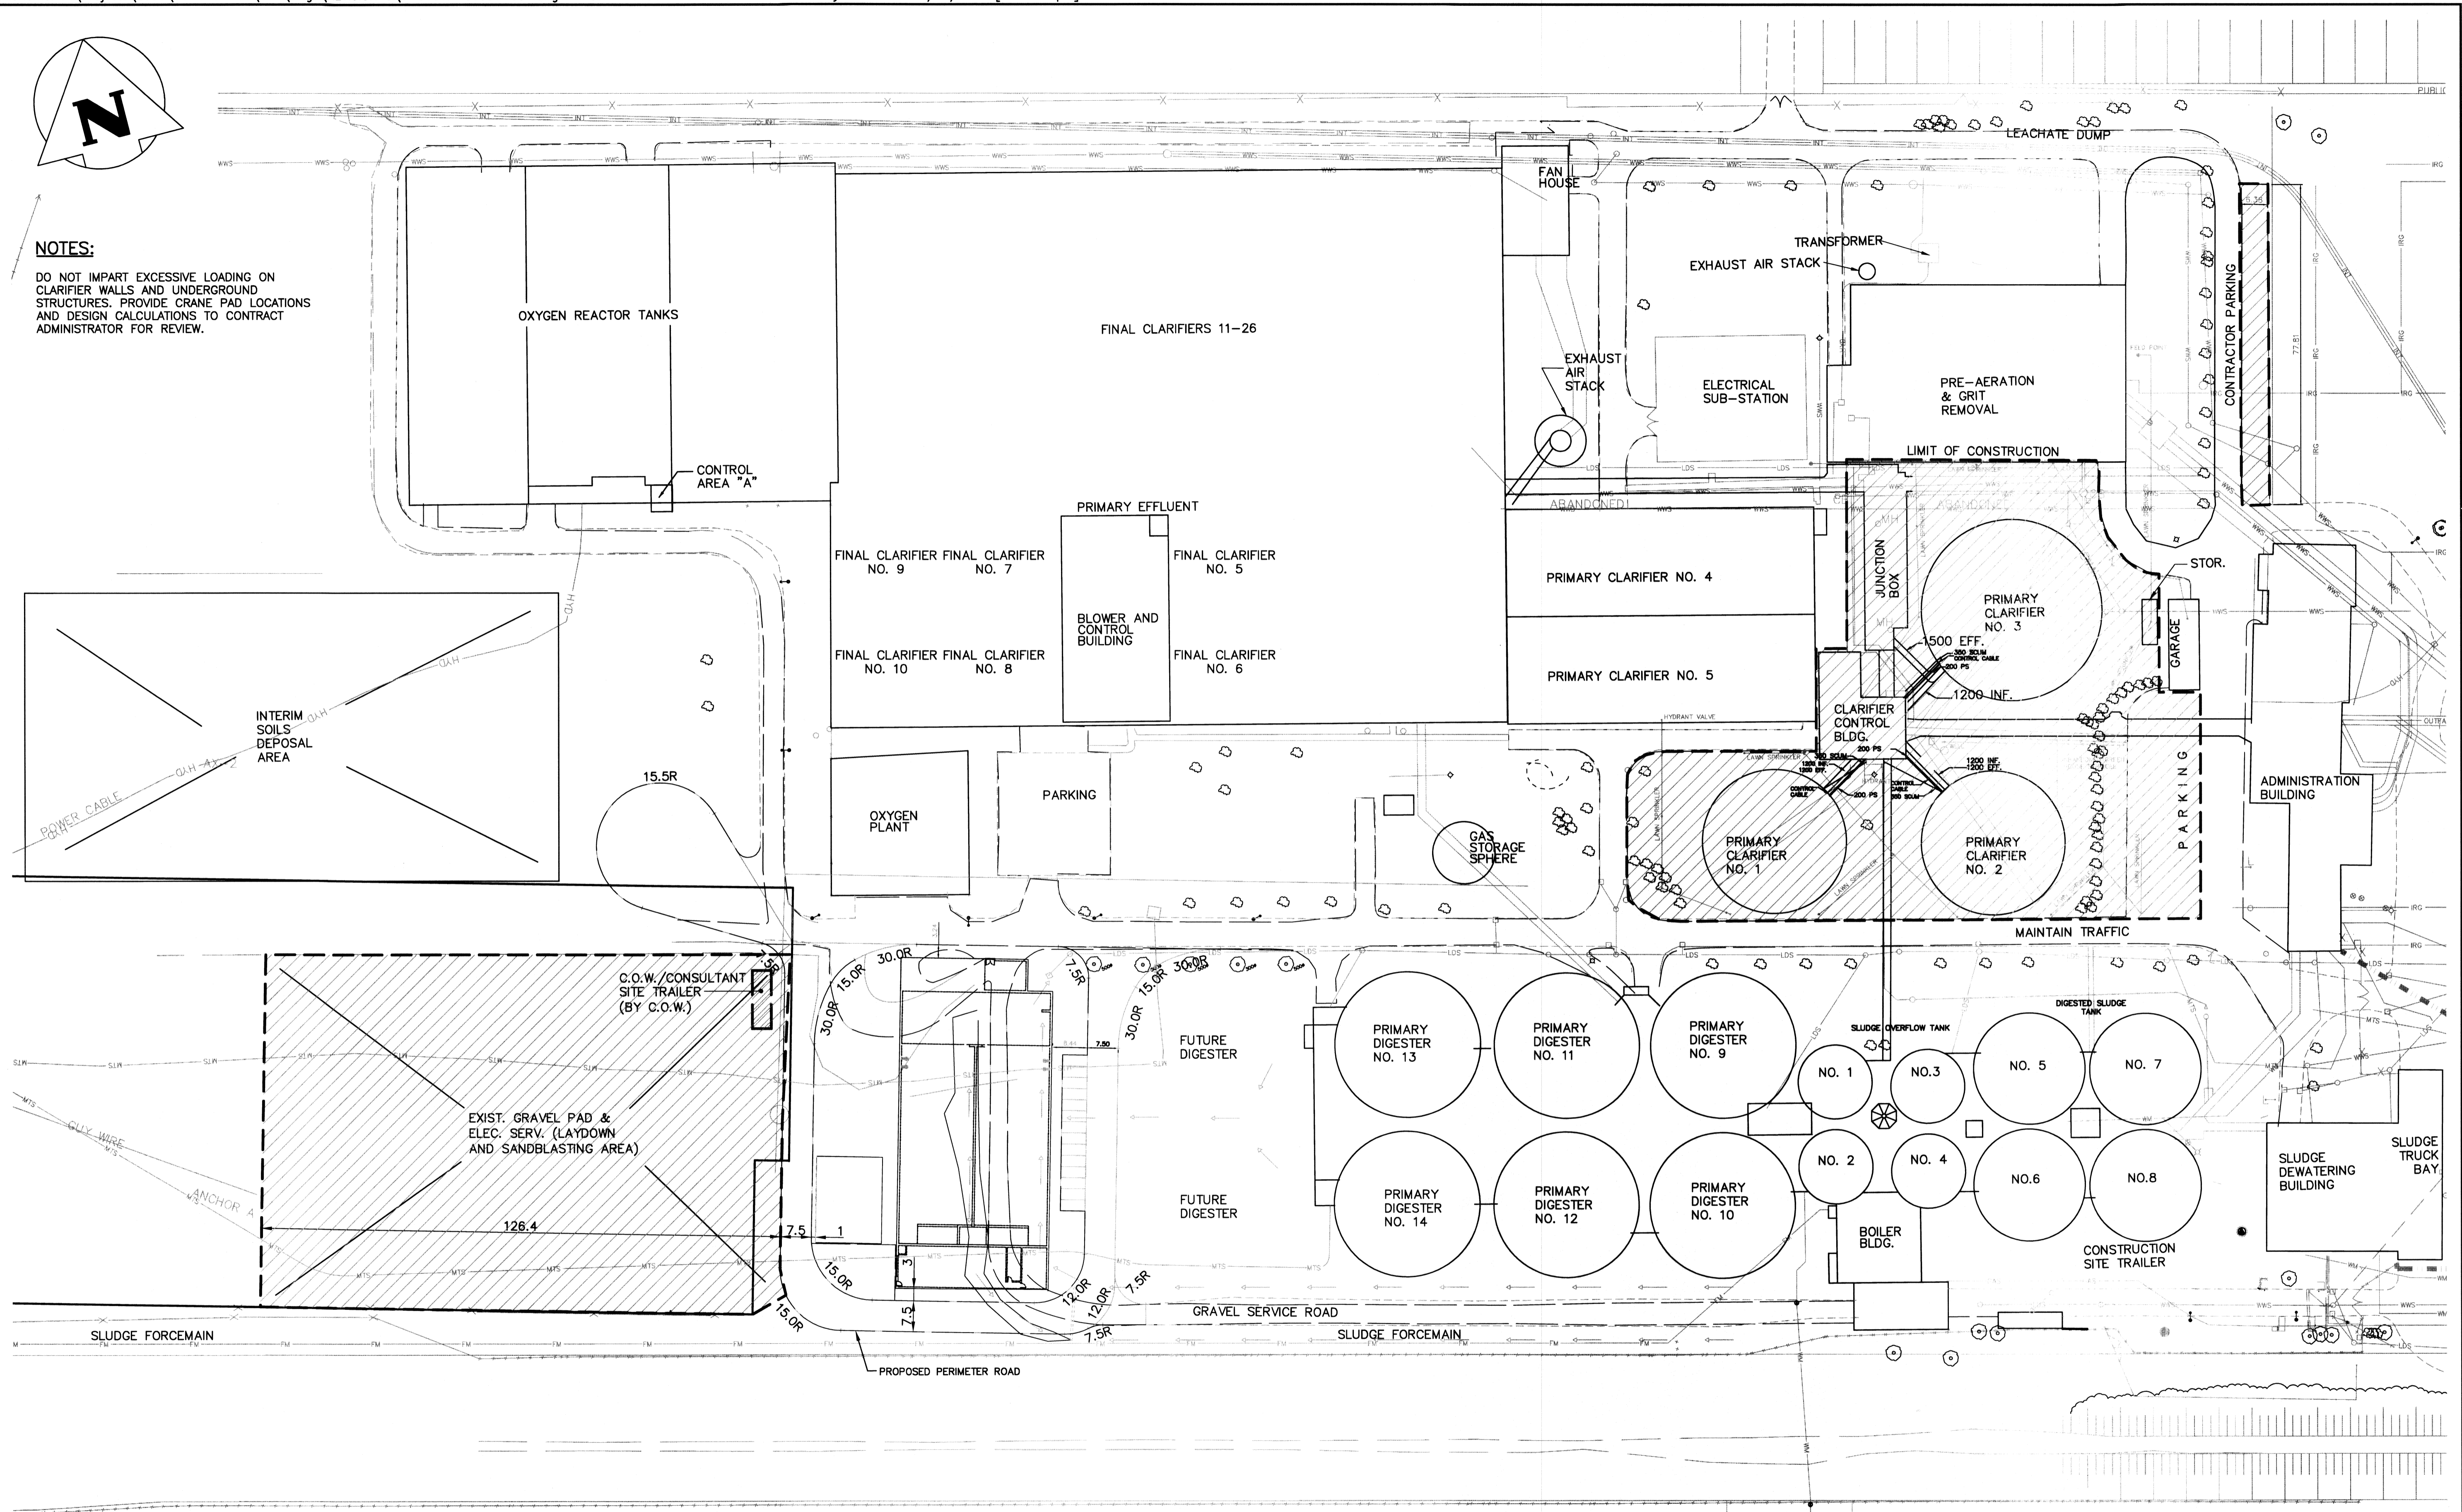

B.M. ELEV.			
DESIGNED BY	RJL	CHECKED BY	RJC
DRAWN BY	MB	APPROVED BY	
HOR. SCALE:	1:750	RELEASED FOR CONSTRUCTION:	
VERTICAL:		DATE	-/12/07
ISSUED FOR TENDER	13/02/08	DATE	
NO. REVISIONS	DATE	BY	



ENGINEER'S SEAL

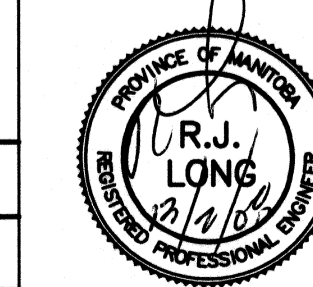

CONSULTANT DRAWING NO. 1-0101P-C0001-001



THE CITY OF WINNIPEG
WATER AND WASTE DEPARTMENT

PROJECT TITLE
NORTH END WATER POLLUTION CONTROL CENTRE
PARTIAL SITE PLAN

SHEET	OF
01	01
KGS JOB NUMBER	06-0107-03
CITY DRAWING NUMBER	1-0101P-C0001-001