



 

ELECTRICAL ROOM

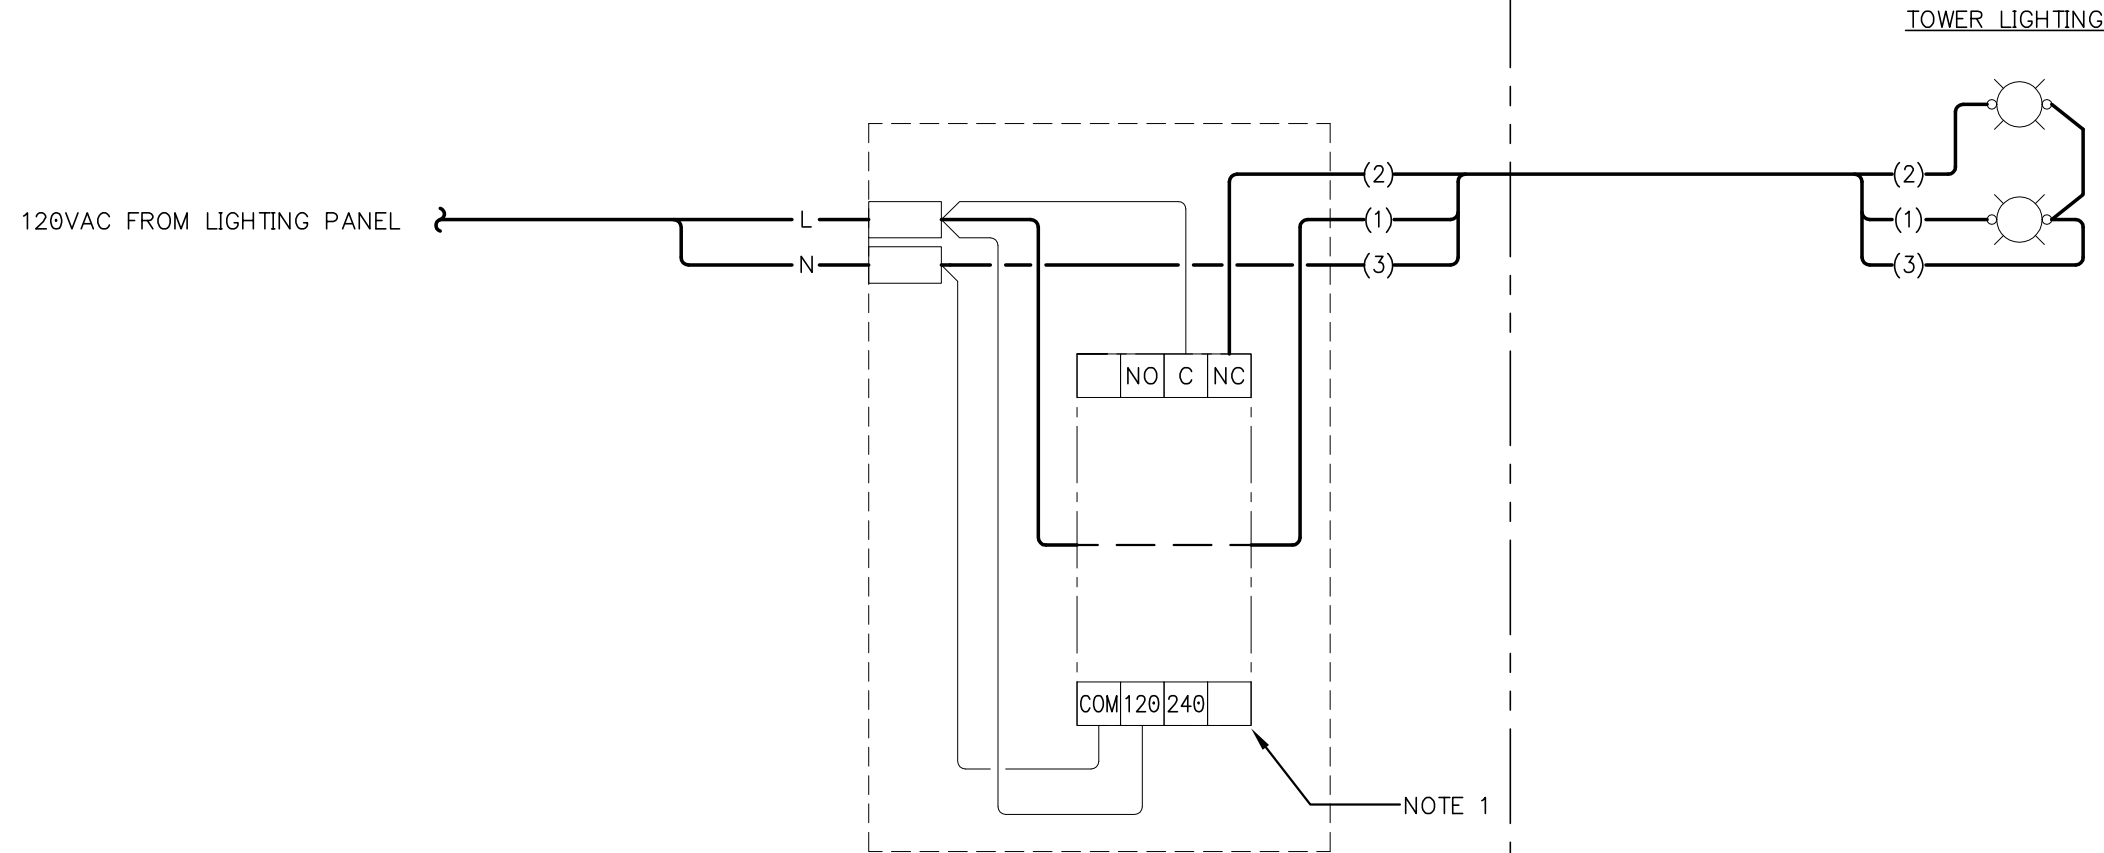
FIELD

NOTES:

1. ADJUSTABLE CURRENT SENSING RELAY. INSTALLED IN ENCLOSURE.

LEGEND

-  FIELD WIRING
-  PANEL WIRING
-  TOWER LIGHT
-  TERMINAL



B.M. ELEV.	FIELD BOOK #:
POSTED TO LBIS	
DESIGNED BY	DDW
DRAWN BY	GCN
HOR. SCALE	N.T.S.
VERTICAL	.
01 ISSUED FOR TENDER	15/02/08 REW
NO. REVISIONS	DATE BY

KGS GROUP
CONSULTING ENGINEERS & PROJECT MANAGERS

CH2MHILL

DESIGNED BY: DDW
CHECKED BY: REW


DRAWN BY: GCN
APPROVED BY: .

HOR. SCALE: N.T.S.
VERTICAL: .

RELEASED FOR CONSTRUCTION

DATE: 12/02/08

ENGINEER'S SEAL



TENDER No: 25-2008
FILENAME: 1-0101P-E0041-001
PLOT DATE: 15/02/08

THE CITY OF WINNIPEG
WATER AND WASTE DEPARTMENT

NORTH END WATER POLLUTION CONTROL CENTRE
CONTROL SCHEMATIC
TOWER LIGHTING

SHEET 001 OF 001
CITY DRAWING NUMBER
1-0101P-E0041-001