


SYMBOL QUANT. DESCRIPTION

A_	9	SPRINKLER RISER - GRINNELL 6" MODEL A
B_	3	SPRINKLER RISER - GRINNELL 8" MODEL A
C_	2	SPRINKLER RISER - RELIABLE 6" MODEL E
D_	3	FLOW SWITCH - PADDLE TYPE
E_	3	GLYCAL SRPINKLER SYSTEM
F_	2	FIRE HOSE
G_	10	WATER GONG
H_	4	WALL HYDRANT - McAVITY
J_	3	UNDERGROUND VALVE PIT

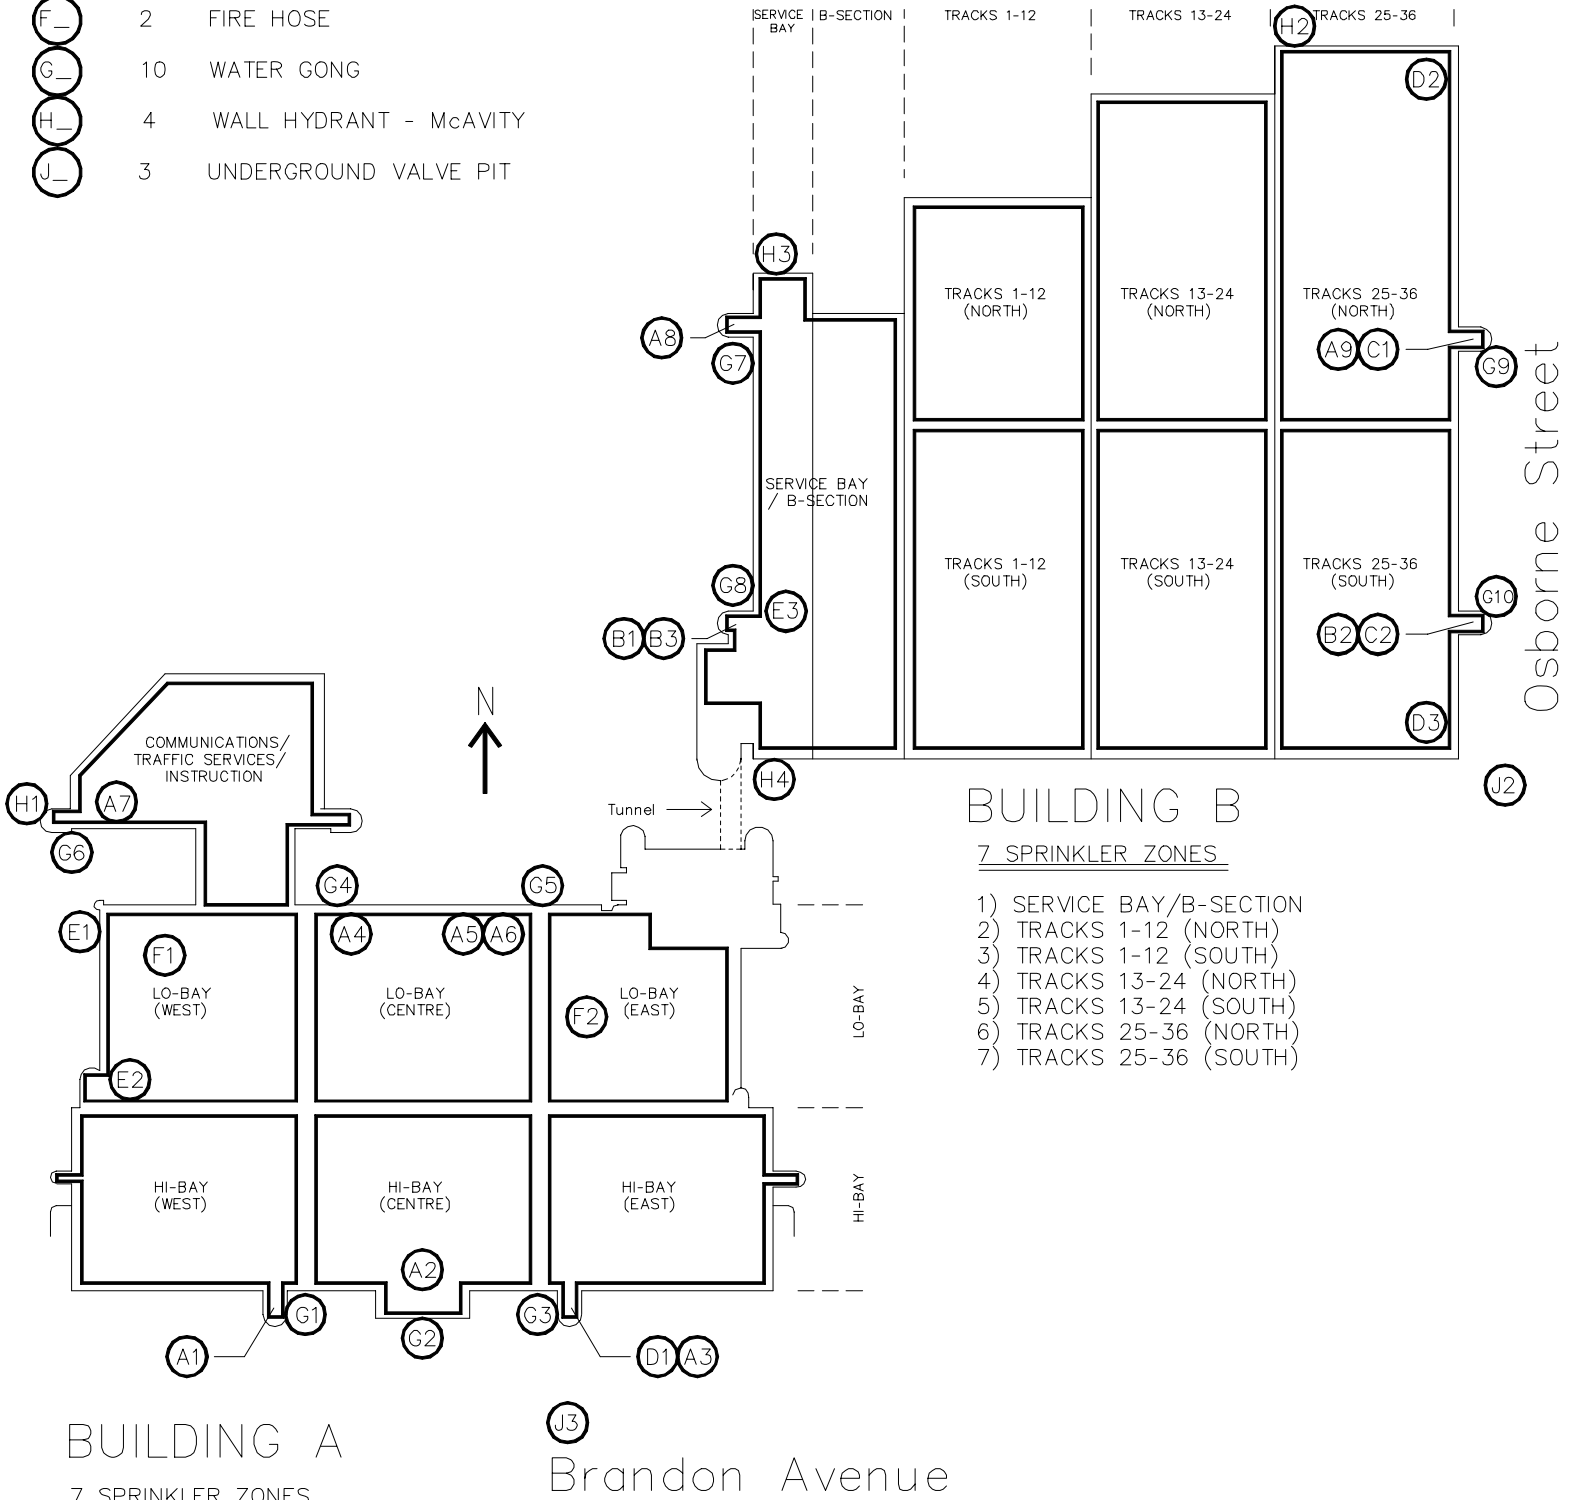

FORT ROUGE GARAGE SPRINKLER SYSTEM - BUILDINGS A & B - ZONES AND EQUIPMENT LOCATIONS	REVISION 0
	REF NO FRG_209
	DRAWING NO. FRG SPR 01