


SYMBOL QUANT. DESCRIPTION

- (A) 2 SPRINKLER RISER - VIKING 6"
- (B) 2 SPRINKLER RISER - 6" AUTOMATIC ALARM VALVES
- (C) 4 FLOW SWITCH - PADDLE TYPE
- (D) 4 CHECK VALVE, FIRE DEPARTMENT CONNECTIONS AND INCOMING WATER MAIN

BUILDING

4 SPRINKLER ZONES

- 1) NORTHWEST QUADRANT
- 2) NORTHEAST QUADRANT
- 3) SOUTHWEST QUADRANT
- 4) SOUTHEAST QUADRANT

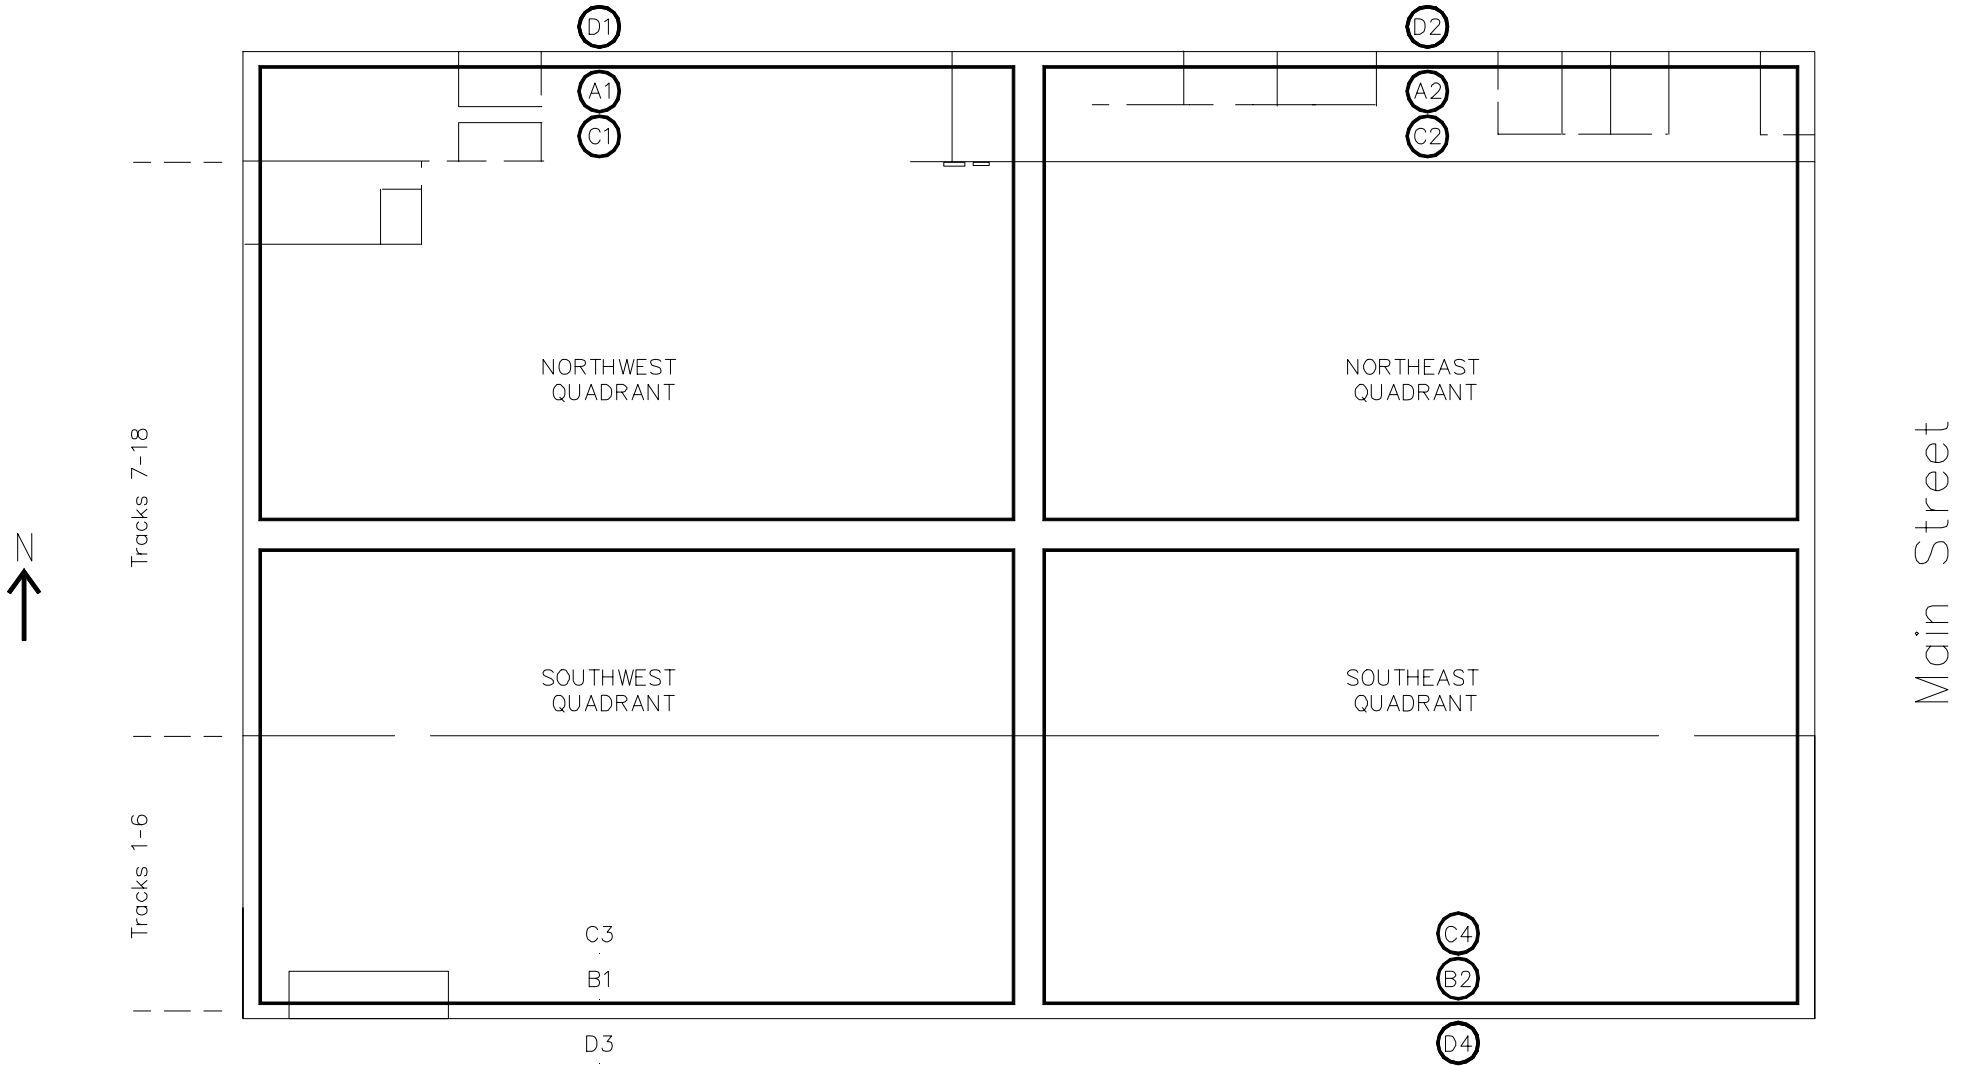

CURRUTHERS GARAGE
 SPRINKLER SYSTEM -
 BUILDING -
 ZONES AND EQUIPMENT
 LOCATIONS

REVISION 0
 REF NO NG-029
 DRAWING NO.
 NG SPR 01

Carruthers Avenue