



D SIZE 24" x 36" (609.6mm x 914.4mm)

PLOT: 21/04/2008 10:50:03 AM

UMA FILE NAME: 0265-405-00_01-M-0002_RX.dwg Saved By: rschween

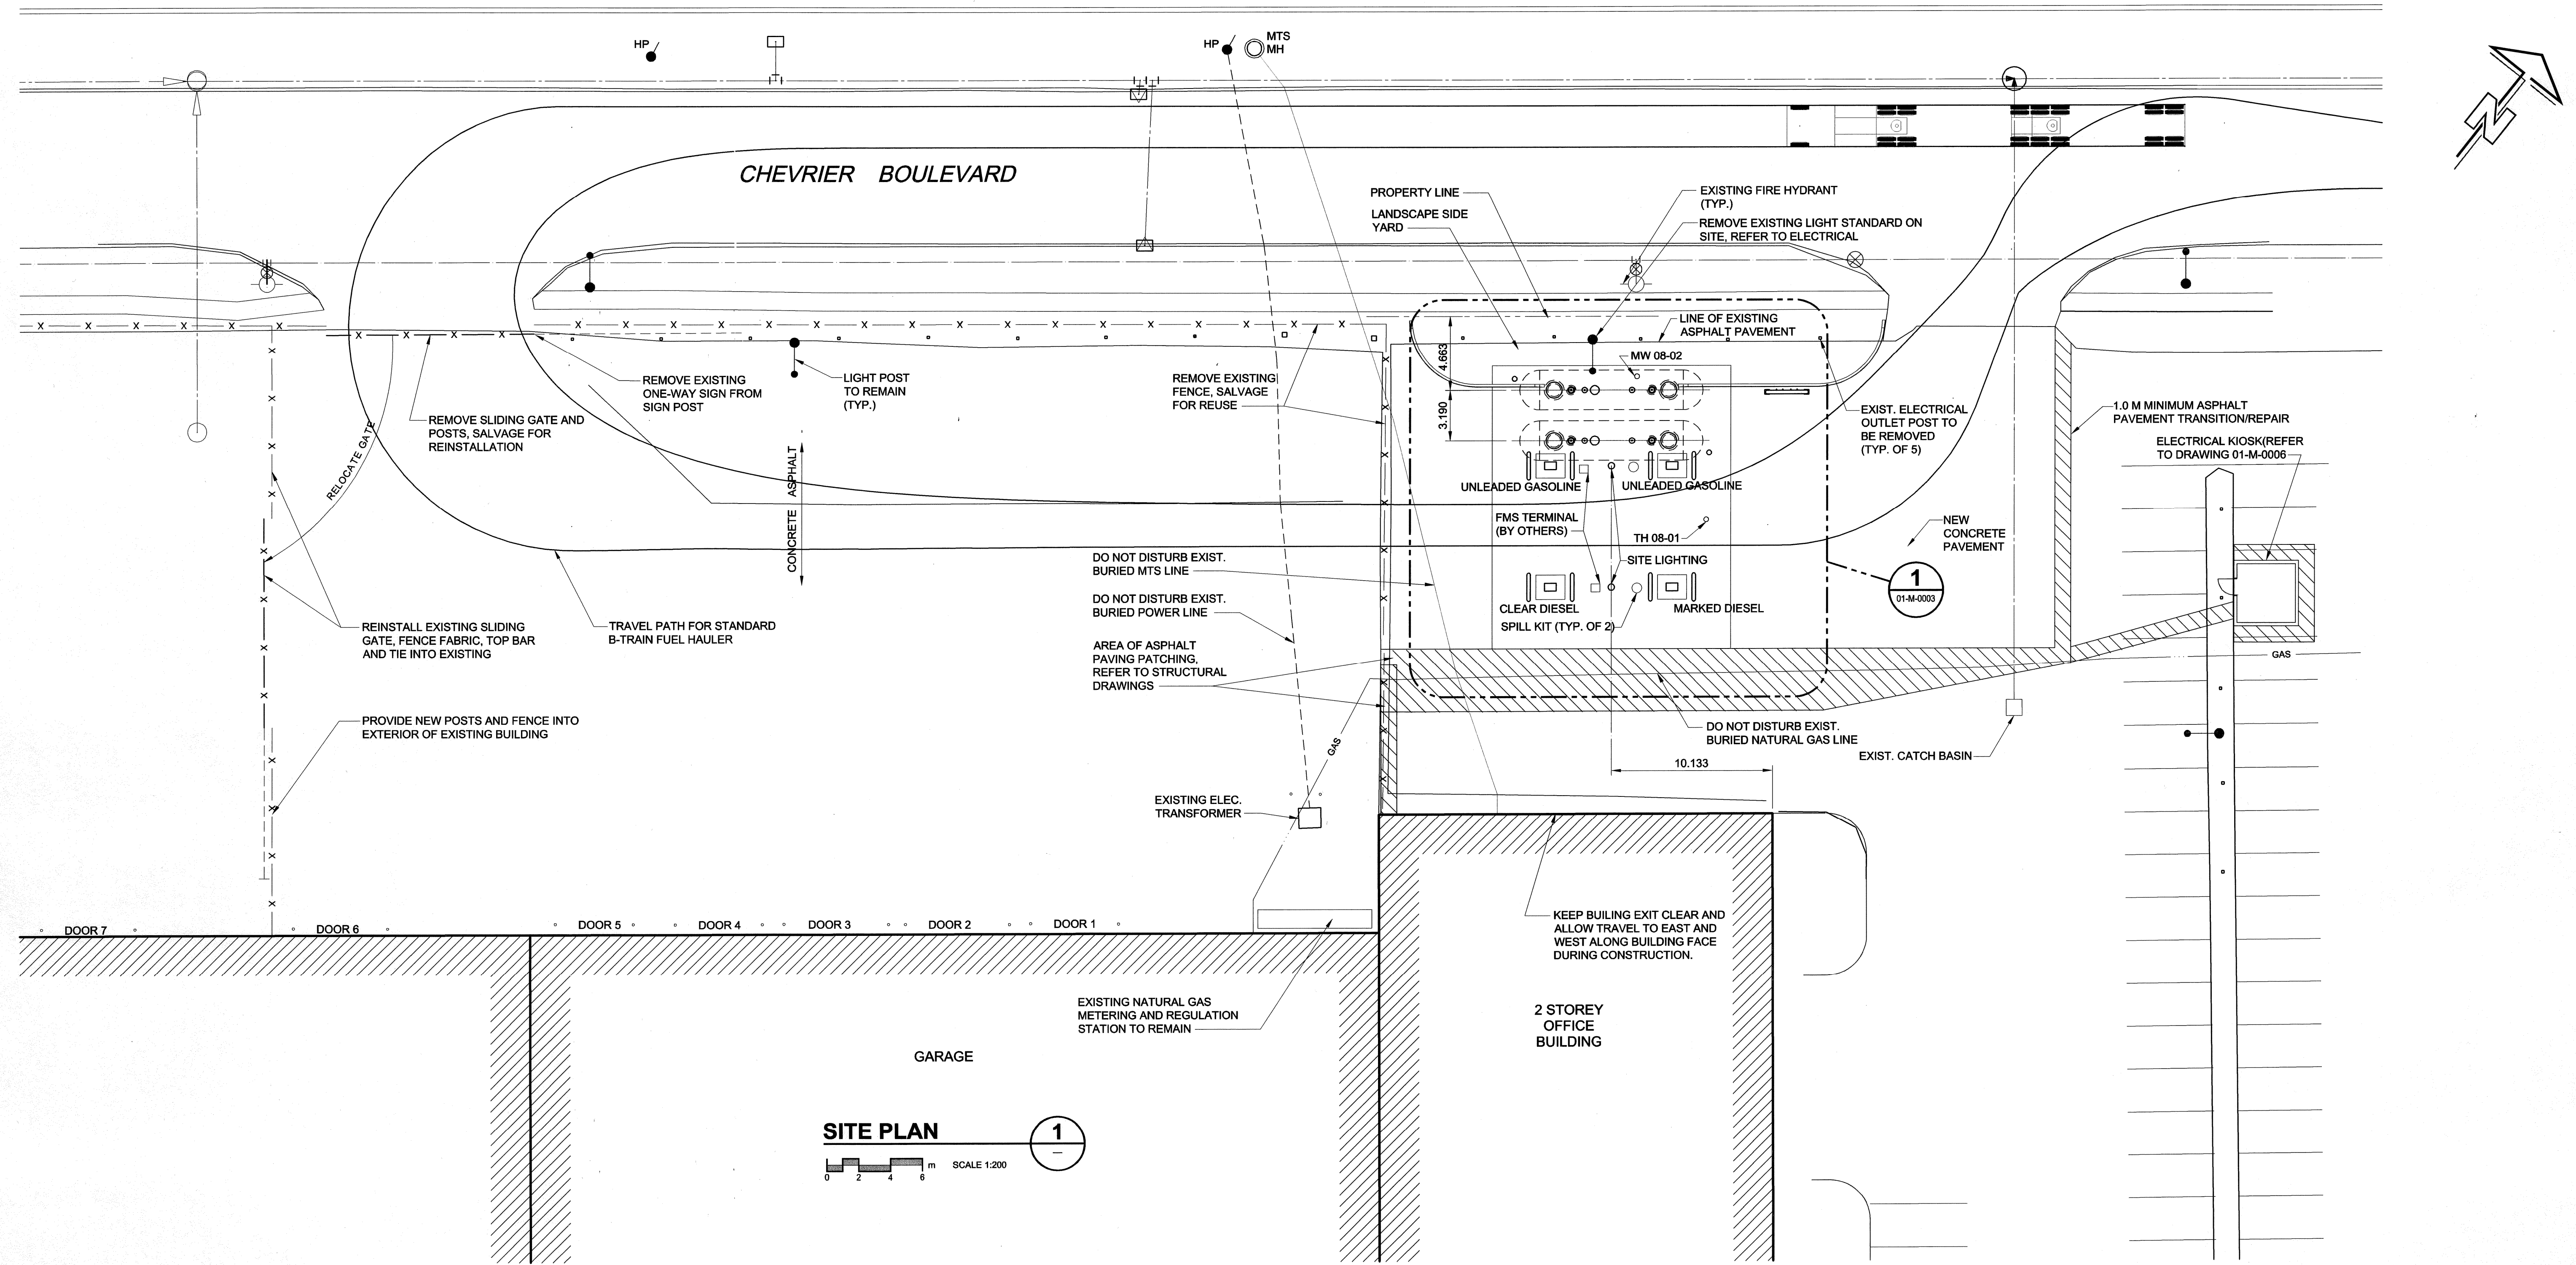

SITE PLAN
 0 2 4 6 m SCALE 1:200

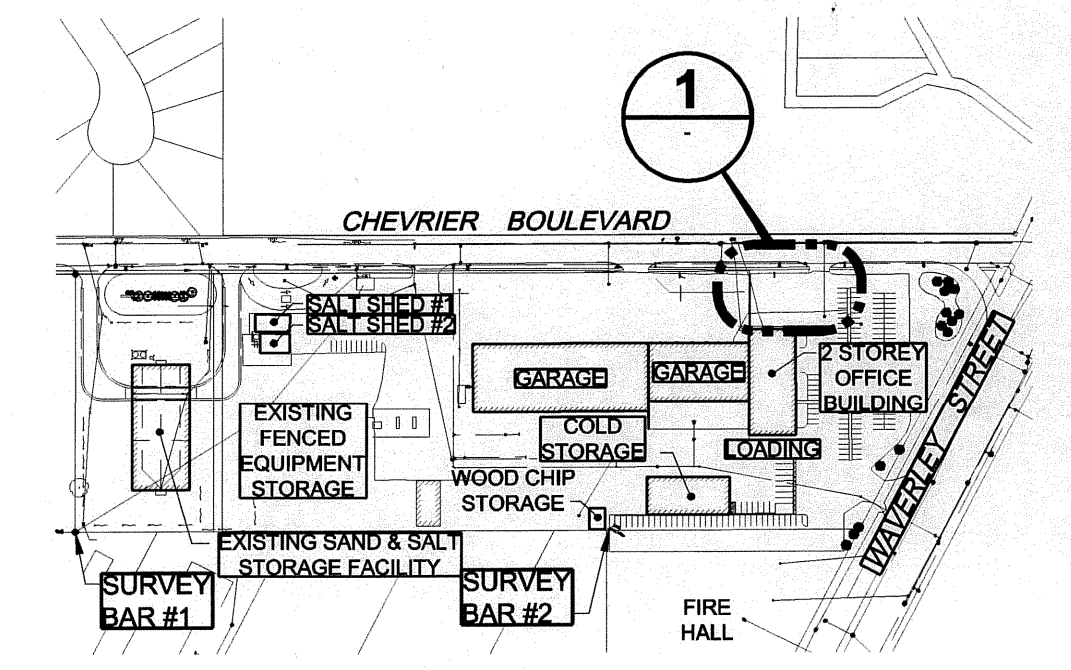

KEY PLAN
 SCALE: N.T.S.

DO NOT SCALE THIS DOCUMENT.
 ALL MEASUREMENTS MUST BE OBTAINED FROM STATED DIMENSIONS.

© 2008 UMA ENGINEERING LTD. ALL RIGHTS RESERVED.
 THIS DOCUMENT IS PROTECTED BY COPYRIGHT LAW AND MAY NOT BE REPRODUCED
 IN ANY MANNER, OR FOR ANY PURPOSE EXCEPT BY THE WRITTEN PERMISSION OF
 UMA ENGINEERING LTD.

PRELIMINARY
 NOT FOR CONSTRUCTION
 Date: 2008/04/21

PROFESSIONAL SEALS

I/R	YY/MM/DD	ISSUE/REVISION DESCRIPTION	DRN	CHK	DES	ENG	IDR	APP
D	08/04/21	Issued For Bid						
C	08/04/07	Issued For Review	RS	ALS	RBT	CC	BP	-
B	08/03/07	Issued For Review	ALS	RS	RBT	CC	BP	-
A	08/02/20	Issued For Review	RS	ALS	RBT	JS	SS	-

UMA | AECOM

City of Winnipeg
 Construction of a New Fueling Facility
 District 6 Public Works Yard, 1539 Waverley St.
 Site Plan

PROJECT NUMBER	DRAWING NUMBER	ISSUE/REVISION
0265-405-00	01-M-0002	D