
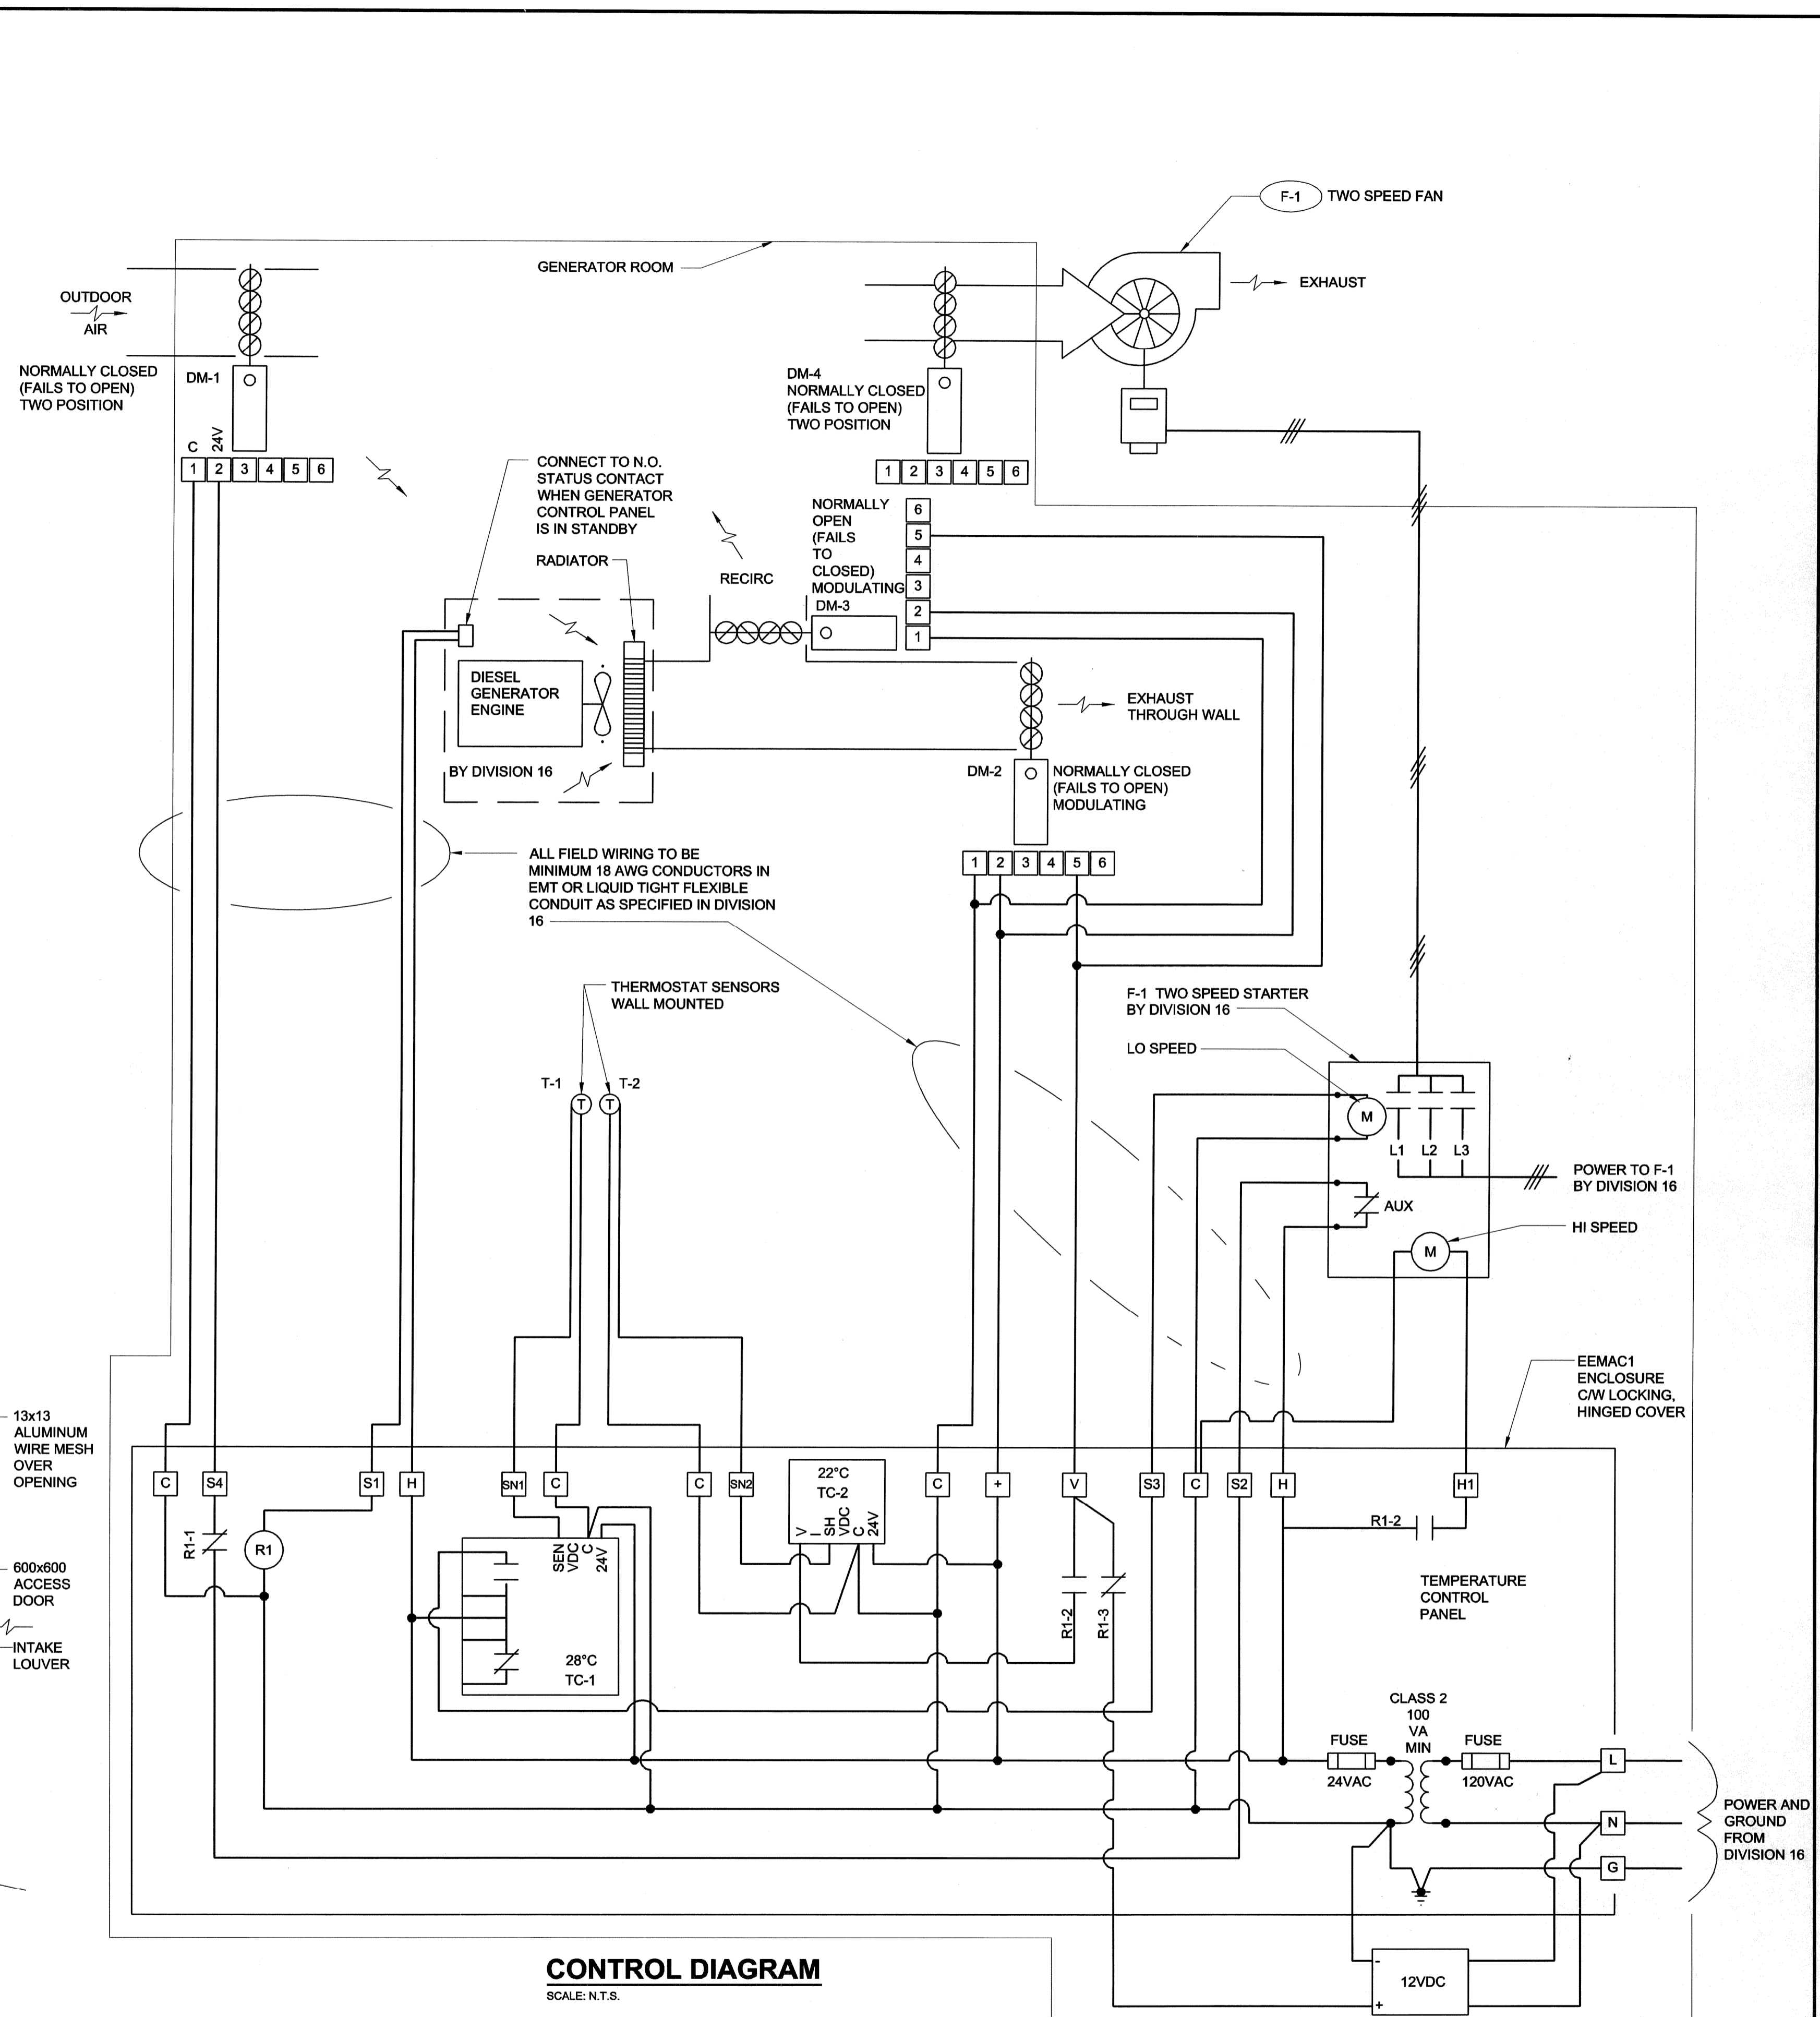
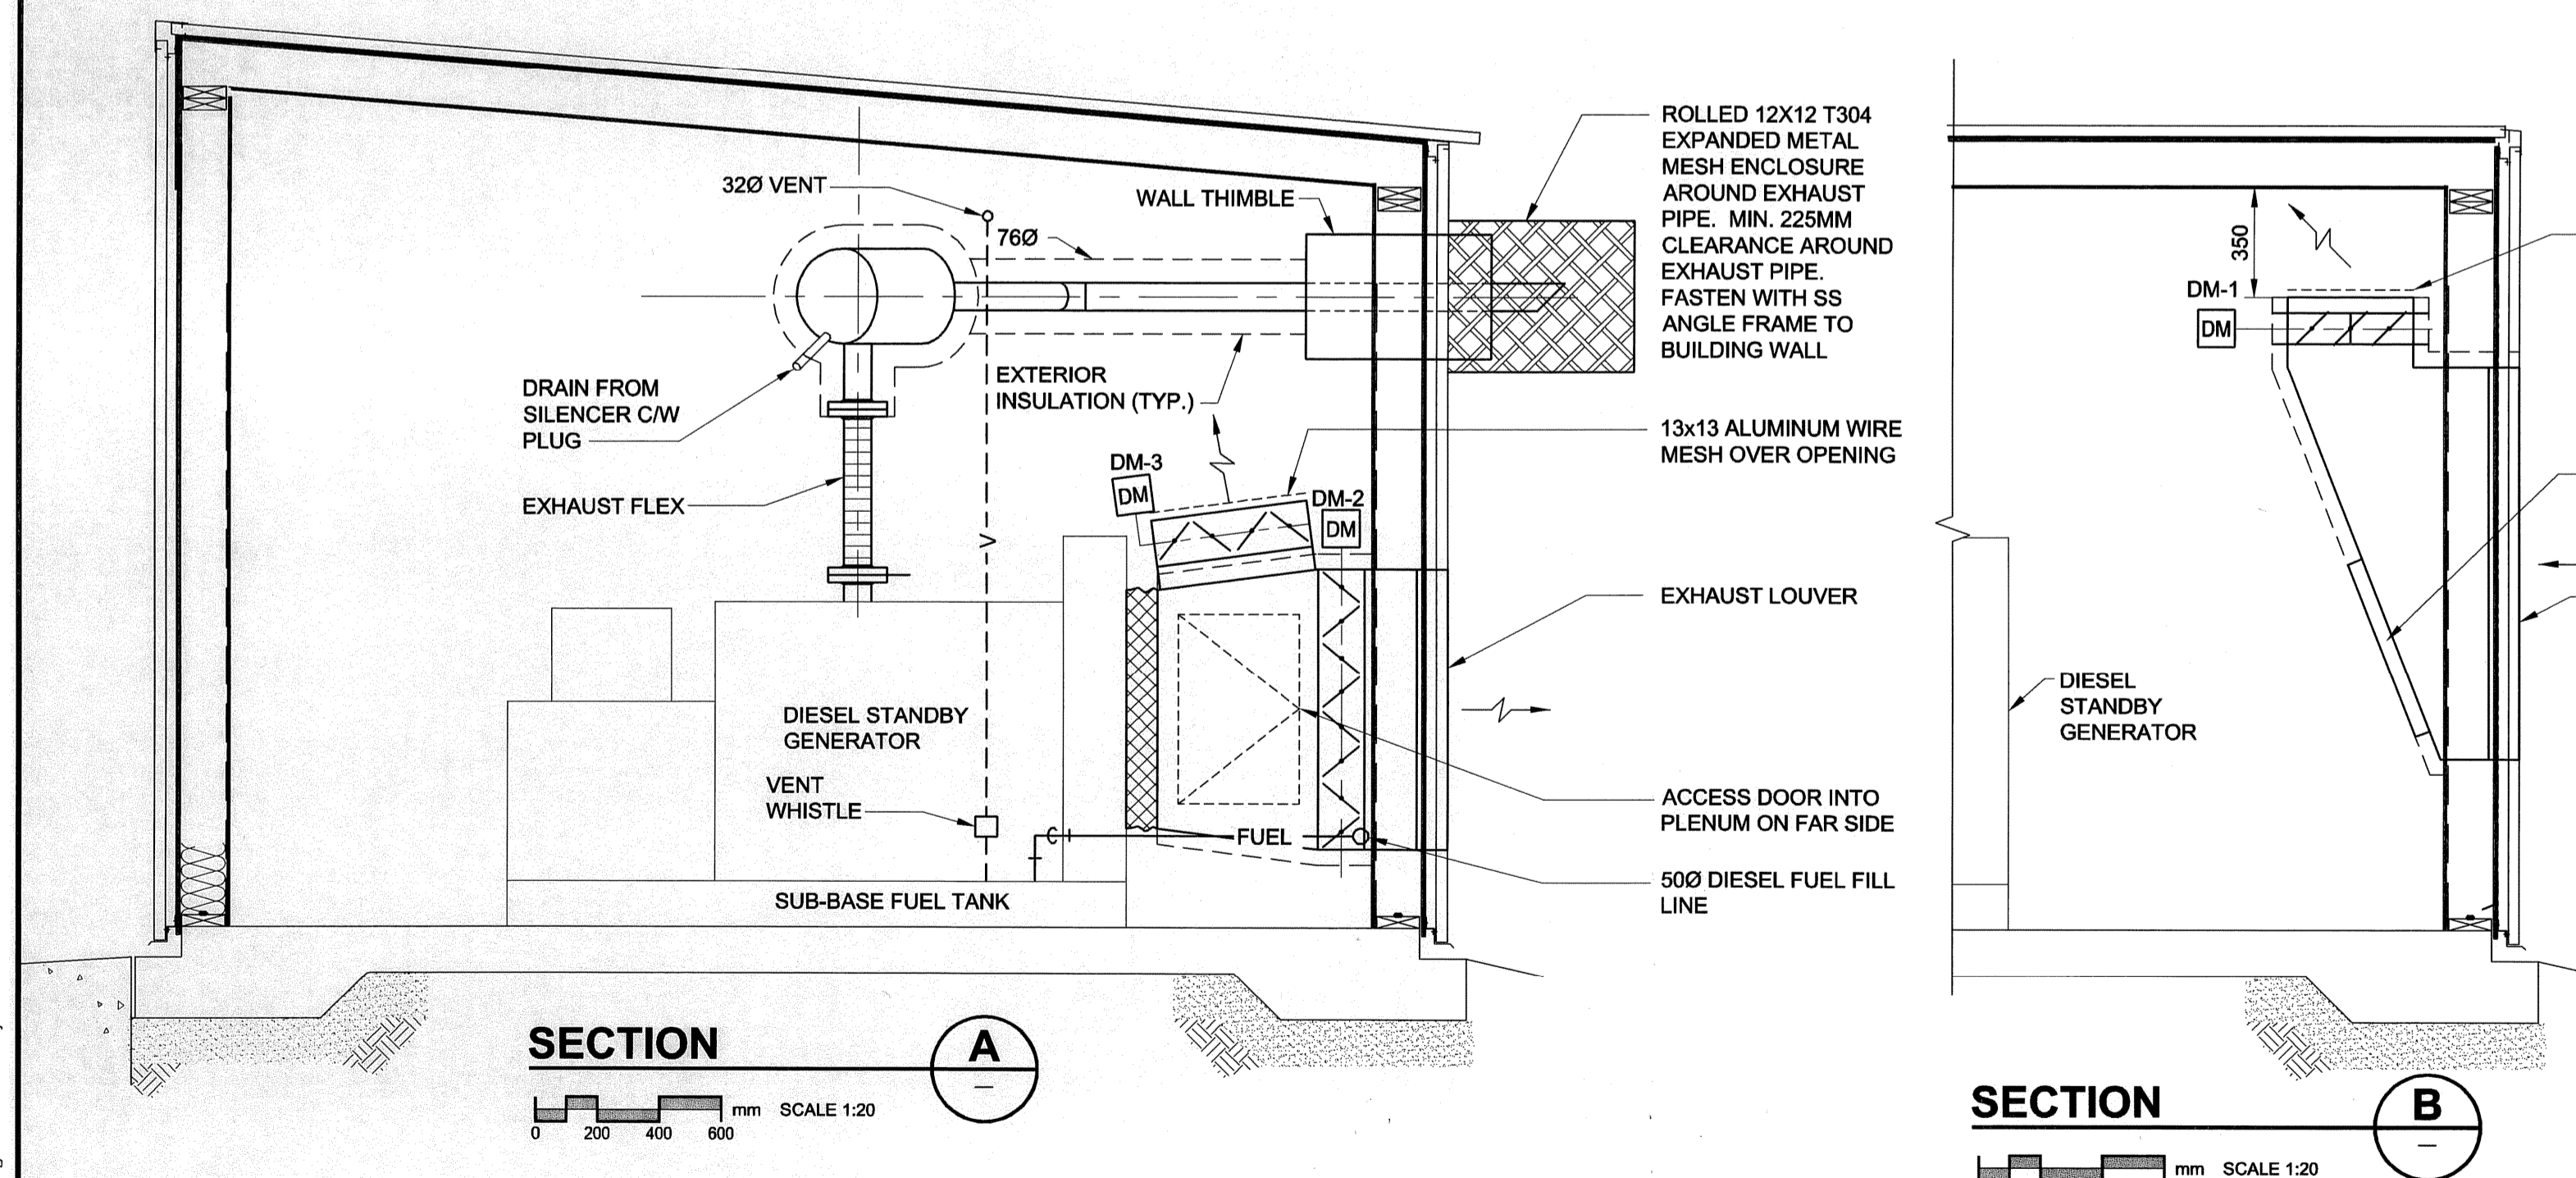


D SIZE 24" x 36" (609.6mm x 914.4mm)
 PLOT: 21/04/2008 10:51:59 AM
 Saved By: rschween
 UMA FILE NAME: 0265-405-00_01-M-0006_RX.dwg

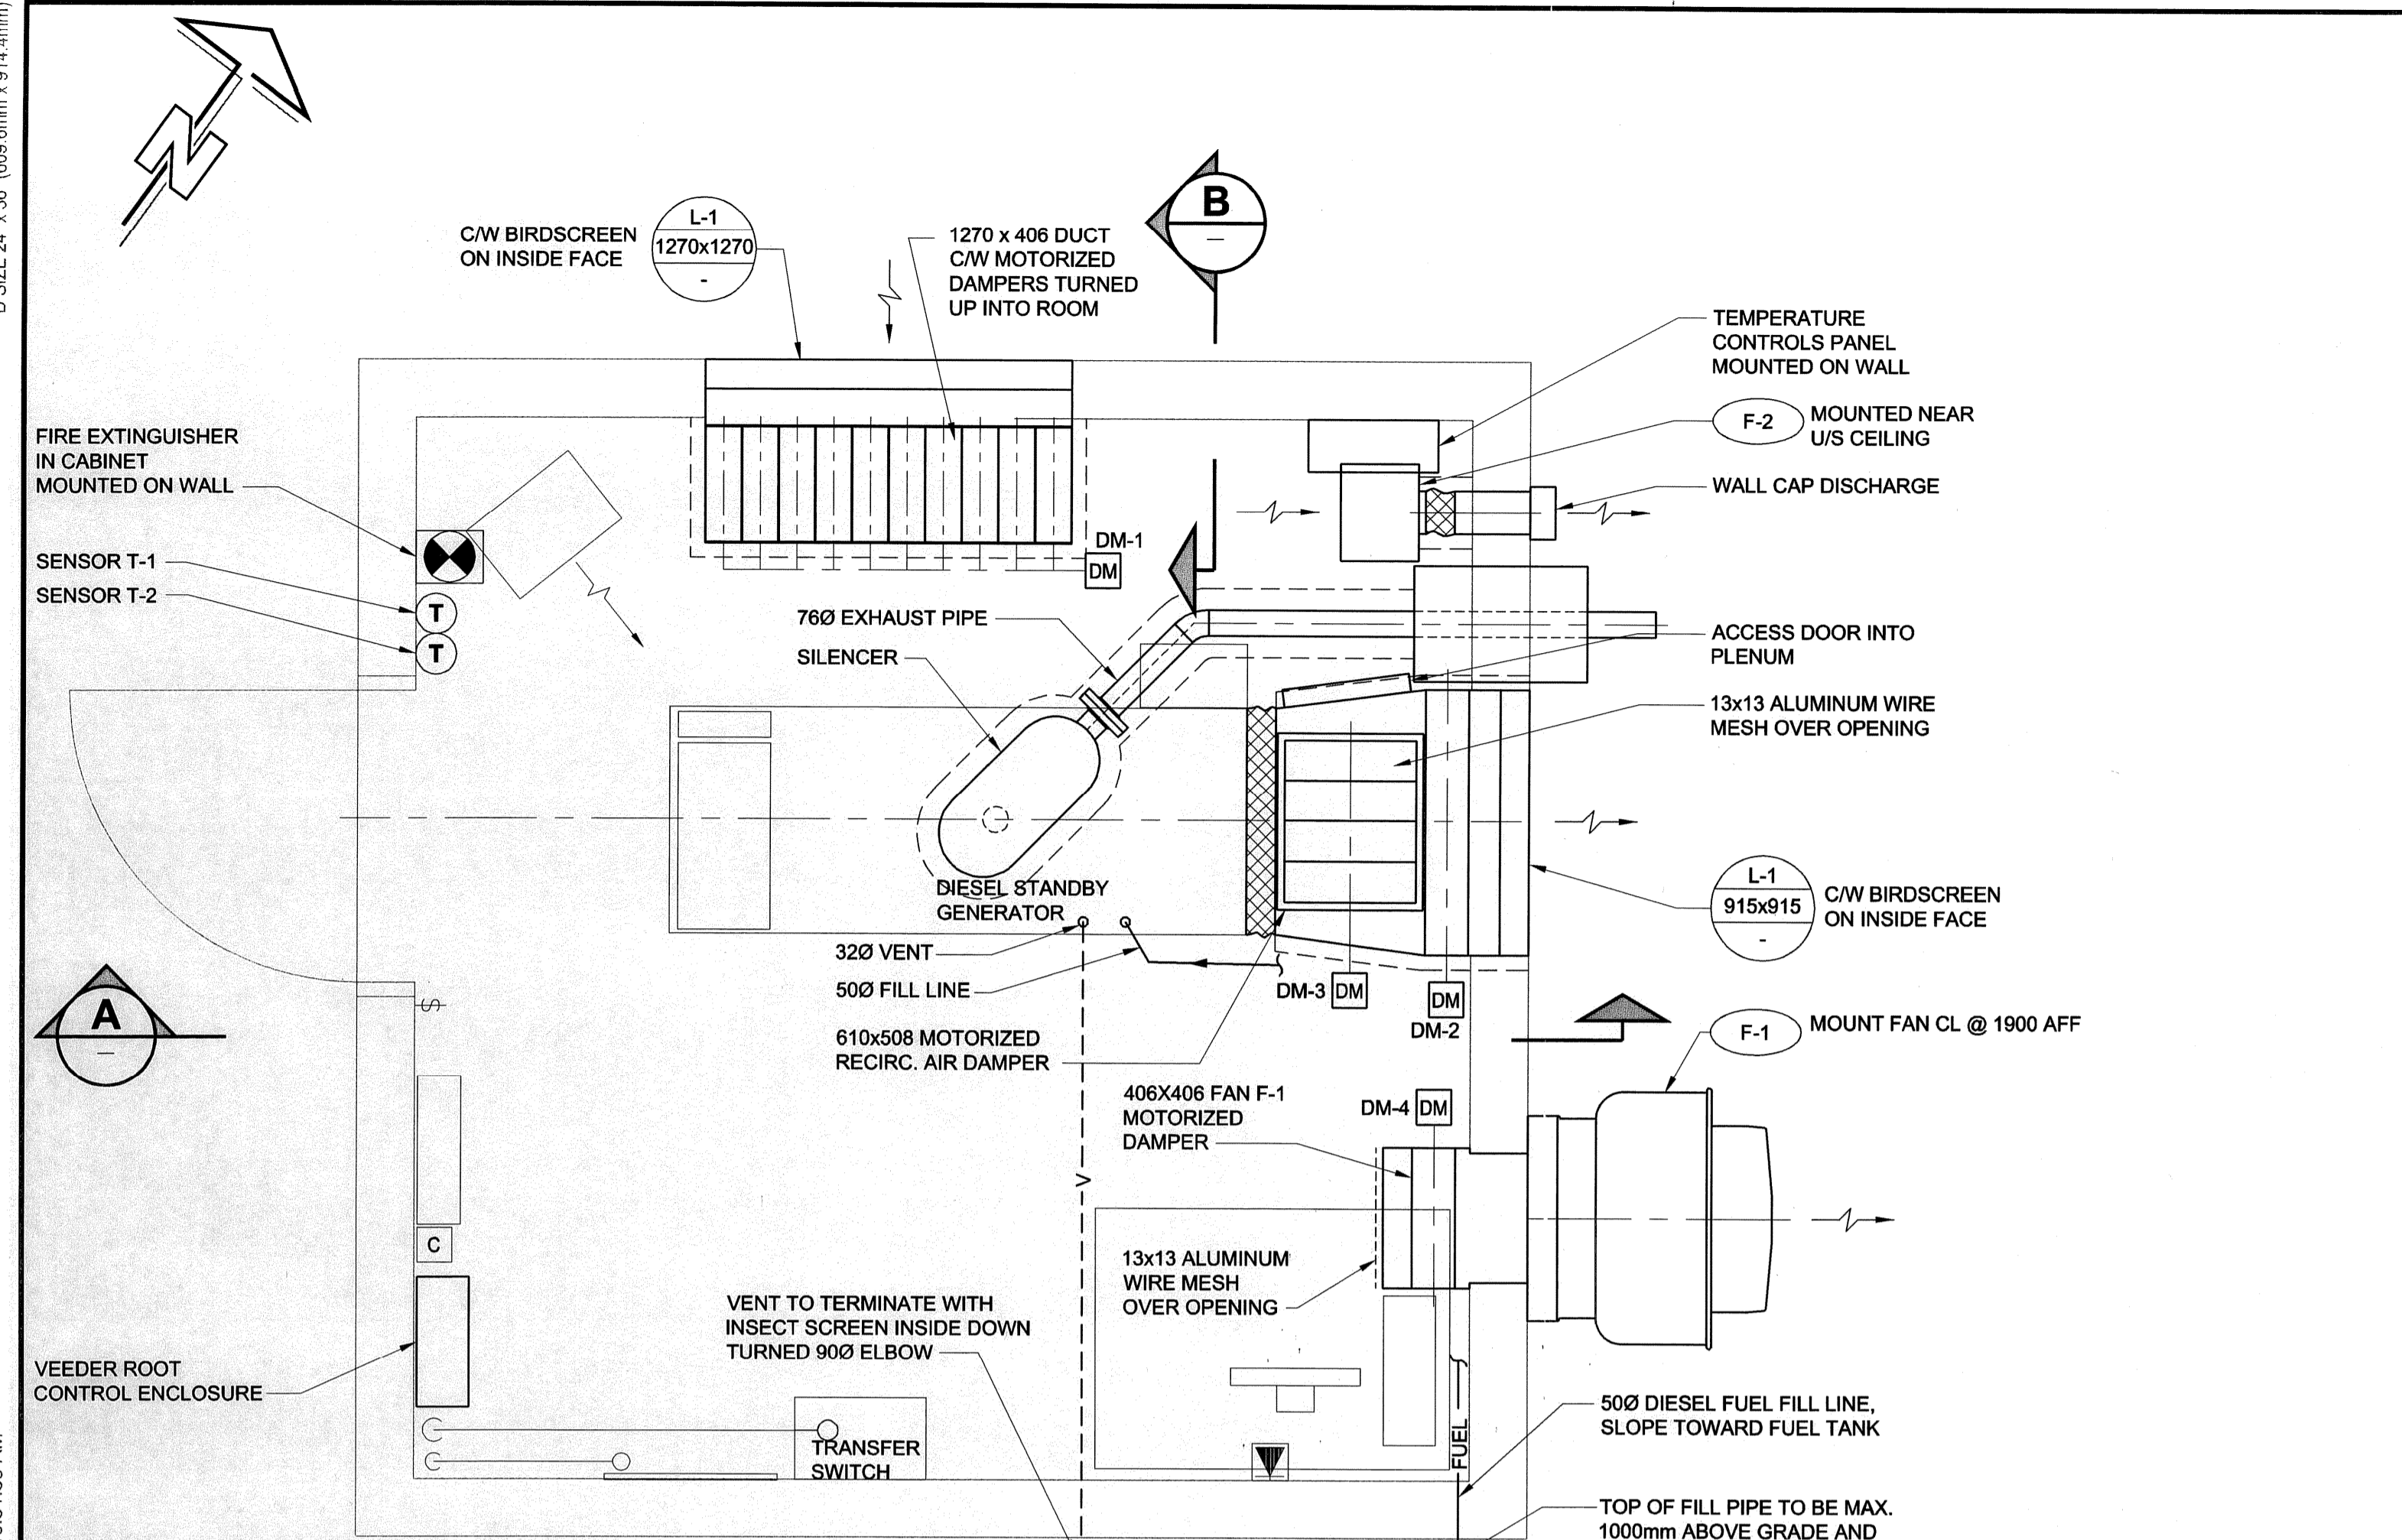

DO NOT SCALE THIS DOCUMENT.
 ALL MEASUREMENTS MUST BE OBTAINED FROM STATED DIMENSIONS.

© 2008 UMA ENGINEERING LTD. ALL RIGHTS RESERVED.
 THIS DOCUMENT IS PROTECTED BY COPYRIGHT LAW AND MAY NOT BE REPRODUCED IN ANY MANNER, OR FOR ANY PURPOSE EXCEPT BY THE WRITTEN PERMISSION OF UMA ENGINEERING LTD.

PROFESSIONAL SEALS

PRELIMINARY
 NOT FOR CONSTRUCTION

Date: 2008/04/21

I/R	YY/MM/DD	ISSUE/REVISION DESCRIPTION	DRN	CHK	DES	ENG	IDR	APP
C	08/04/21	Issued For Bid						
B	08/04/07	Issued For Review	RS	ALS	RBT	CC	BP	-
A	08/03/07	Issued For Review	ALS	RS	RBT	CC	BP	-

UMA | AECOM

City of Winnipeg
Construction of a New Fueling Facility
District 6 Public Works Yard, 1539 Waverley St.
Kiosk Plan, Section and Control Diagram

PROJECT NUMBER	DRAWING NUMBER	ISSUE/REVISION
0265-405-00	01-M-0006	C