


REF. or DRAWING No. **SEP-892**
 FILE # SU10162


DETAILS

3130110300


3130110300

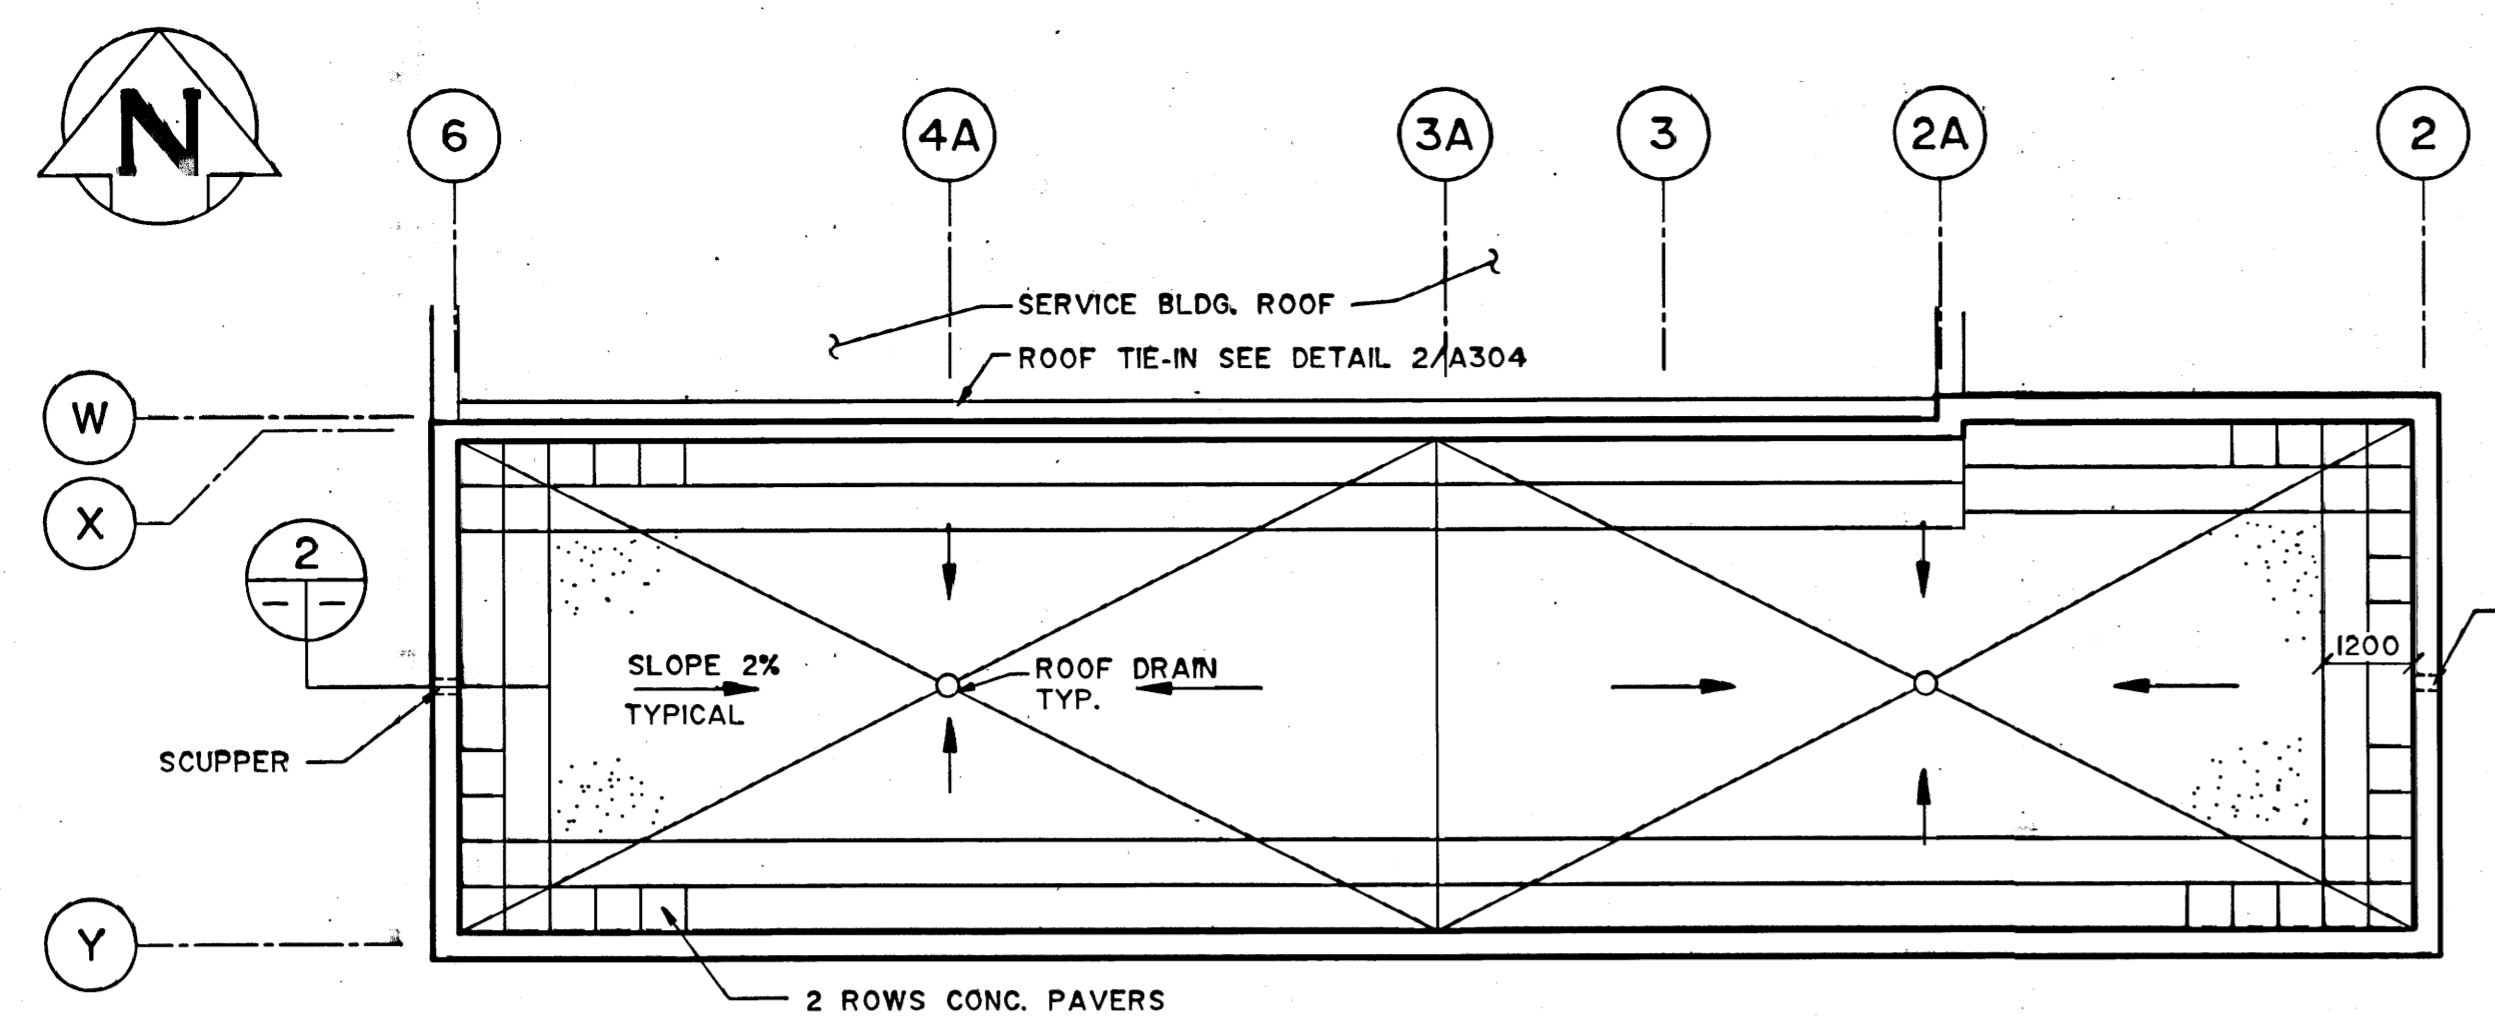


1 ROOF PLAN
1 : 100

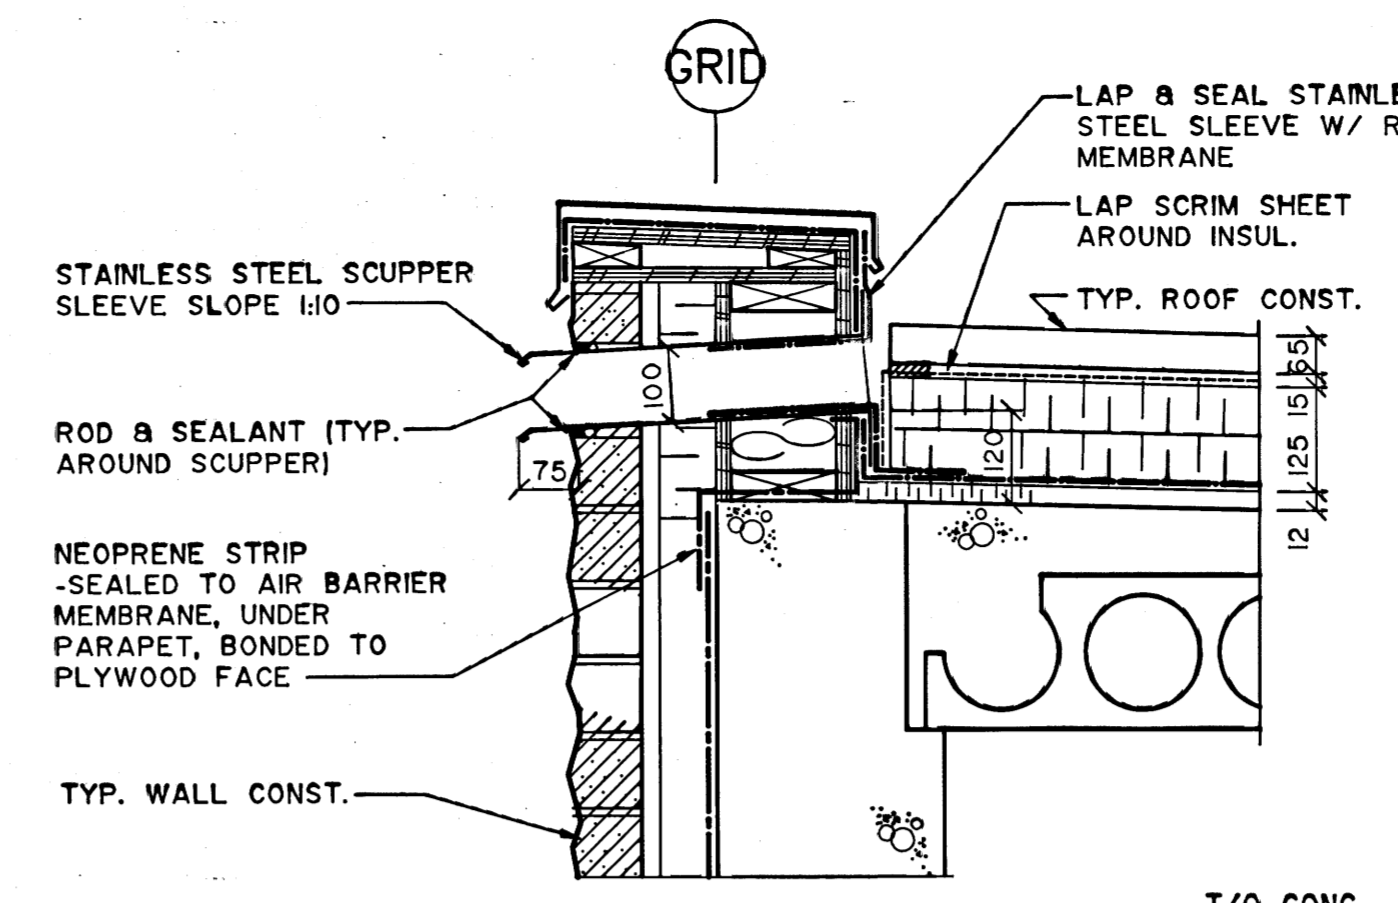


2 SCUPPER DETAIL
1 : 10

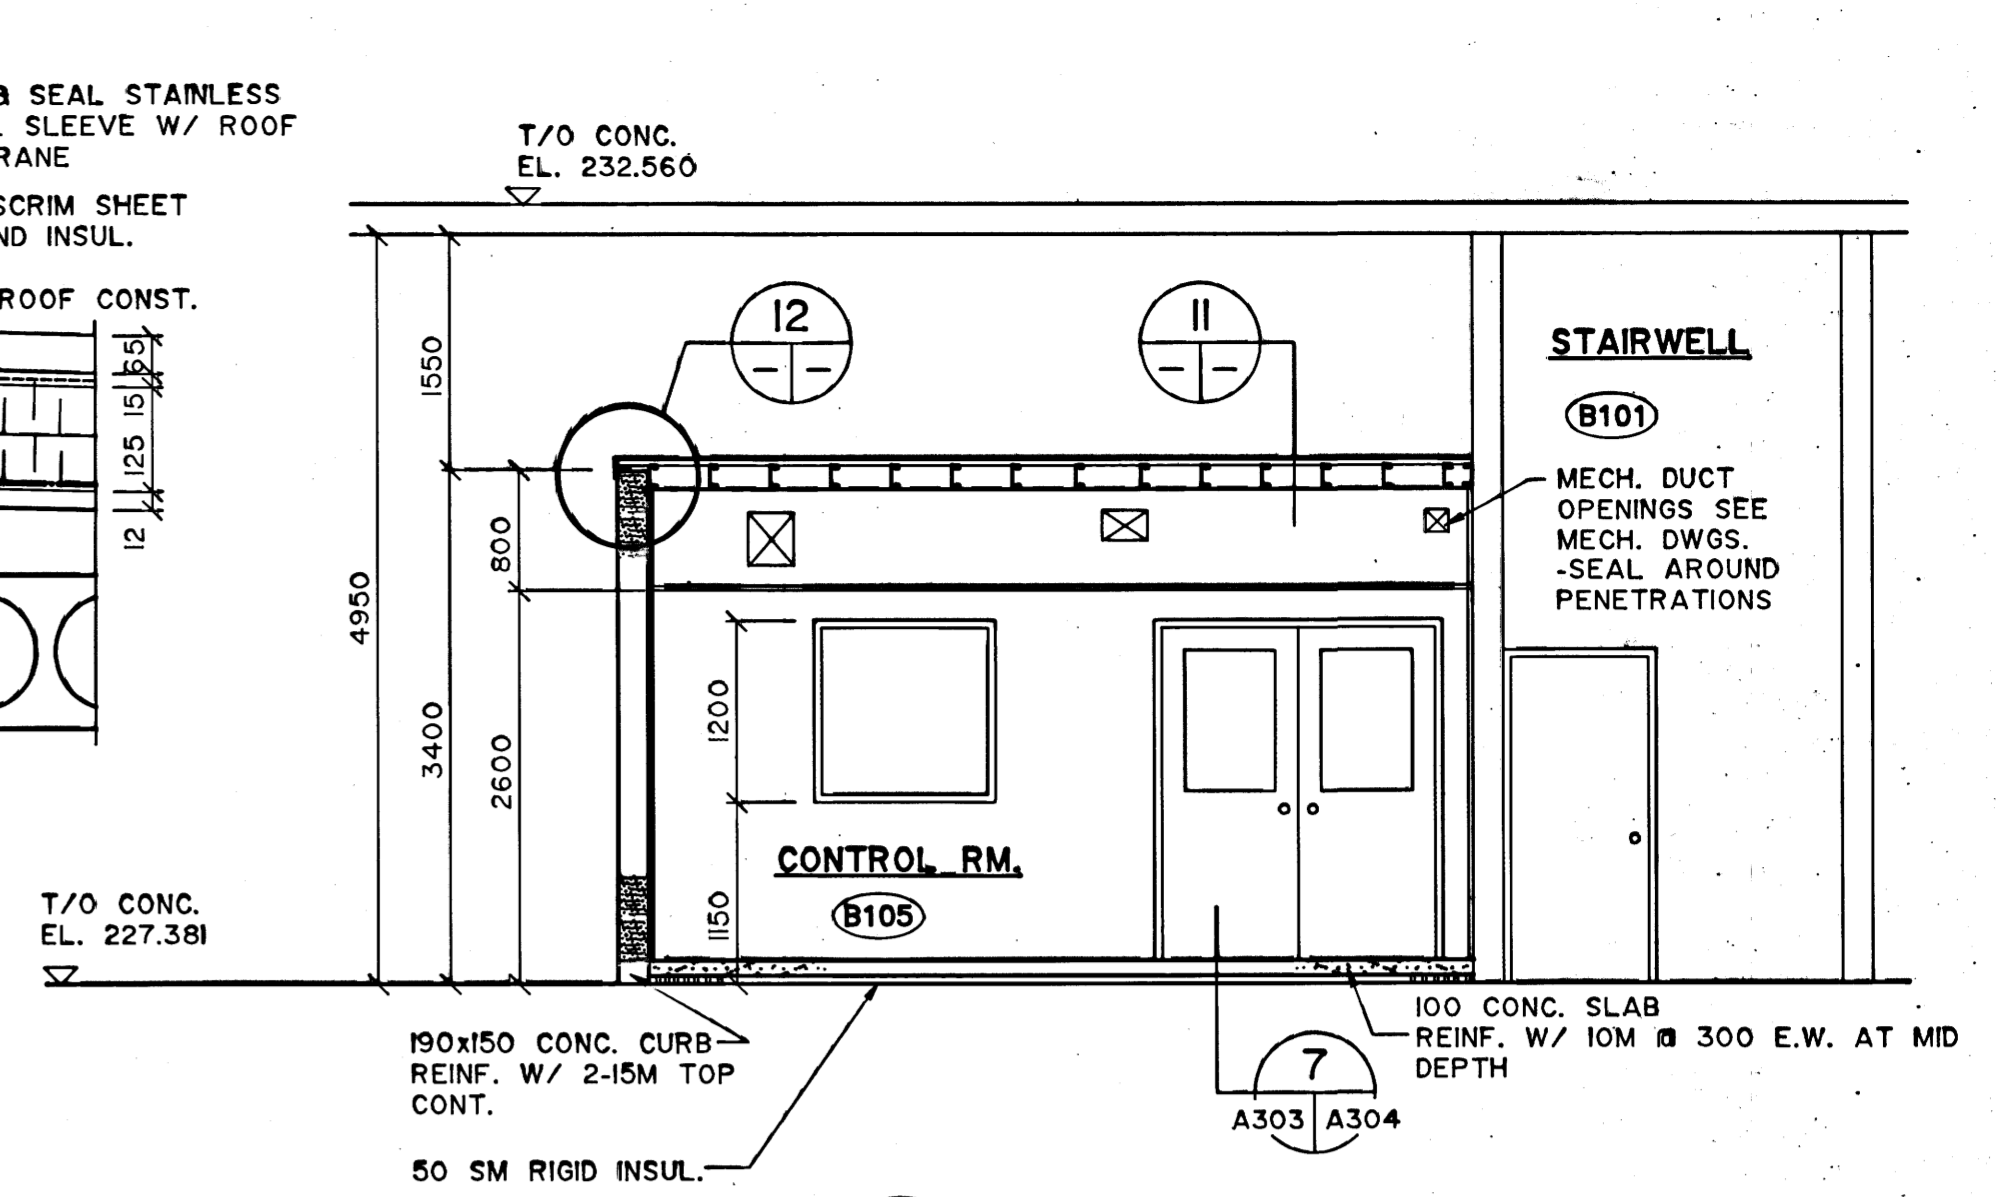


9 INTERIOR ELEVATION
A301 A303 1 : 50

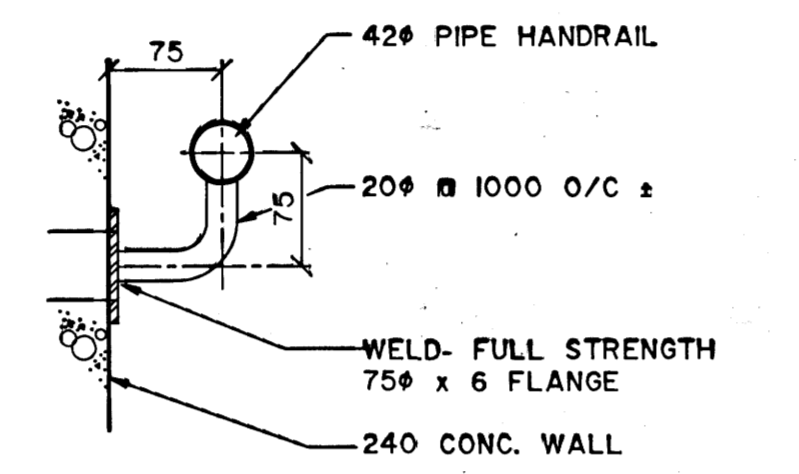


8 BRACKET DETAIL
1 : 20

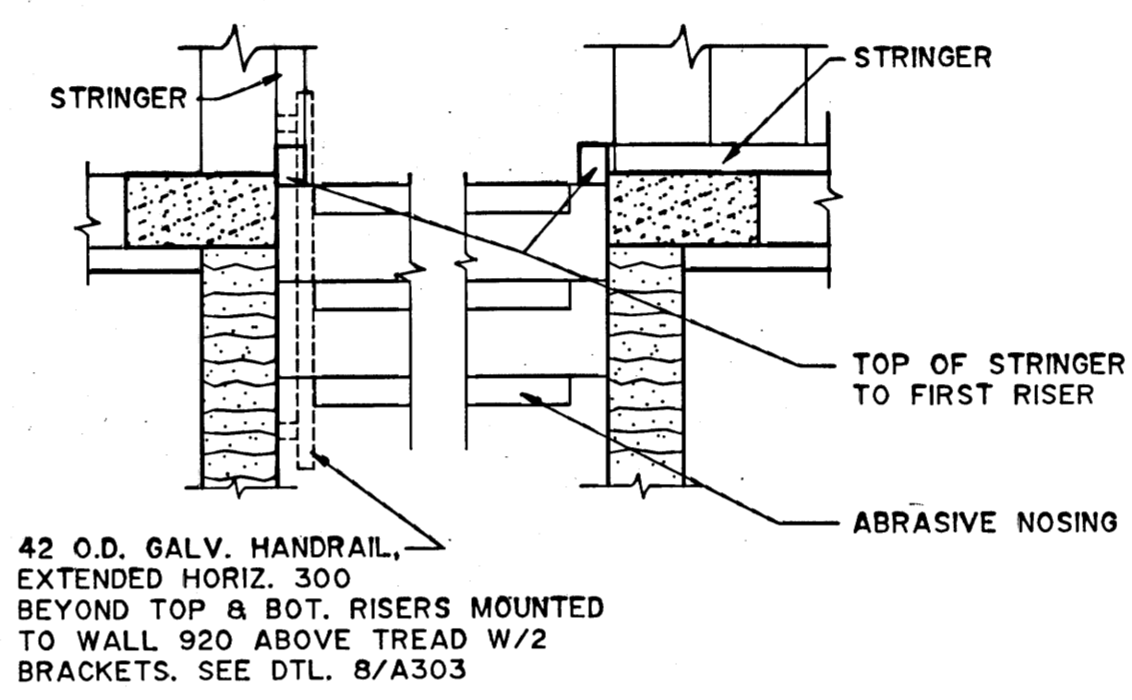


5 STAIR DETAIL
A301 A303 1 : 20

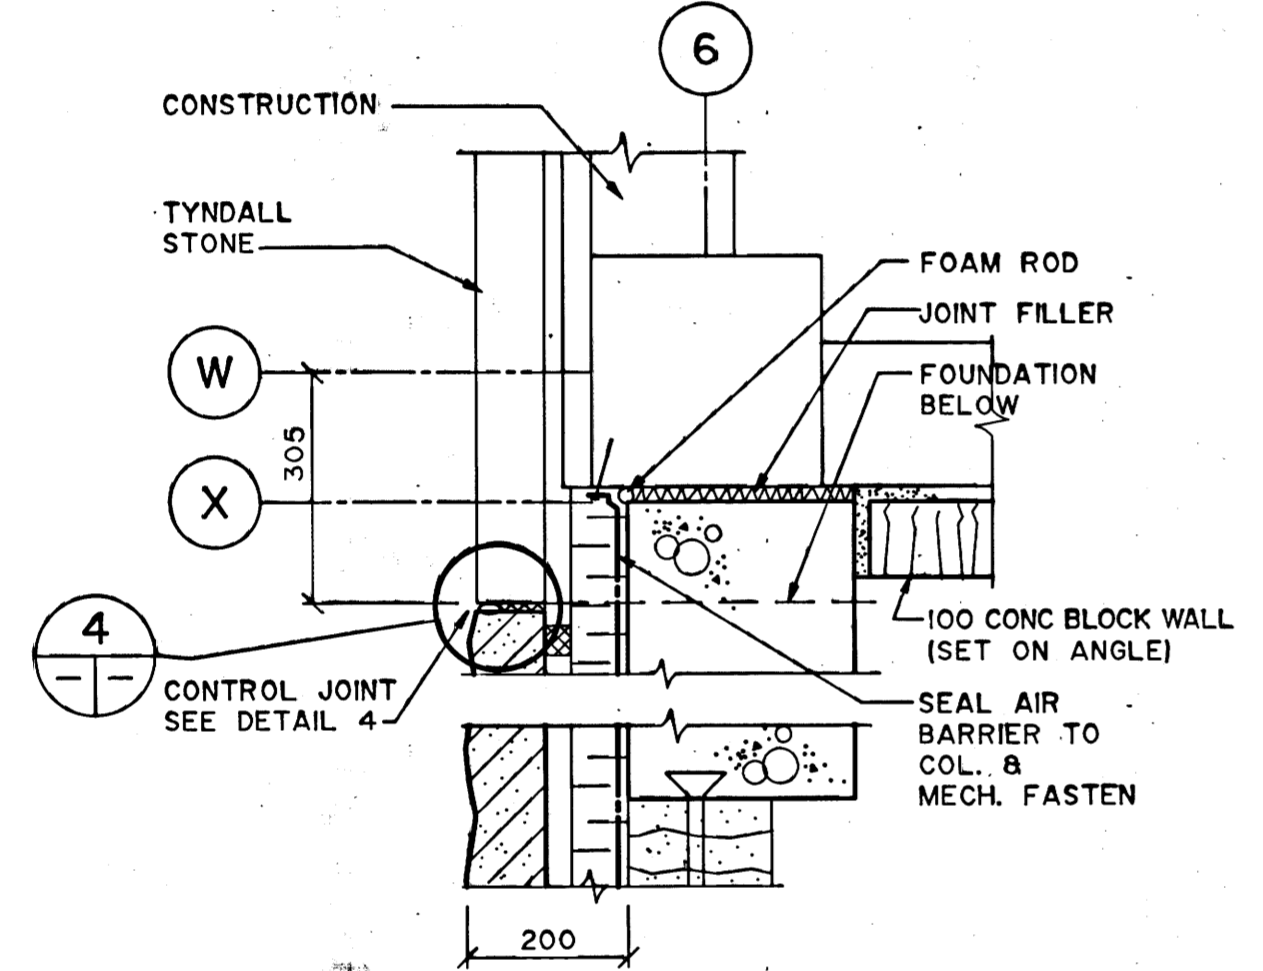


3 CORNER DETAIL
A301 A303 1 : 10

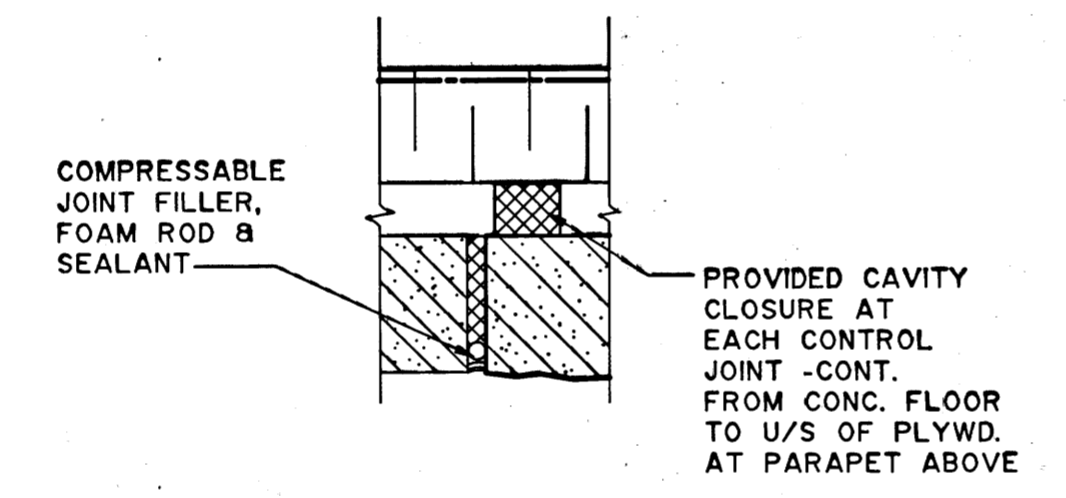


4 CONTROL JOINT PLAN DETAIL (TYP.)
A301 A303 1 : 5

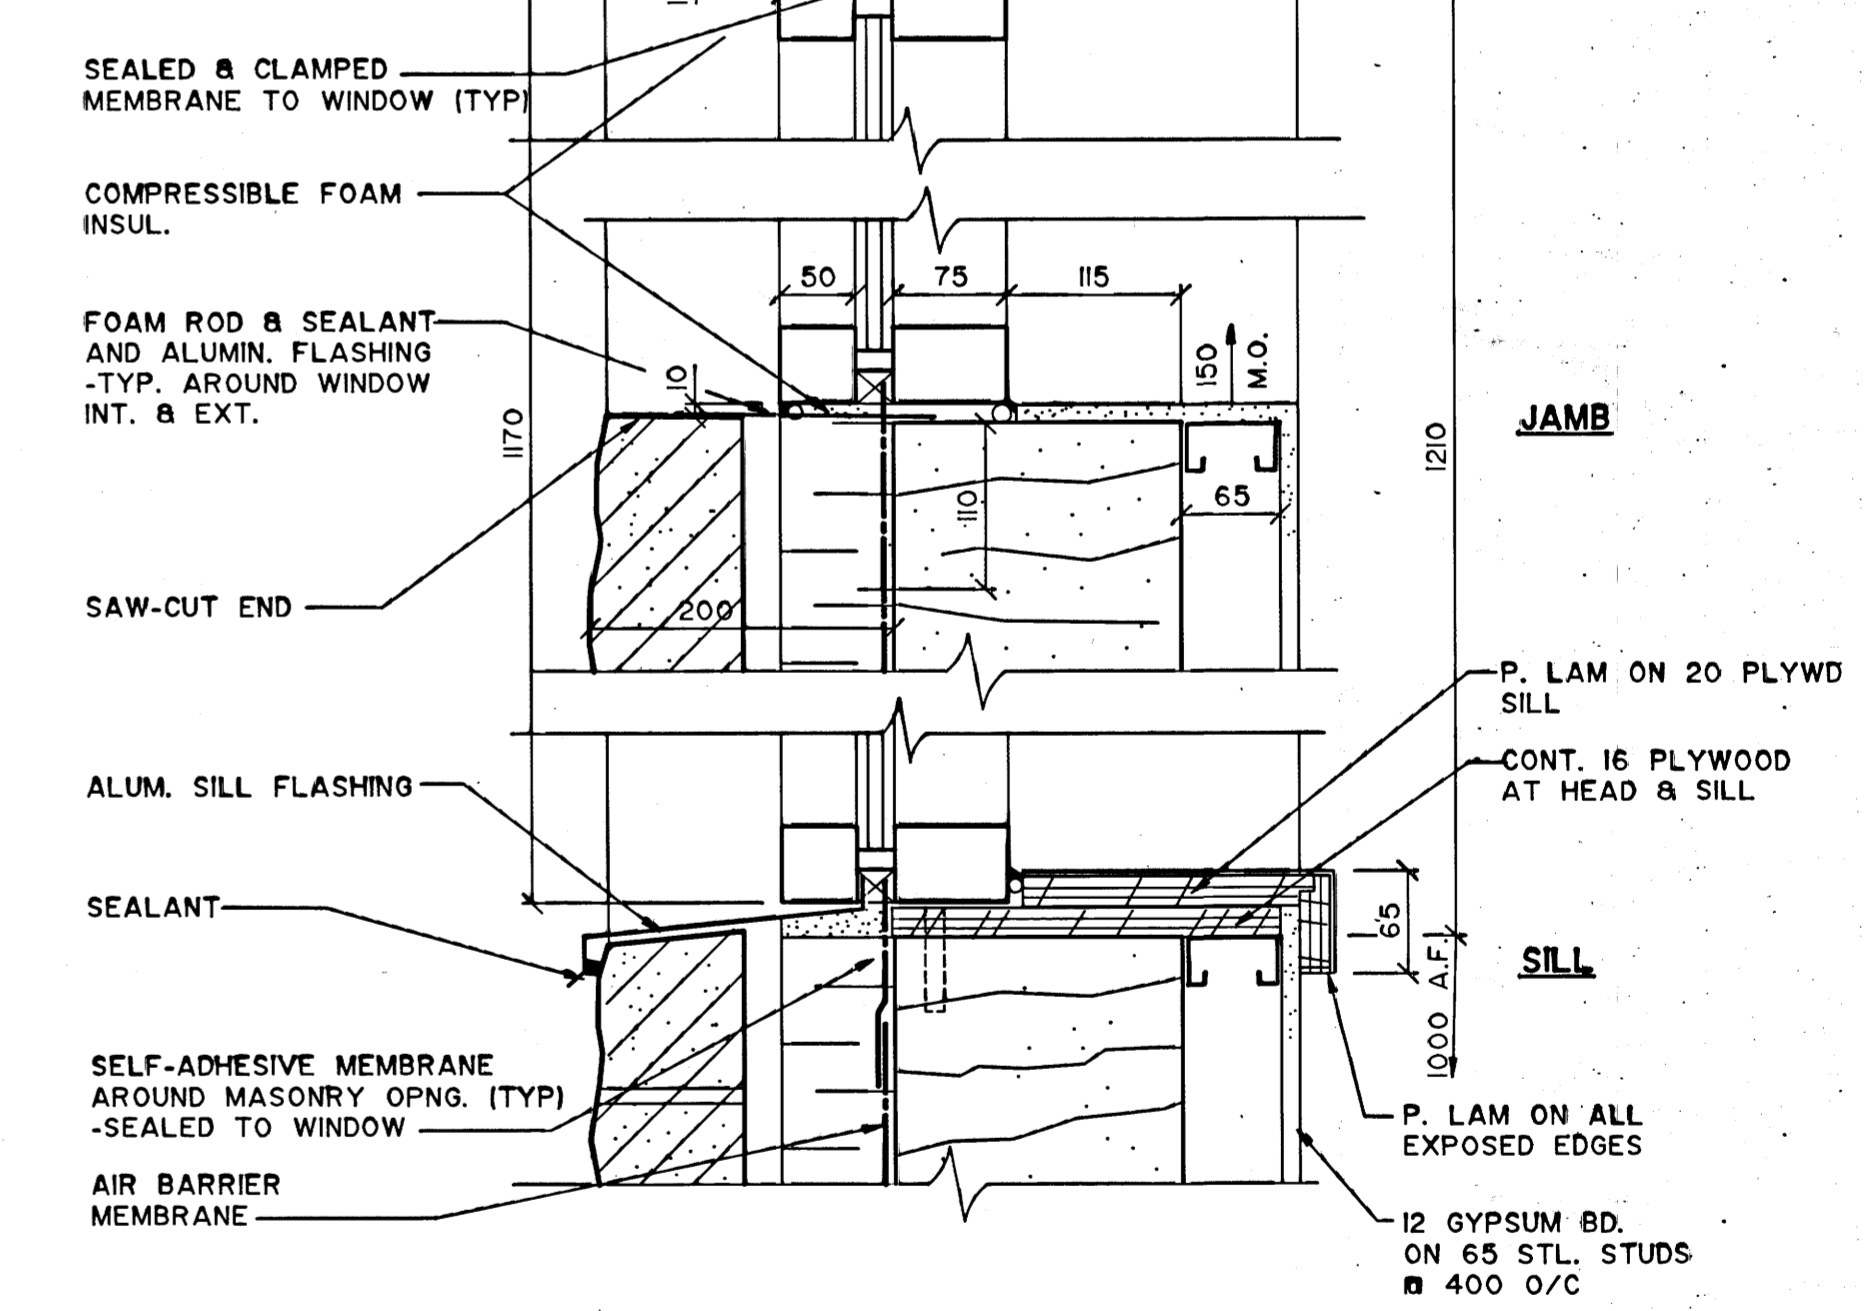


10 UPPER WINDOW DETAIL
A304 A303 1 : 5

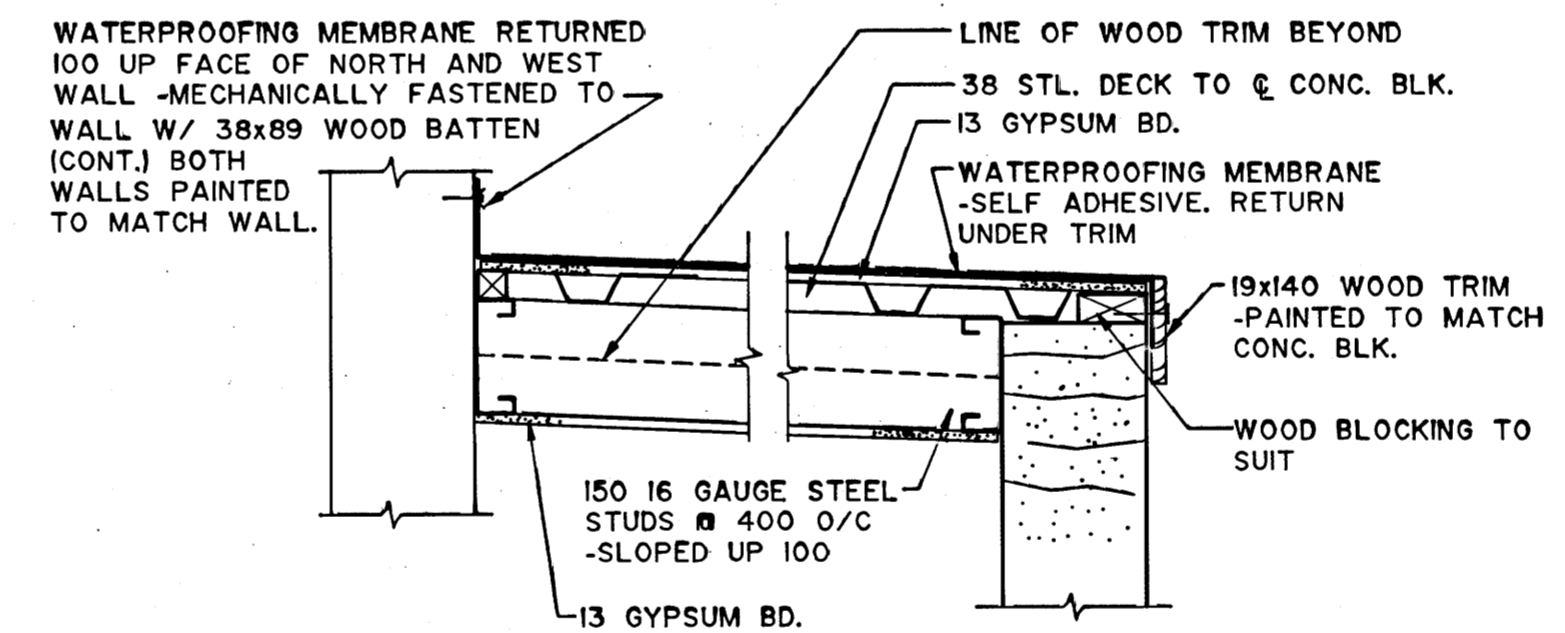


11 DETAIL @ NORTH AND SOUTH WALL
1 : 10

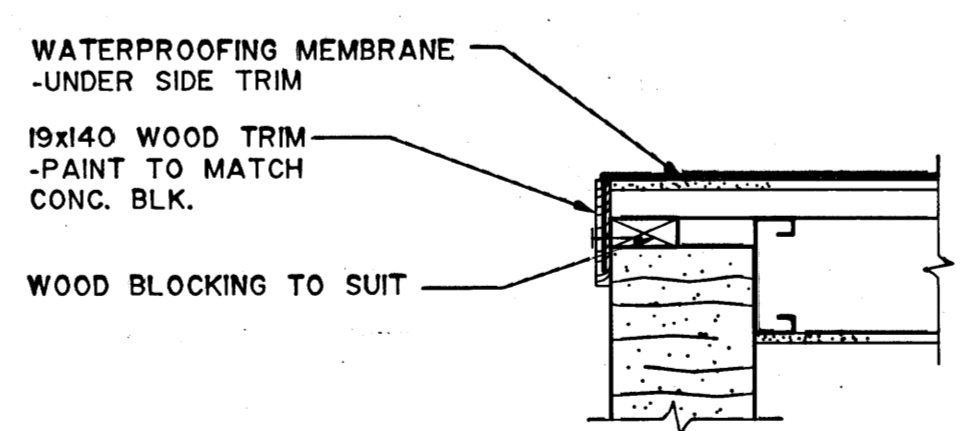

12 DETAIL @ EAST WALL
1 : 10

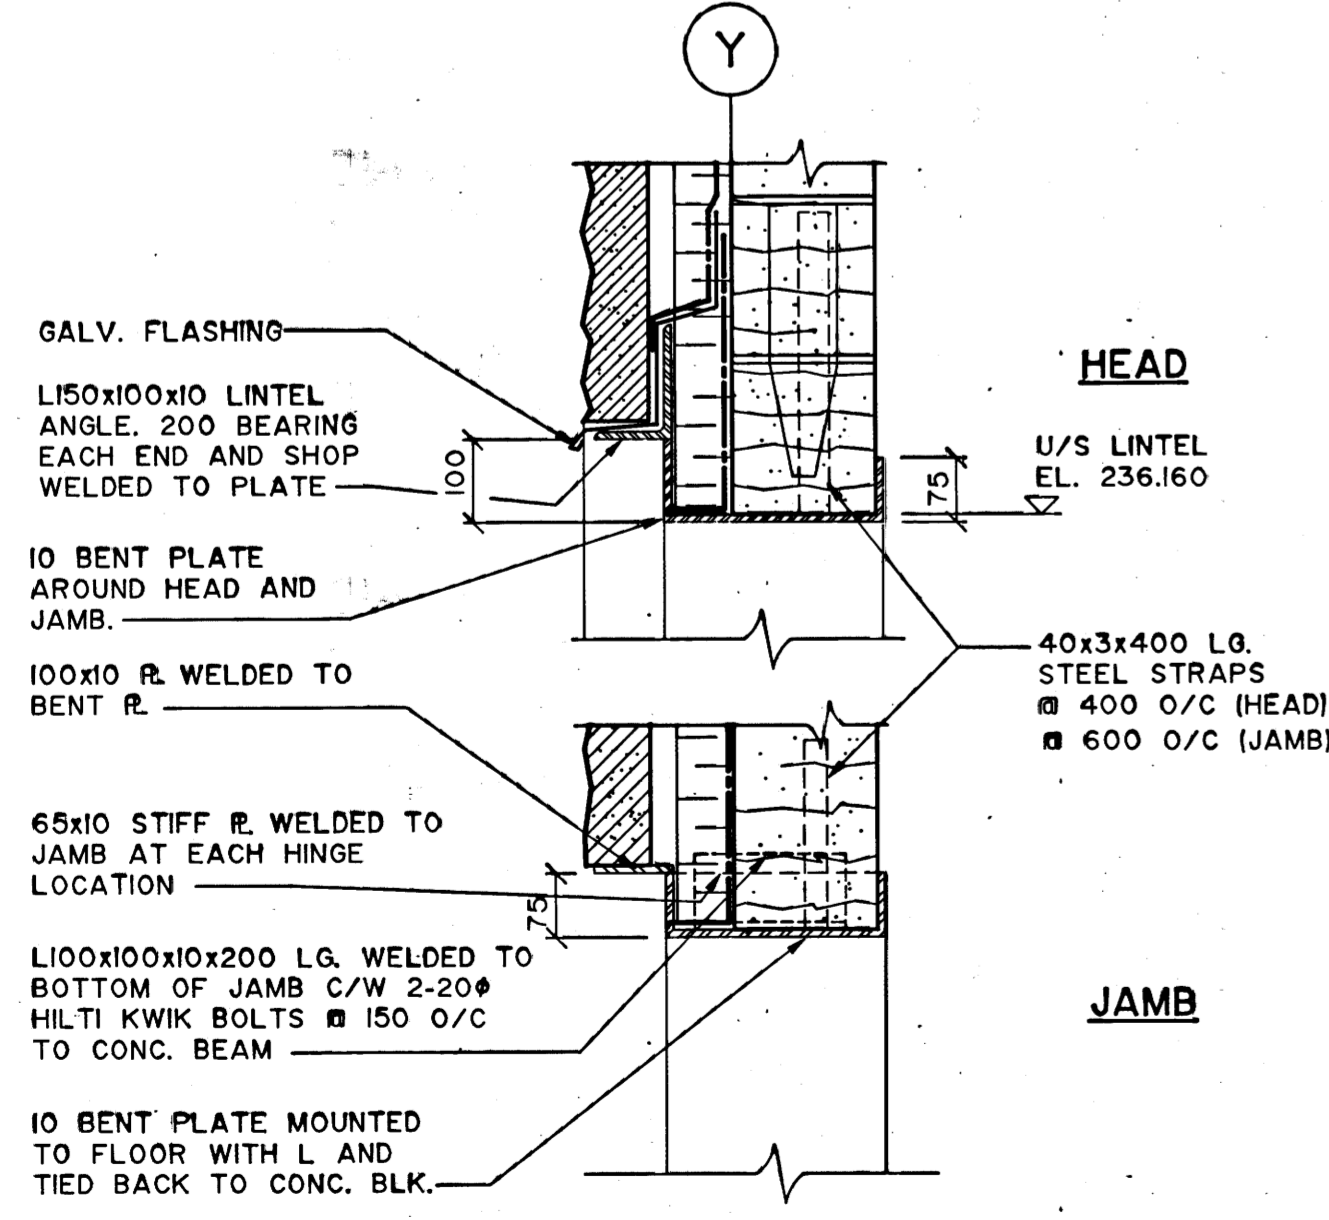

6 O.H. DOOR DETAILS
A302 A303 1 : 10

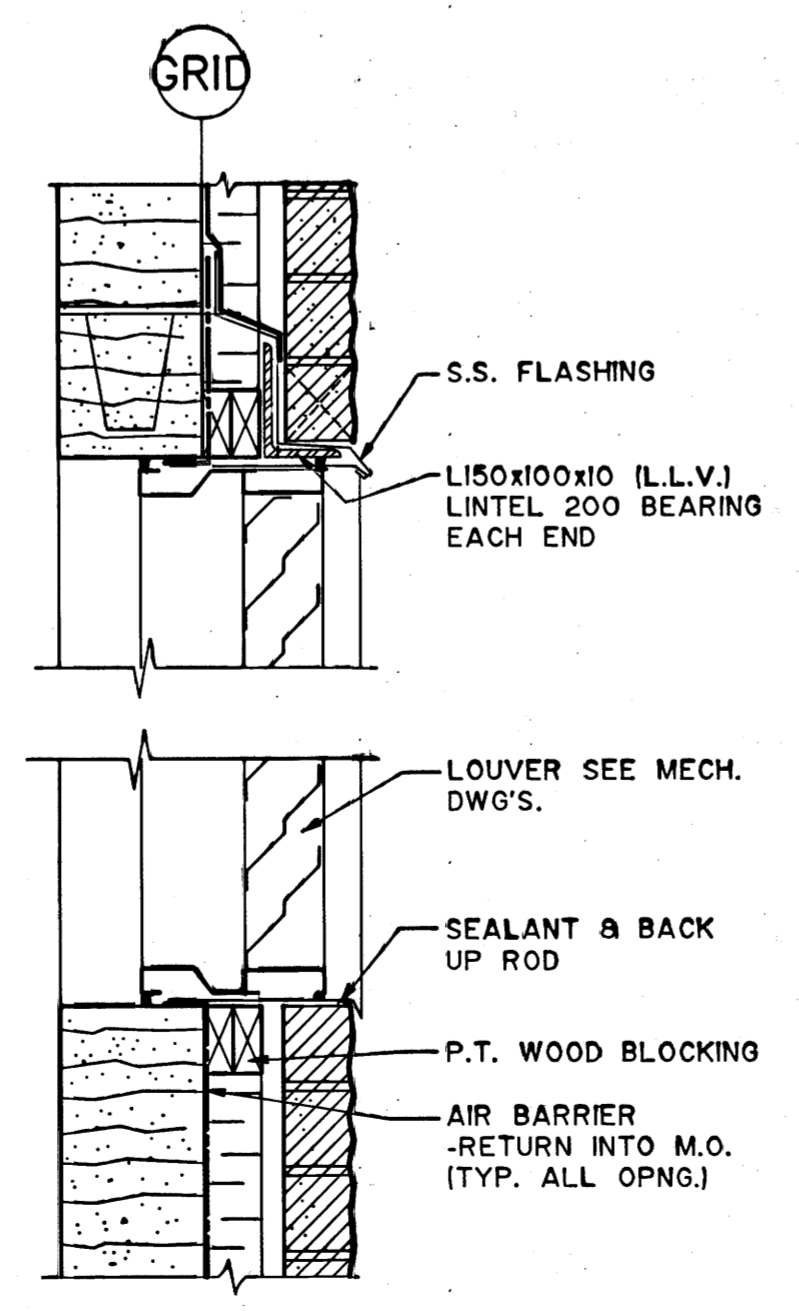

7 LOUVER DETAIL
A302 A303 1 : 10

AS CONSTRUCTED
 DATE SEPTEMBER 1993 BY P.R.B.
 APPROVED BY P. Baldwin

ORIGINALLY DESIGNED BY

B.M. ELEV.	MacLAREN ENGINEERS INC. WARDROP ENGINEERING INC.		ENGINEER'S SEAL	THE CITY OF WINNIPEG WORKS AND OPERATIONS DIVISION WATERWORKS, WASTE & DISPOSAL DEPARTMENT	
	ENGINEERING CONSULTANTS			SOUTH END WATER POLLUTION CONTROL CENTRE	
	DESIGNED BY M.F.	CHECKED BY M.F.		CITY DRAWING NUMBER	
	DRAWN BY G.R.A.	APPROVED BY		SERVICE BUILDING EXPANSION - ARCHITECTURAL	
1 AS CONSTRUCTED 09/93 P.R.B.	HOR. SCALE: 1 : 100 U/N	RELEASED FOR CONSTRUCTION	CONSULTANT DRAWING NO. 10009-2001-B-A303	SHEET OF	
0 ISSUED FOR TENDER 12/91 E.H.				SEP-892	
- ISSUED FOR CITY REVIEW 05/91 M.F.					
NO. REVISIONS	DATE	BY	DATE	MAY 91	

file # SU10162