
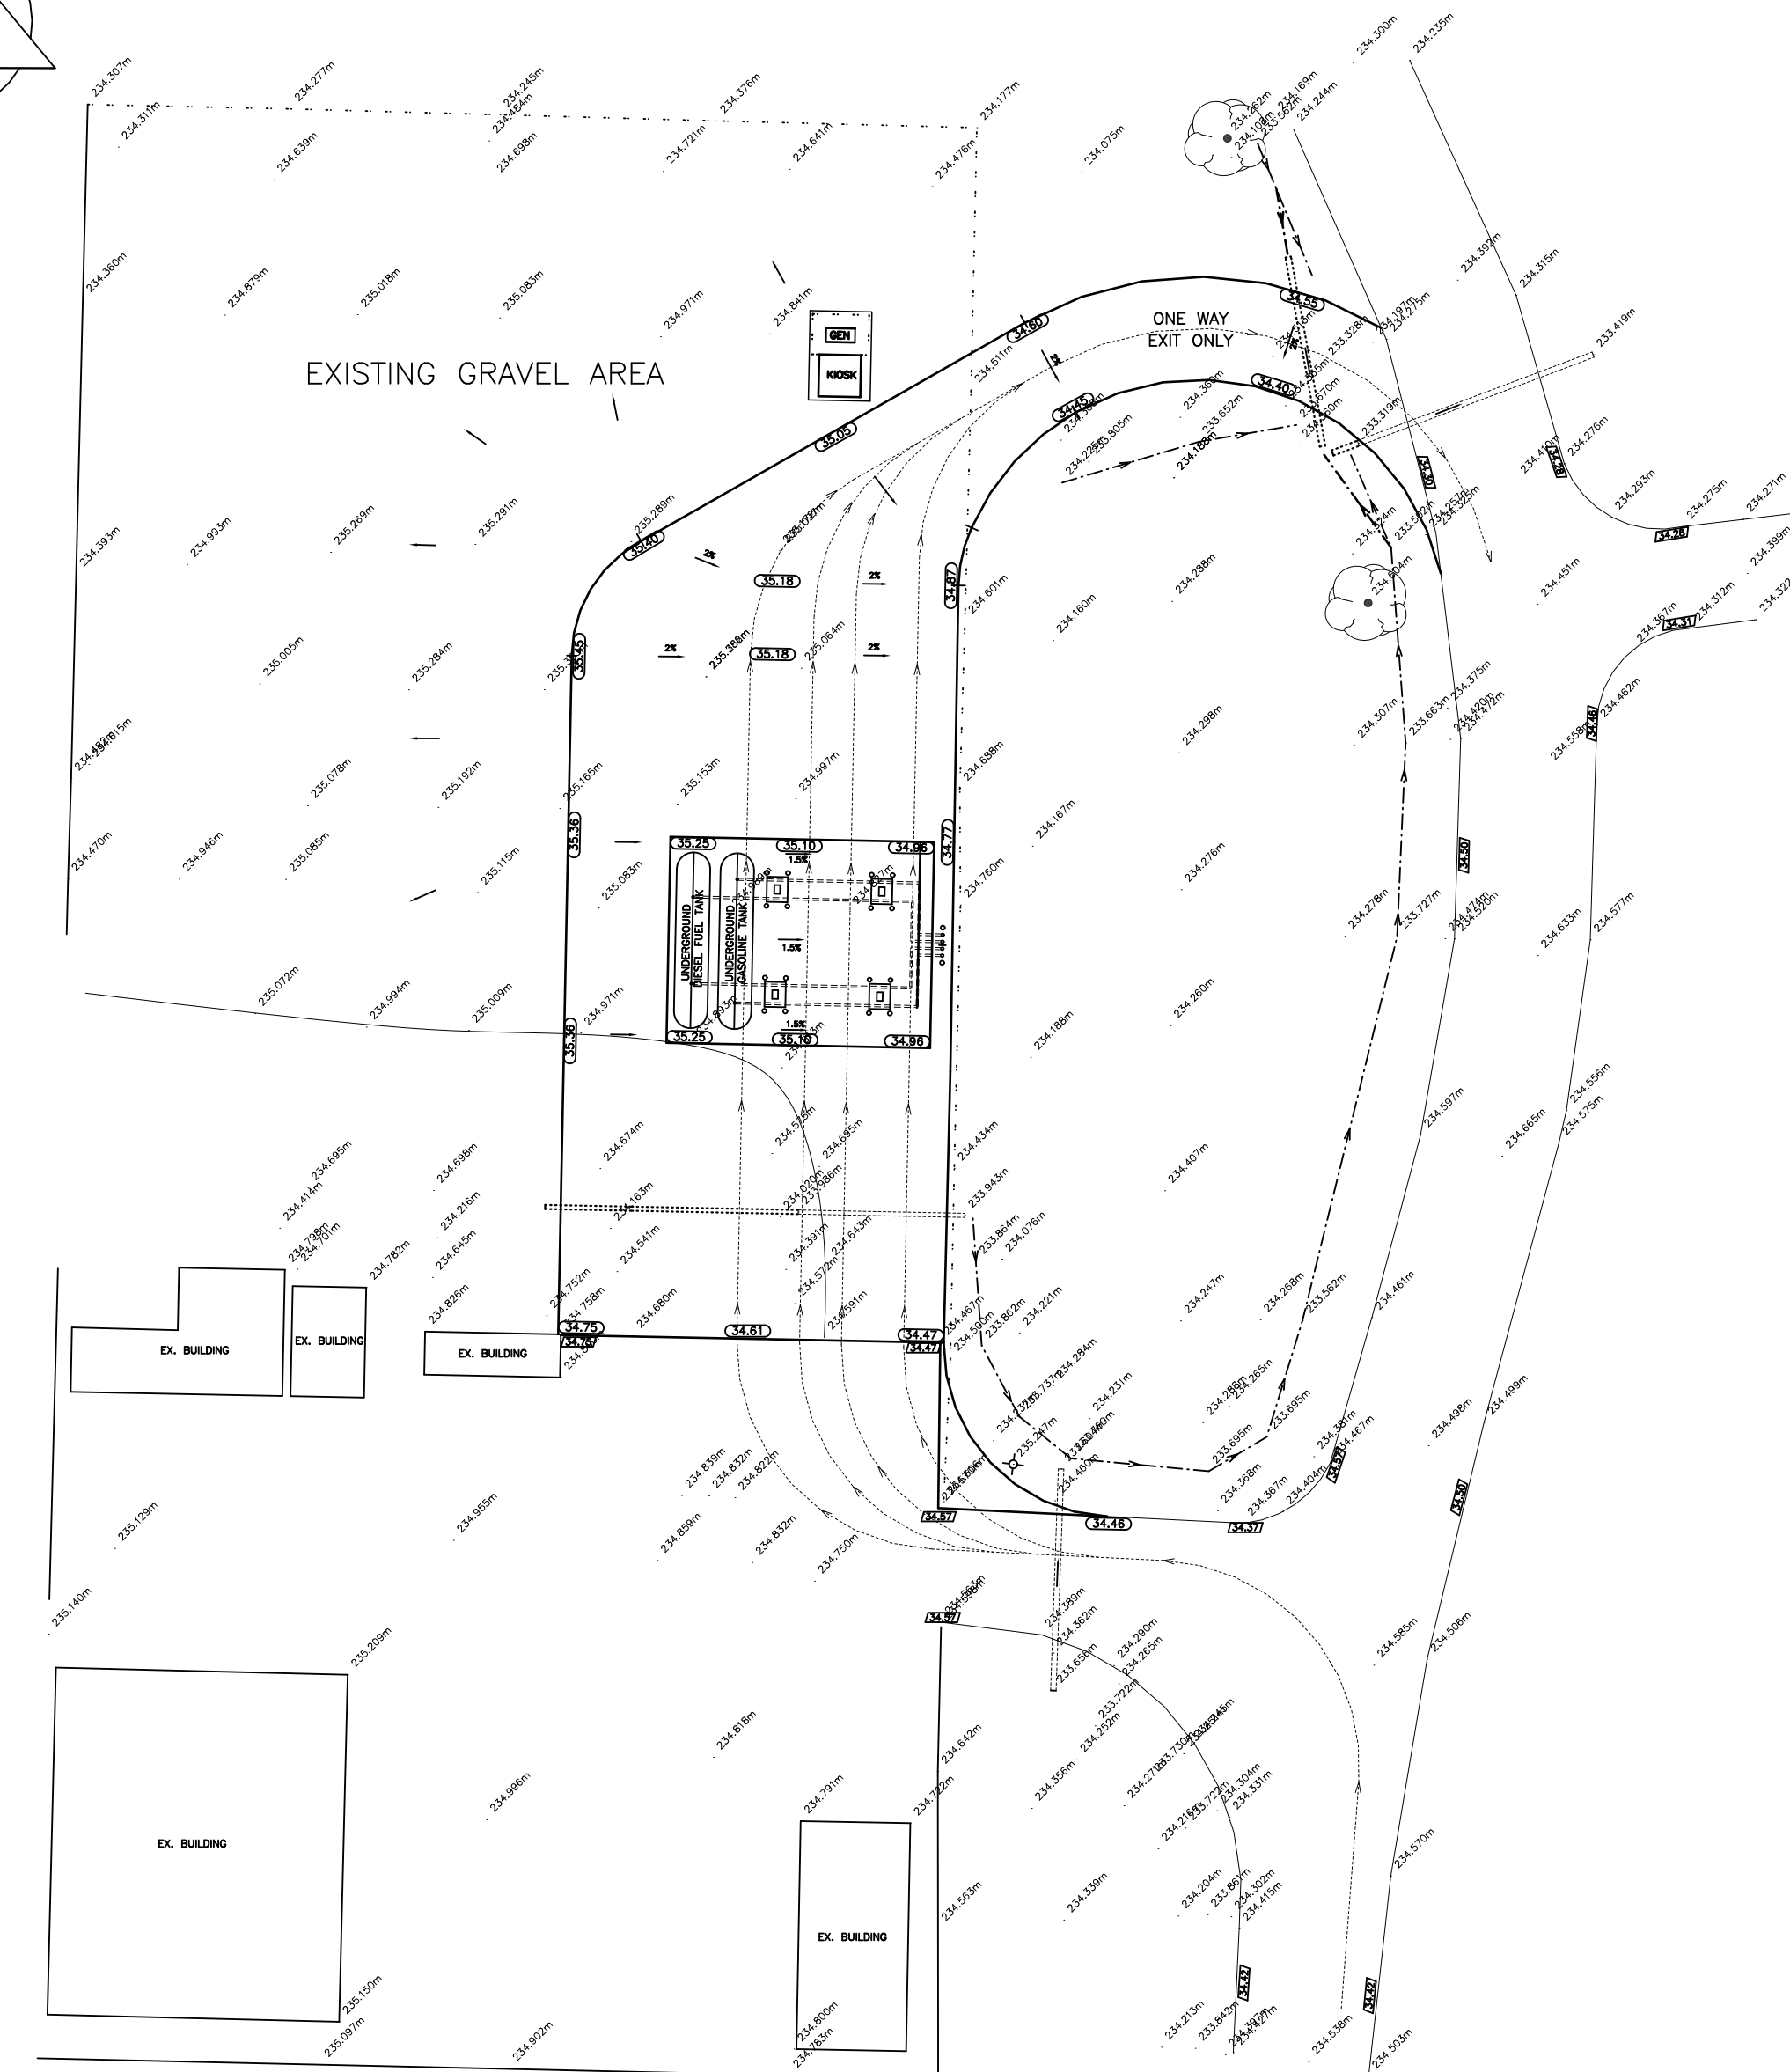


PAD AND NEW APPROACH DETAIL
SCALE 1:250

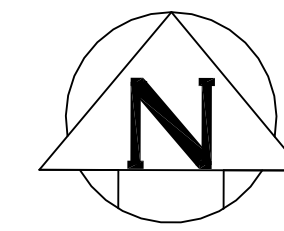

OVERALL SITE
SCALE 1:500

NOTE: ALL CONSTRUCTION TO MEET CITY OF WINNIPEG STANDARDS

<table border="1"> <tr> <th>EXISTING</th> <th>LEGEND</th> <th>PROPOSED</th> <th>EXISTING</th> <th>LEGEND</th> <th>PROPOSED</th> </tr> <tr> <td></td> <td>HYDRO</td> <td></td> <td></td> <td>MTS MANHOLE</td> <td></td> </tr> <tr> <td></td> <td>WASTE WATER SEWER</td> <td></td> <td></td> <td>HYDRO TRANSFORMER JOINT USE PEDESTAL PROPERTY LINE</td> <td></td> </tr> <tr> <td></td> <td>SHAW CABLE</td> <td></td> <td></td> <td>CONCRETE</td> <td></td> </tr> <tr> <td></td> <td>GATE VALVE</td> <td></td> <td></td> <td>ASPHALT</td> <td></td> </tr> <tr> <td></td> <td>ELEVATION</td> <td></td> <td></td> <td>DITCH</td> <td></td> </tr> </table>	EXISTING	LEGEND	PROPOSED	EXISTING	LEGEND	PROPOSED		HYDRO			MTS MANHOLE			WASTE WATER SEWER			HYDRO TRANSFORMER JOINT USE PEDESTAL PROPERTY LINE			SHAW CABLE			CONCRETE			GATE VALVE			ASPHALT			ELEVATION			DITCH		<table border="1"> <tr> <td>B.M. 49-004 ELEV. 233.960</td> <td>FIELD BOOK #: 137</td> <td colspan="2">LINDAL CONSULTING LTD CONSULTING ENGINEERING - PROJECT MANAGEMENT</td> </tr> <tr> <td>POSTED TO LBS</td> <td></td> <td>DESIGNED BY D.C.</td> <td>CHECKED BY DJL</td> </tr> <tr> <td></td> <td></td> <td>DRAWN BY D.C.</td> <td>APPROVED BY DJL</td> </tr> <tr> <td></td> <td></td> <td>HOR. SCALE AS NOTED</td> <td>RELEASED FOR CONSTRUCTION</td> </tr> <tr> <td></td> <td></td> <td>VERTICAL N/A</td> <td></td> </tr> <tr> <td></td> <td></td> <td>DATE JUNE 2008</td> <td>DATE</td> </tr> </table>	B.M. 49-004 ELEV. 233.960	FIELD BOOK #: 137	LINDAL CONSULTING LTD CONSULTING ENGINEERING - PROJECT MANAGEMENT		POSTED TO LBS		DESIGNED BY D.C.	CHECKED BY DJL			DRAWN BY D.C.	APPROVED BY DJL			HOR. SCALE AS NOTED	RELEASED FOR CONSTRUCTION			VERTICAL N/A				DATE JUNE 2008	DATE	<table border="1"> <tr> <td> Certificate of Authorization Lindal Consulting Ltd. No. 817 June 16, 2008 </td> <td> </td> <td> THE CITY OF WINNIPEG 735 ASSINIBOINE PARK DR </td> <td> SHEET 1 OF 1 CITY DRAWING NUMBER </td> </tr> </table>	 Certificate of Authorization Lindal Consulting Ltd. No. 817 June 16, 2008		 THE CITY OF WINNIPEG 735 ASSINIBOINE PARK DR	SHEET 1 OF 1 CITY DRAWING NUMBER
EXISTING	LEGEND	PROPOSED	EXISTING	LEGEND	PROPOSED																																																													
	HYDRO			MTS MANHOLE																																																														
	WASTE WATER SEWER			HYDRO TRANSFORMER JOINT USE PEDESTAL PROPERTY LINE																																																														
	SHAW CABLE			CONCRETE																																																														
	GATE VALVE			ASPHALT																																																														
	ELEVATION			DITCH																																																														
B.M. 49-004 ELEV. 233.960	FIELD BOOK #: 137	LINDAL CONSULTING LTD CONSULTING ENGINEERING - PROJECT MANAGEMENT																																																																
POSTED TO LBS		DESIGNED BY D.C.	CHECKED BY DJL																																																															
		DRAWN BY D.C.	APPROVED BY DJL																																																															
		HOR. SCALE AS NOTED	RELEASED FOR CONSTRUCTION																																																															
		VERTICAL N/A																																																																
		DATE JUNE 2008	DATE																																																															
 Certificate of Authorization Lindal Consulting Ltd. No. 817 June 16, 2008		 THE CITY OF WINNIPEG 735 ASSINIBOINE PARK DR	SHEET 1 OF 1 CITY DRAWING NUMBER																																																															
<table border="1"> <tr> <th>NO.</th> <th>REVISIONS</th> <th>DATE</th> <th>BY</th> </tr> <tr> <td>2</td> <td>ADDED KIOSK, GEN, VENTS & PIPING</td> <td>8/11/08</td> <td>D.C.</td> </tr> <tr> <td>1</td> <td>REPOSITIONED TANKS, ADDED DIMS.</td> <td>8/6/08</td> <td>D.C.</td> </tr> </table>	NO.	REVISIONS	DATE	BY	2	ADDED KIOSK, GEN, VENTS & PIPING	8/11/08	D.C.	1	REPOSITIONED TANKS, ADDED DIMS.	8/6/08	D.C.	<p>LOCATION APPROVED UNDERGROUND STRUCTURES</p> <p>SUPV. U/G STRUCTURES COMMITTEE DATE</p> <p>NOTE: LOCATION OF UNDERGROUND STRUCTURES AS SHOWN ARE BASED ON THE BEST INFORMATION AVAILABLE BUT NO GUARANTEE IS GIVEN THAT ALL EXISTING UTILITIES ARE SHOWN OR THAT THE GIVEN LOCATIONS ARE EXACT. CONFIRMATION OF EXISTENCE AND EXACT LOCATION OF ALL SERVICES MUST BE OBTAINED FROM THE INDIVIDUAL UTILITIES BEFORE PROCEEDING WITH CONSTRUCTION.</p>	<p>ENGINEER'S SEAL</p> <p>CONSULTANT DRAWING NO. 207-001-S1</p>	<p>SITE PLAN</p> <p>735 ASSINIBOINE PARK DR</p>																																																			
NO.	REVISIONS	DATE	BY																																																															
2	ADDED KIOSK, GEN, VENTS & PIPING	8/11/08	D.C.																																																															
1	REPOSITIONED TANKS, ADDED DIMS.	8/6/08	D.C.																																																															