


PLAN 1
 DEMOLITION
 SCALE 1:100
 0 1000 2000 3000 mm

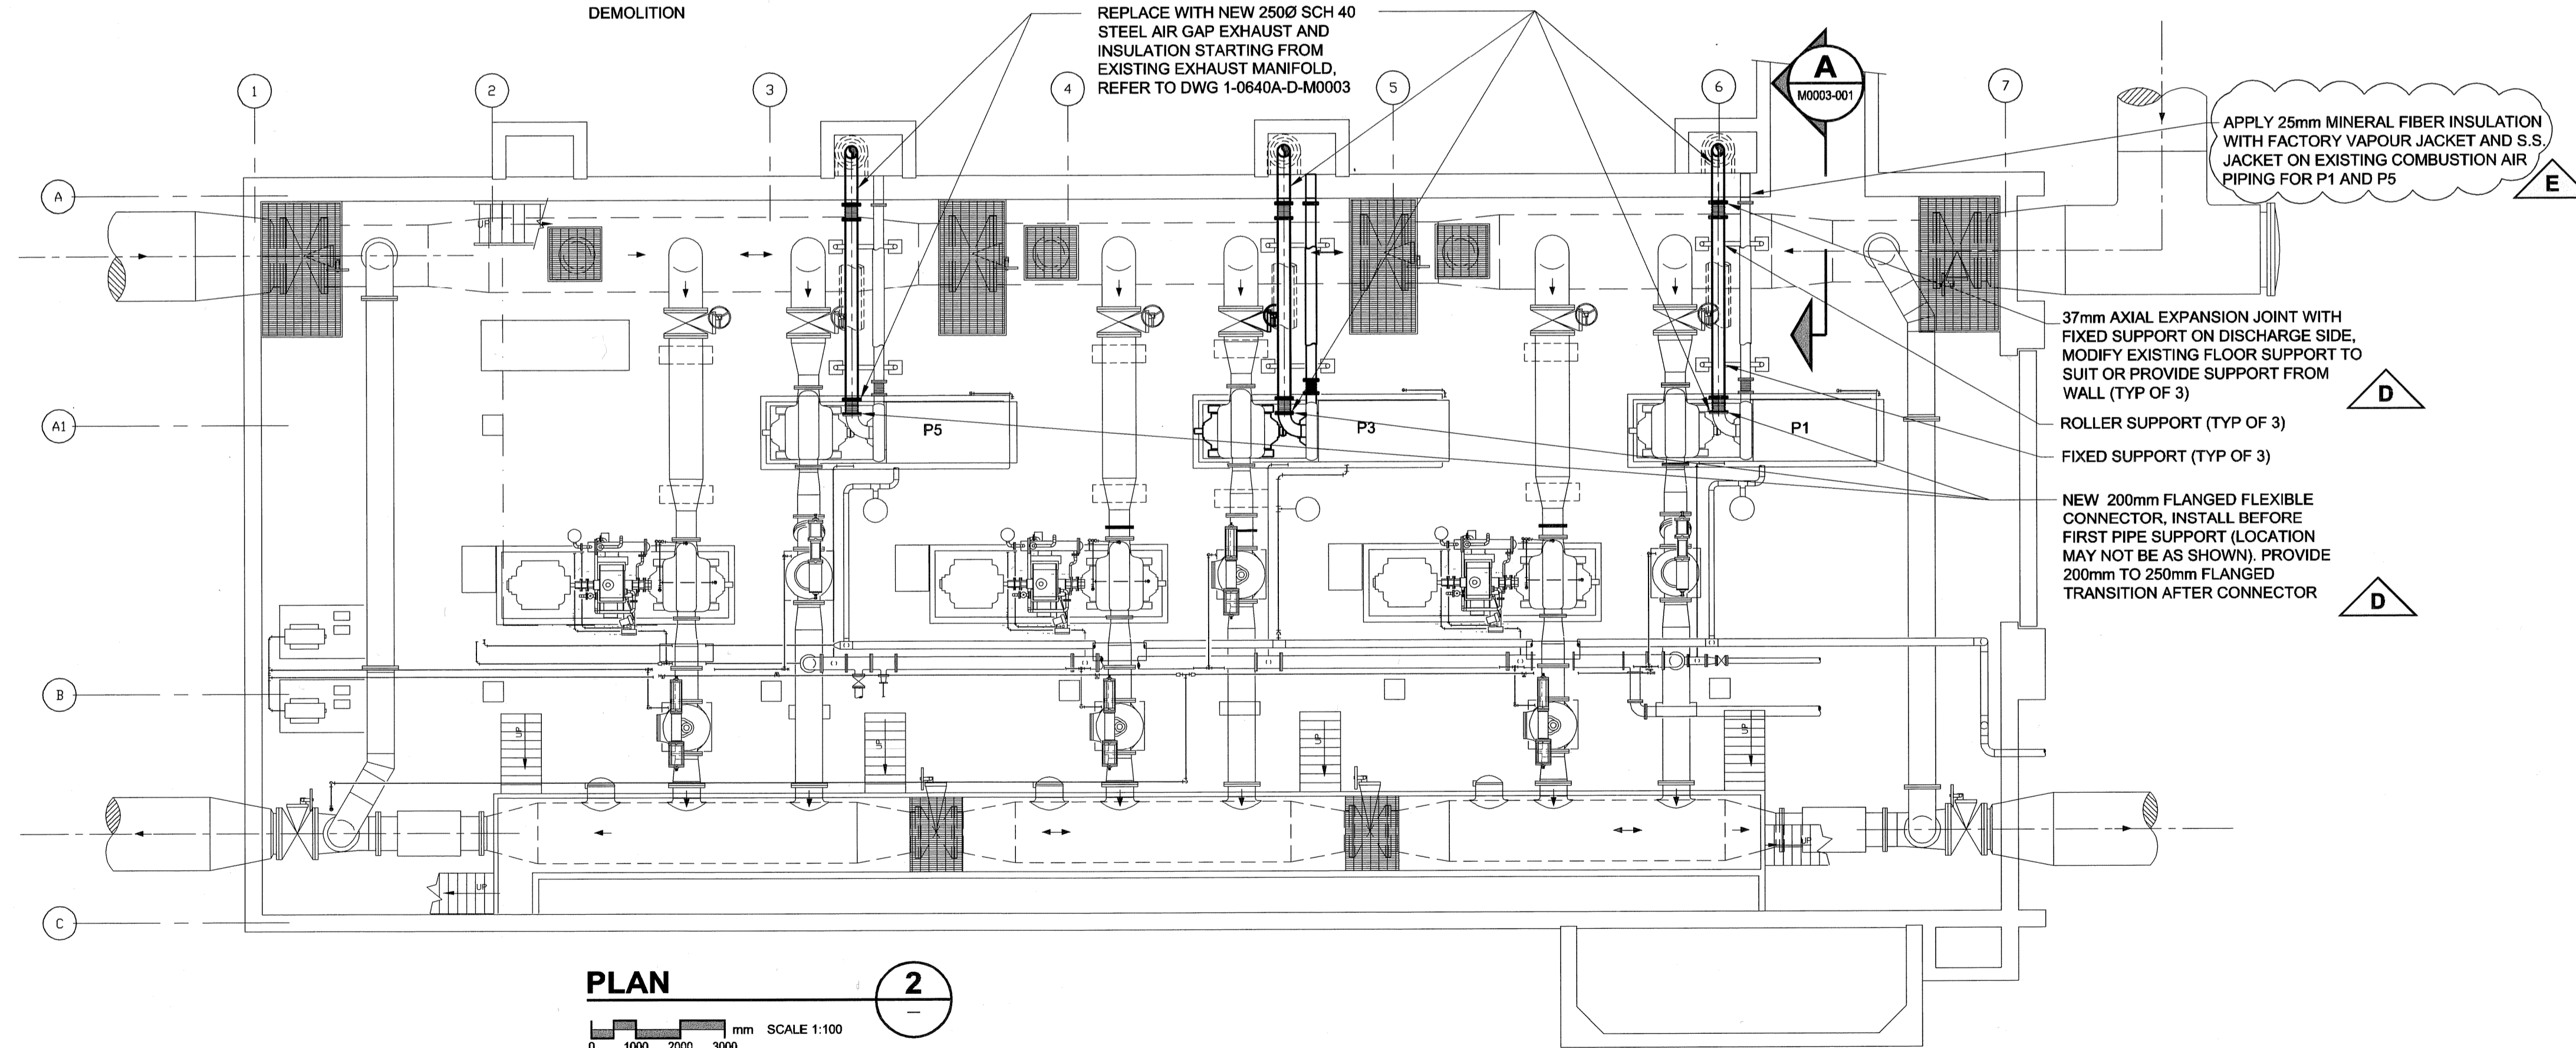

PLAN 2
 NEW CONSTRUCTION
 SCALE 1:100
 0 1000 2000 3000 mm

APECM
 Certificate of Authorization
 UMA Engineering Ltd. (MB)
 No. 256 Date: Dec 15-08

UMA REVIEW
 DRN CHK DES ENG IDR

NO.	REVISIONS	DATE	BY
E	ISSUED FOR ADDENDUM	08/12/15	RS
D	ISSUED FOR ADDENDUM	08/12/10	RS
C	ISSUED FOR BID	08/11/21	RS
B	ISSUED FOR REVIEW	08/10/28	RS
A	ISSUED FOR REVIEW	08/09/29	RS

DESIGNED BY		CC	CHECKED BY
DRAWN BY		RS	APPROVED BY
HOR. SCALE	AS NOTED	RELEASED FOR CONSTRUCTION	
VERT. SCALE	AS NOTED	DATE	

PROFESSIONAL'S SEAL
 PROVINCE OF MANITOBA
 Dec 15-08
 C.A.D. COURCHAINE
 REGISTERED PROFESSIONAL ENGINEER
 CONSULTANT DRAWING NO.
 D265-199-00_04-M-0002_RX.dwg

THE CITY OF WINNIPEG
 WATER AND WASTE DEPARTMENT

Winnipeg

MCPHILLIPS PUMPING STATION
P1, 3, 5 EXHAUST REPLACEMENT
MECHANICAL - DEMOLITION/NEW CONSTRUCTION
PUMP/ENGINE LEVEL FLOOR PLAN

SHEET 1 OF 1
 CITY DRAWING NUMBER
 1-0640M-M0002-001
 REV E

© 2008 UMA Engineering Ltd. All Rights Reserved. This document is protected by copyright law and may not be used, reproduced or modified in any manner or for any purpose except with the written permission of UMA Engineering Ltd. or a party to which its copyright has been assigned. UMA accepts no responsibility, and denies any liability whatsoever, to any party that uses, reproduces, modifies, or relies on this document without UMA's express written consent.