



THE CITY OF WINNIPEG

WATER AND WASTE DEPARTMENT


REPLACEMENT OF NATURAL GAS ENGINE DRIVES

McPHILLIPS PUMPING STATIONS

BID OPPORTUNITY NO. 747-2008

DRAWING LIST

City Dwg. No.	Description
1-0640M-M0001-001	MECHANICAL - GENERAL NOTES AND LEGEND
1-0640M-M0002-001	MECHANICAL - DEMOLITION PUMP/ENGINE LEVEL FLOOR PLAN
1-0640M-M0003-001	MECHANICAL - P1, P3, & P5 ENGINE EXHAUST SECTIONS AND DETAILS
1-0640M-M0004-001	MECHANICAL - MISCELLANEOUS DETAILS AND SECTIONS

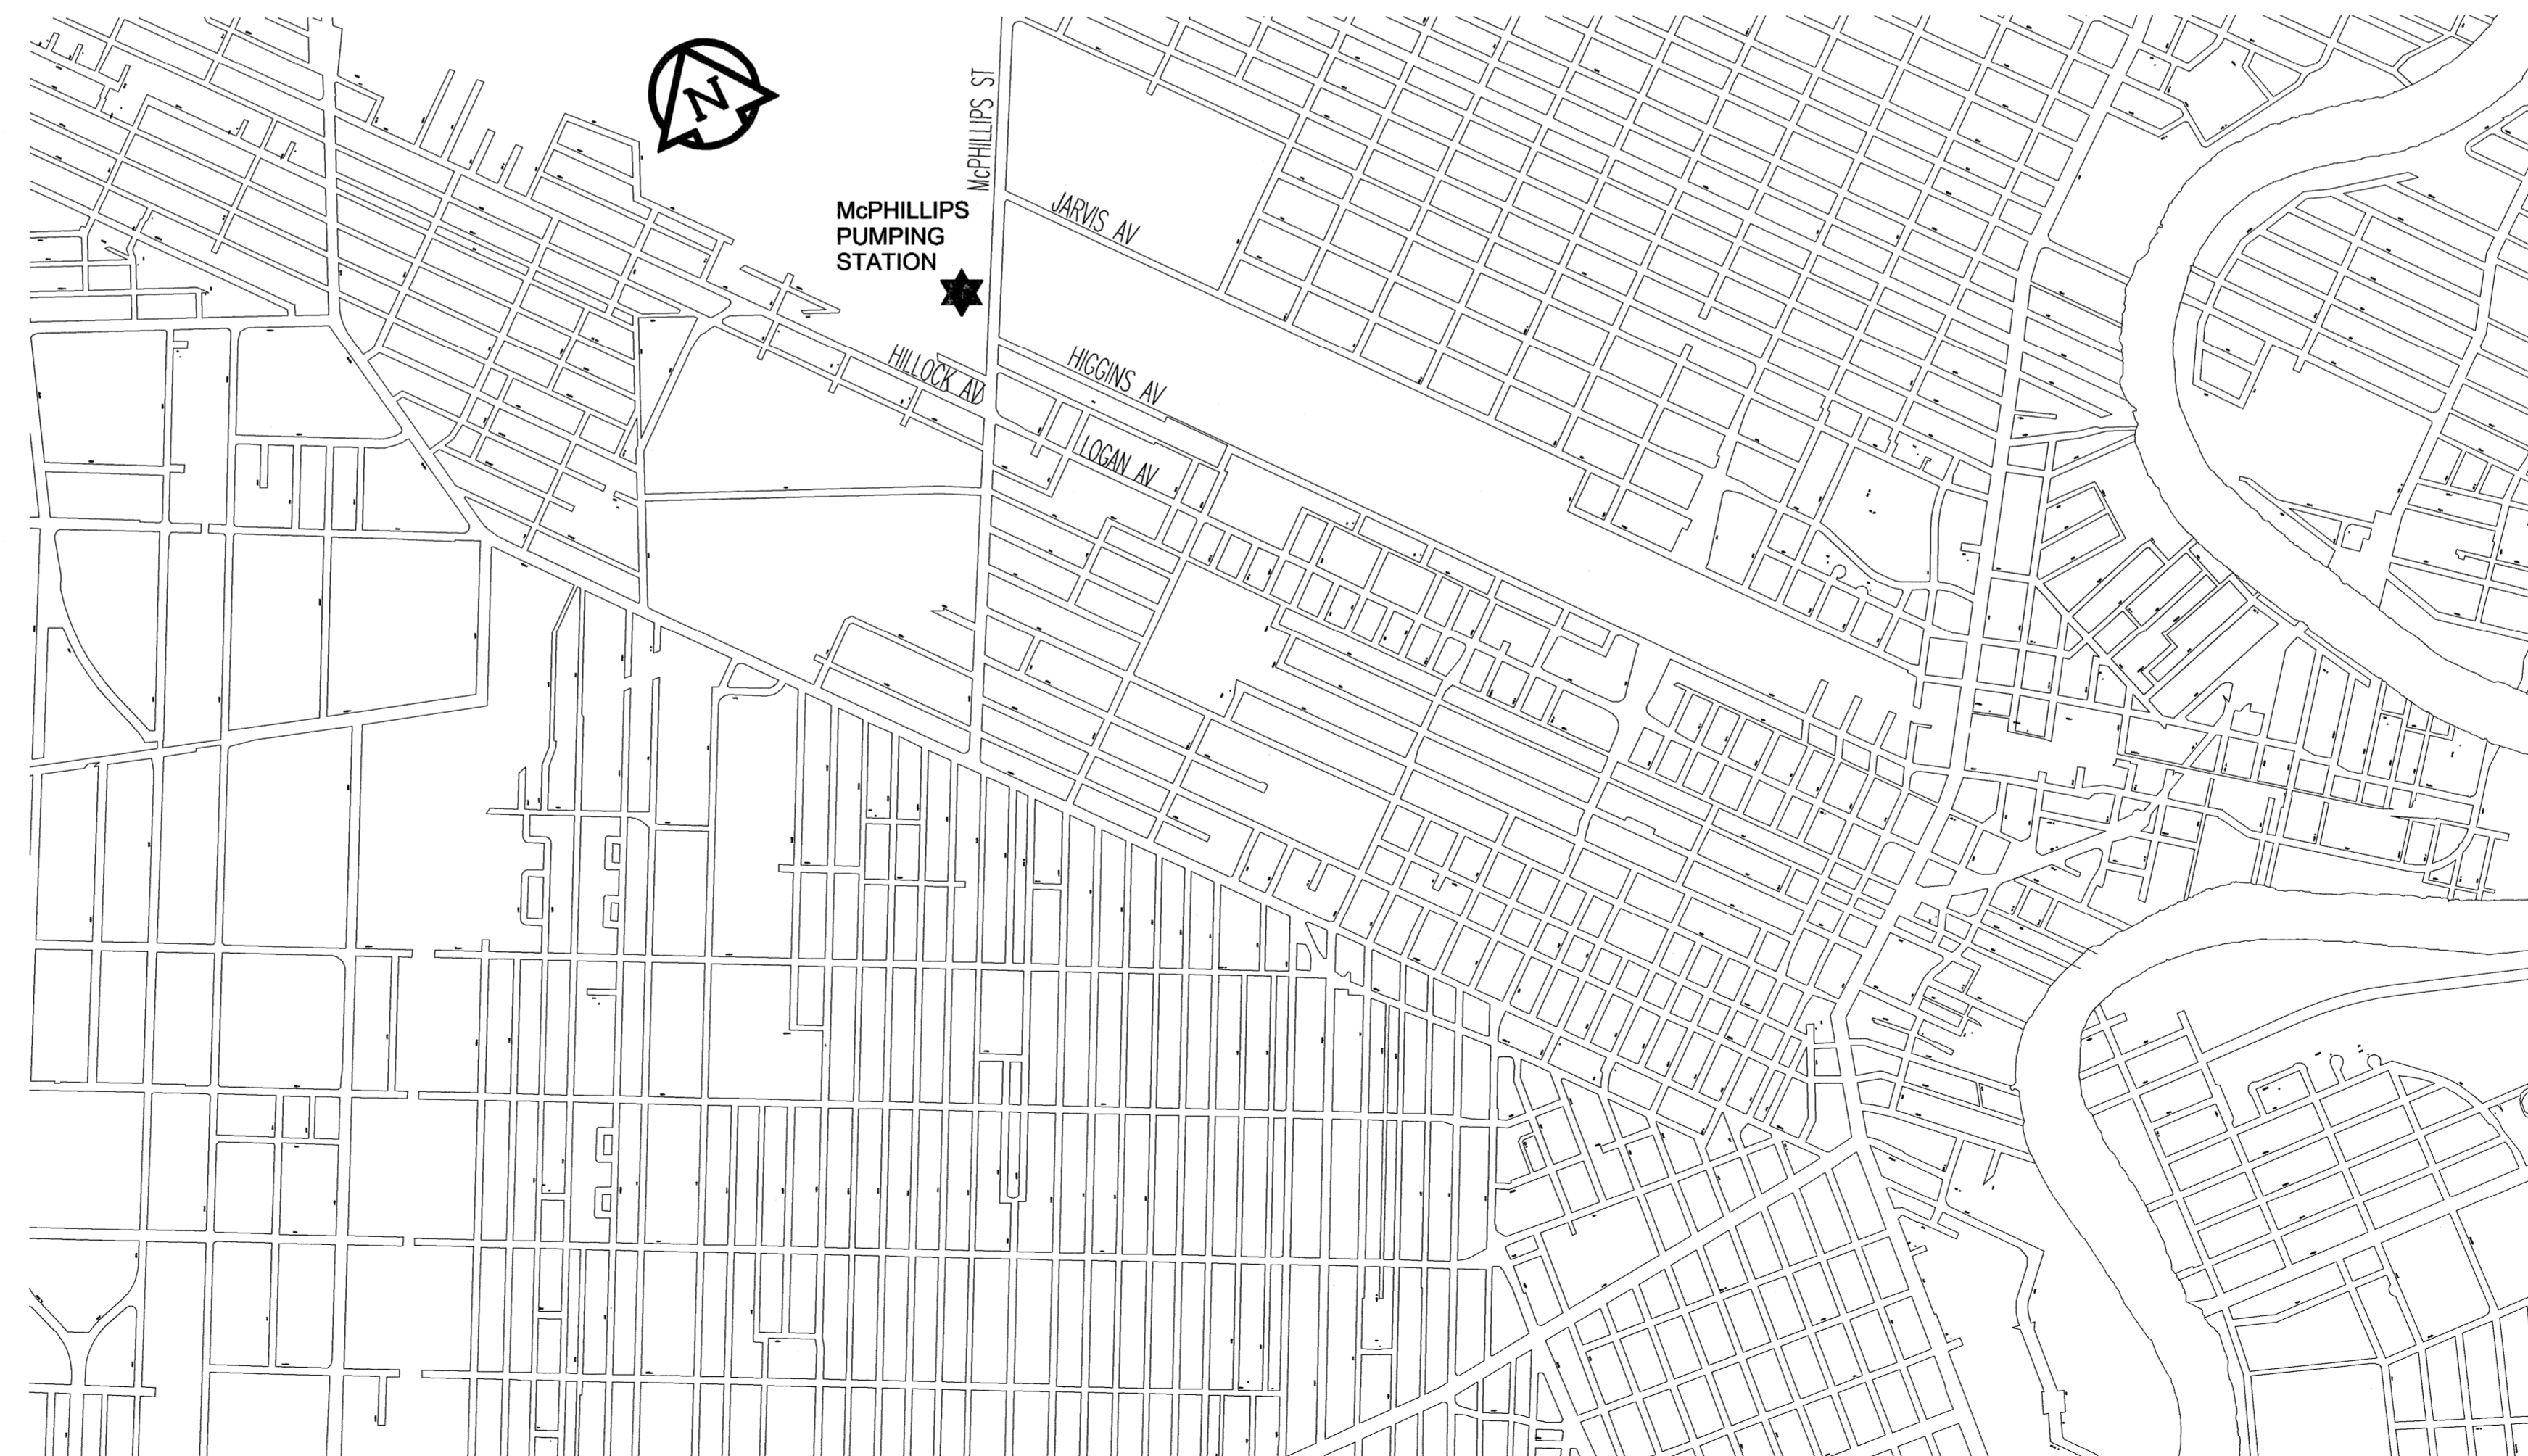

ISSUED FOR BID
2008/11/21