


B PARTIAL DBPS FLOOR PLAN
SCALE: NTS

A PARTIAL SITE PLAN
SCALE: 1 : 750

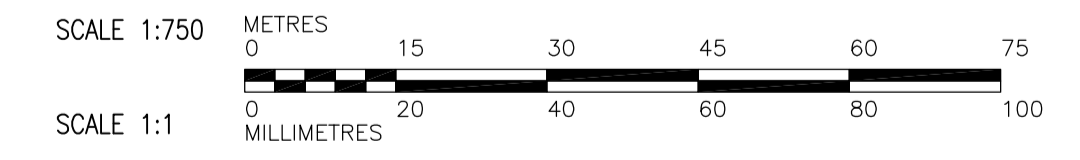

| | | | | | | | | |
|--|------------------|---------------------------------------|--|---|--|---|---------------------------------|-------------------------|
| Certificate of Authorization AECOM Canada Ltd. No. 4671 Date: 2009/02/27 | B.M. ELEV. | Frederickson Cooper ARCHITECTS | | ENGINEER'S SEAL | THE CITY OF WINNIPEG WATER AND WASTE DEPARTMENT ENGINEERING DIVISION | WATER TREATMENT PLANT SITE PLAN TELEPHONE AND DATA INSTALLATION | CITY FILE NUMBER | |
| | DESIGNED BY: ERC | | | CHECKED BY: BLM | | | ORIGINAL SIGNED BY: B.L. MOORE | SHEET OF |
| | DRAWN BY: ERC | | | APPROVED BY: SRB | | | 2009/02/27 | CITY DRAWING NUMBER |
| | SCALE: AS SHOWN | | | RELEASED FOR CONSTRUCTION BY: R. SOROKOWSKI | | | CONSULTANT DRAWING NO. WM-E0600 | 1-0601A-M-E0600-001-01D |
| 01 ISSUED FOR ADDENDUM 1 09/03/23 ERC | DATE 2008/11/15 | DATE 2009/02/27 | | | | | | |
| 0 ISSUED FOR TENDER 09/02/27 ERC | | | | | | | | |
| NO. REVISIONS | DATE | BY | | | | | | |