


PLAN
 SCALE 1:100
 0 1000 2000 3000 mm

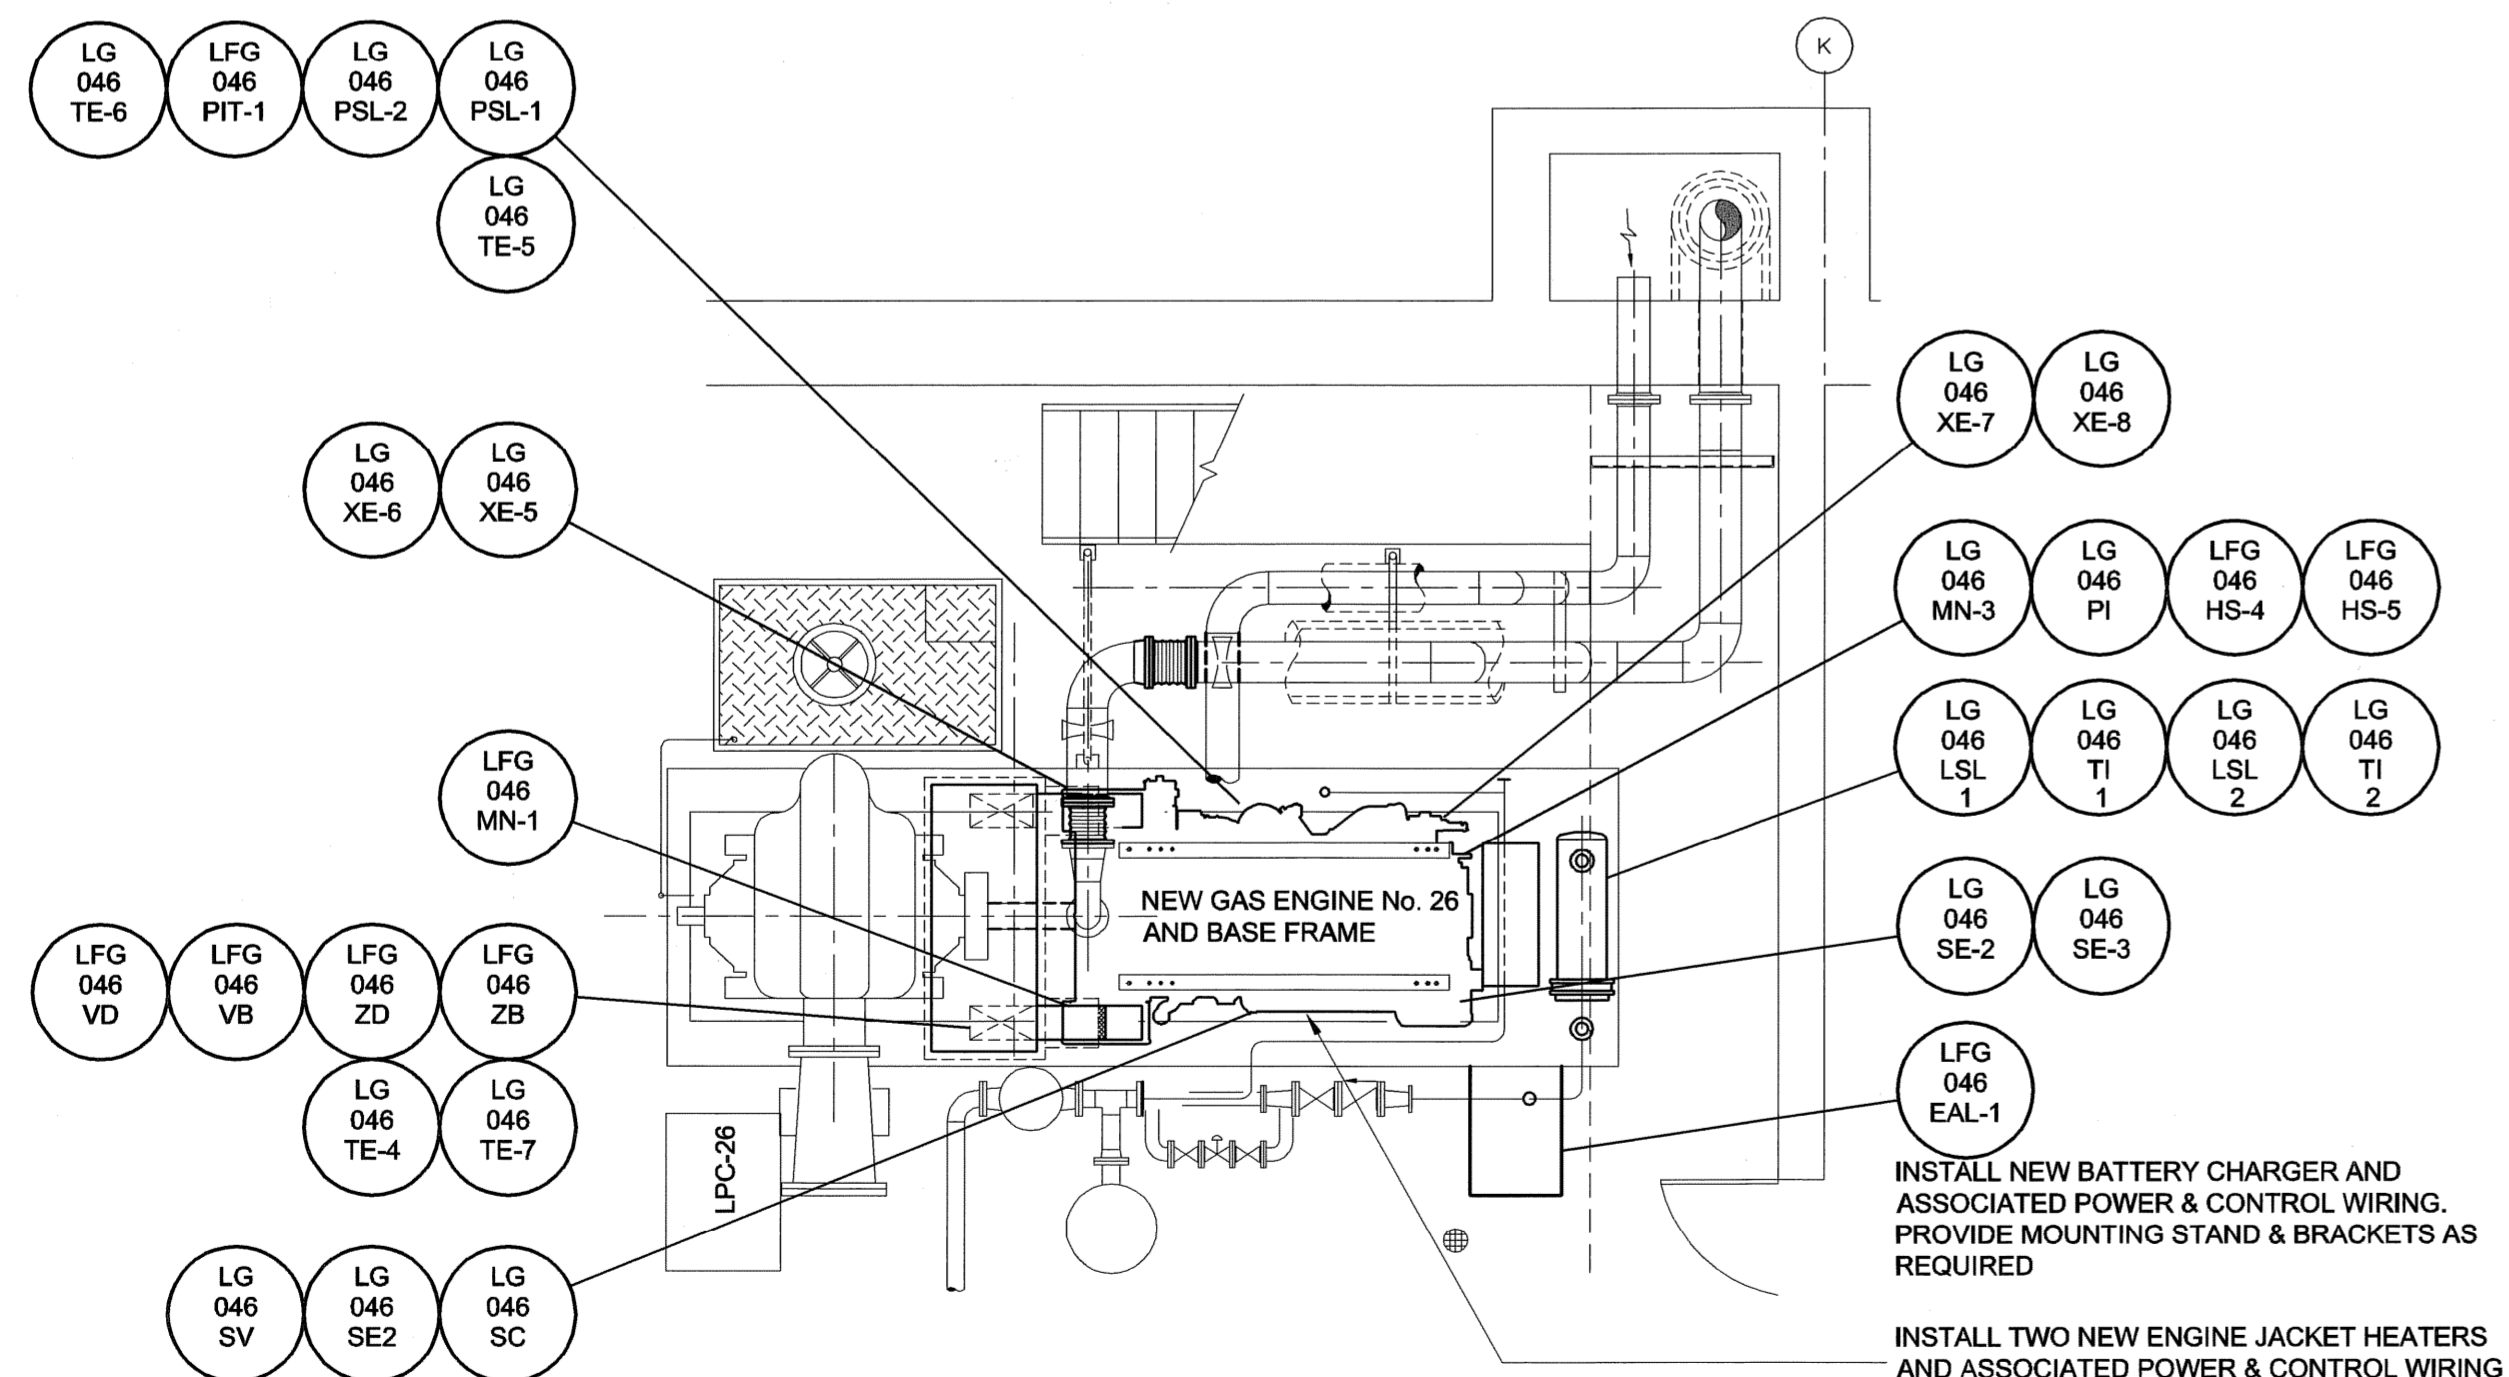

DETAIL P-26
 SCALE 1:50
 0 500 1000 1500 mm

APEGM
 Certificate of Authorization
 UMA Engineering Ltd. (MB)
 No. 256 Date: Nov 24/08

DRN	CHK	DES	ENG	IDR
UMA REVIEW				

NO.	REVISIONS	DATE	BY
B	ISSUED FOR BID	08/11/21	QL
A	ISSUED FOR REVIEW	08/10/28	QL
		YYMMDD	

DESIGNED BY	KM	CHECKED BY	
DRAWN BY	QL	APPROVED BY	
HOR. SCALE	NTS	RELEASED FOR CONSTRUCTION	
VERT. SCALE	NTS		
DATE		DATE	

PROFESSIONAL'S SEAL
 PROVINCE OF MANITOBA
 Nov 24/08
 B. L. MOORE
 REGISTERED PROFESSIONAL ENGINEER
 CONSULTANT DRAWING NO.
 D265-199-00_02-E-0002_RX.dwg

THE CITY OF WINNIPEG
WATER AND WASTE DEPARTMENT

G. C. MACLEAN PUMPING STATION
P-26 ENGINE REPLACEMENT
ELECTRICAL - NEW CONSTRUCTION
PUMP/ENGINE LEVEL FLOOR PLAN

SHEET 1 OF 1
 CITY DRAWING NUMBER
 1-0630M-E0011-001
 REV B