



THE CITY OF WINNIPEG

WATER AND WASTE DEPARTMENT


G.C. MacLEAN PUMPING STATION

P-26 ENGINE REPLACEMENT

BID OPPORTUNITY NO. 839-2008

DRAWING LIST

City Dwg. No.	Description
1-0630M-S0001-001	CONCRETE BASE - PLAN AND SECTION
1-0630M-M0001-001	MECHANICAL - LEGEND AND GENERAL NOTES
1-0630M-M0002-001	MECHANICAL - DEMOLITION - PUMP/ENGINE LEVEL FLOOR PLAN
1-0630M-M0003-001	MECHANICAL - DEMOLITION PUMP/ENGINE - SECTIONS
1-0630M-M0004-001	MECHANICAL - NEW CONSTRUCTION - PUMP/ENGINE - PLAN AND SECTION
1-0630M-M0005-001	MECHANICAL - NEW CONSTRUCTION PUMP/ENGINE - PIPING AND SUPPORT DETAILS
1-0630M-M0006-001	MECHANICAL - EXHAUST PIPING AND SUPPORTS - PLAN AND DETAILS
1-0630M-M0007-001	MECHANICAL - PIPE INSULATION AND GUIDE BRACKETS - DETAILS AND SECTION
1-0630M-E0010-001	ELECTRICAL - DEMOLITION PUMP/ENGINE - LEVEL FLOOR PLAN
1-0630M-E0011-001	ELECTRICAL - NEW CONSTRUCTION - PUMP/ENGINE LEVEL FLOOR PLAN
1-0630M-A0028-001	PROCESS AND INSTRUMENTATION DIAGRAMS - SYMBOLS LEGEND
1-0630M-A0028-002	PROCESS AND INSTRUMENTATION DIAGRAMS - SYMBOLS LEGEND
1-0630M-A0028-003	PROCESS AND INSTRUMENTATION DIAGRAMS - SYMBOLS LEGEND
1-0630M-A0029-001	INSTRUMENTATION - LOOP DIAGRAMS
1-0630M-P0001-001	PROCESS AND INSTRUMENTATION - DIAGRAM

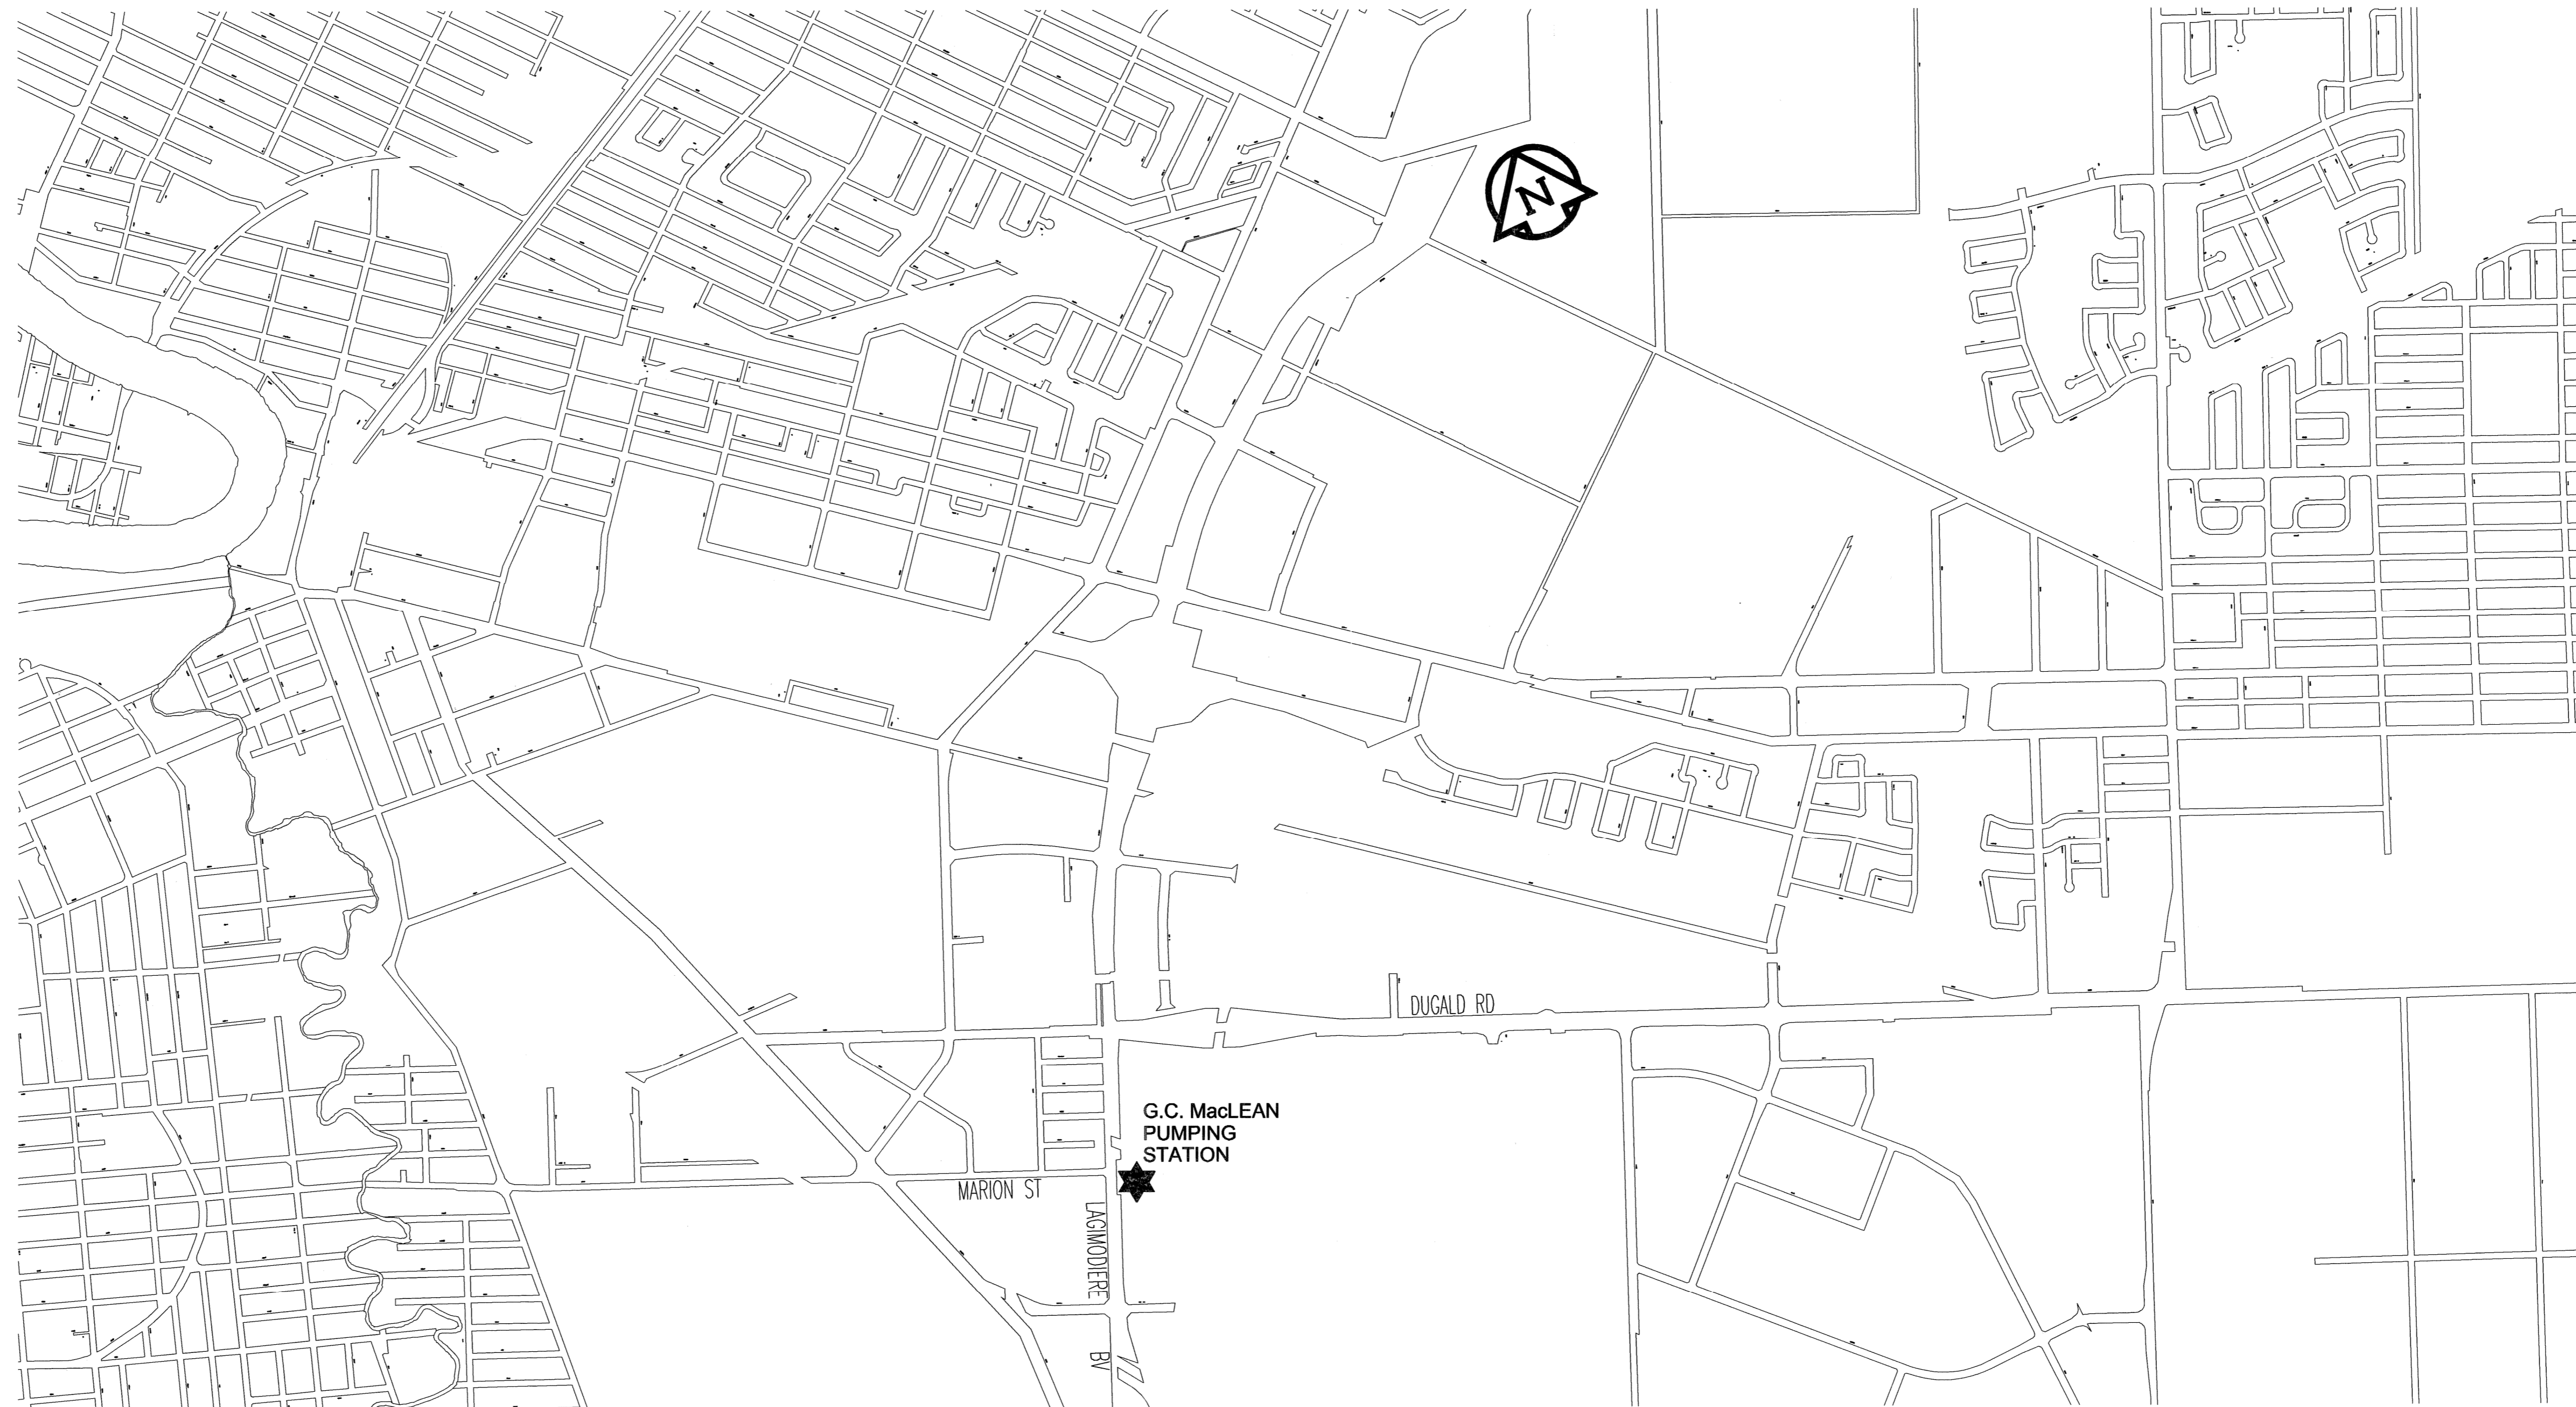

ISSUED FOR BID
2008/11/21