



1 SPRINKLER SYSTEM SCHEMATIC RISER DIAGRAM - ELECTRICAL
 E3.0 SCALE: NTS

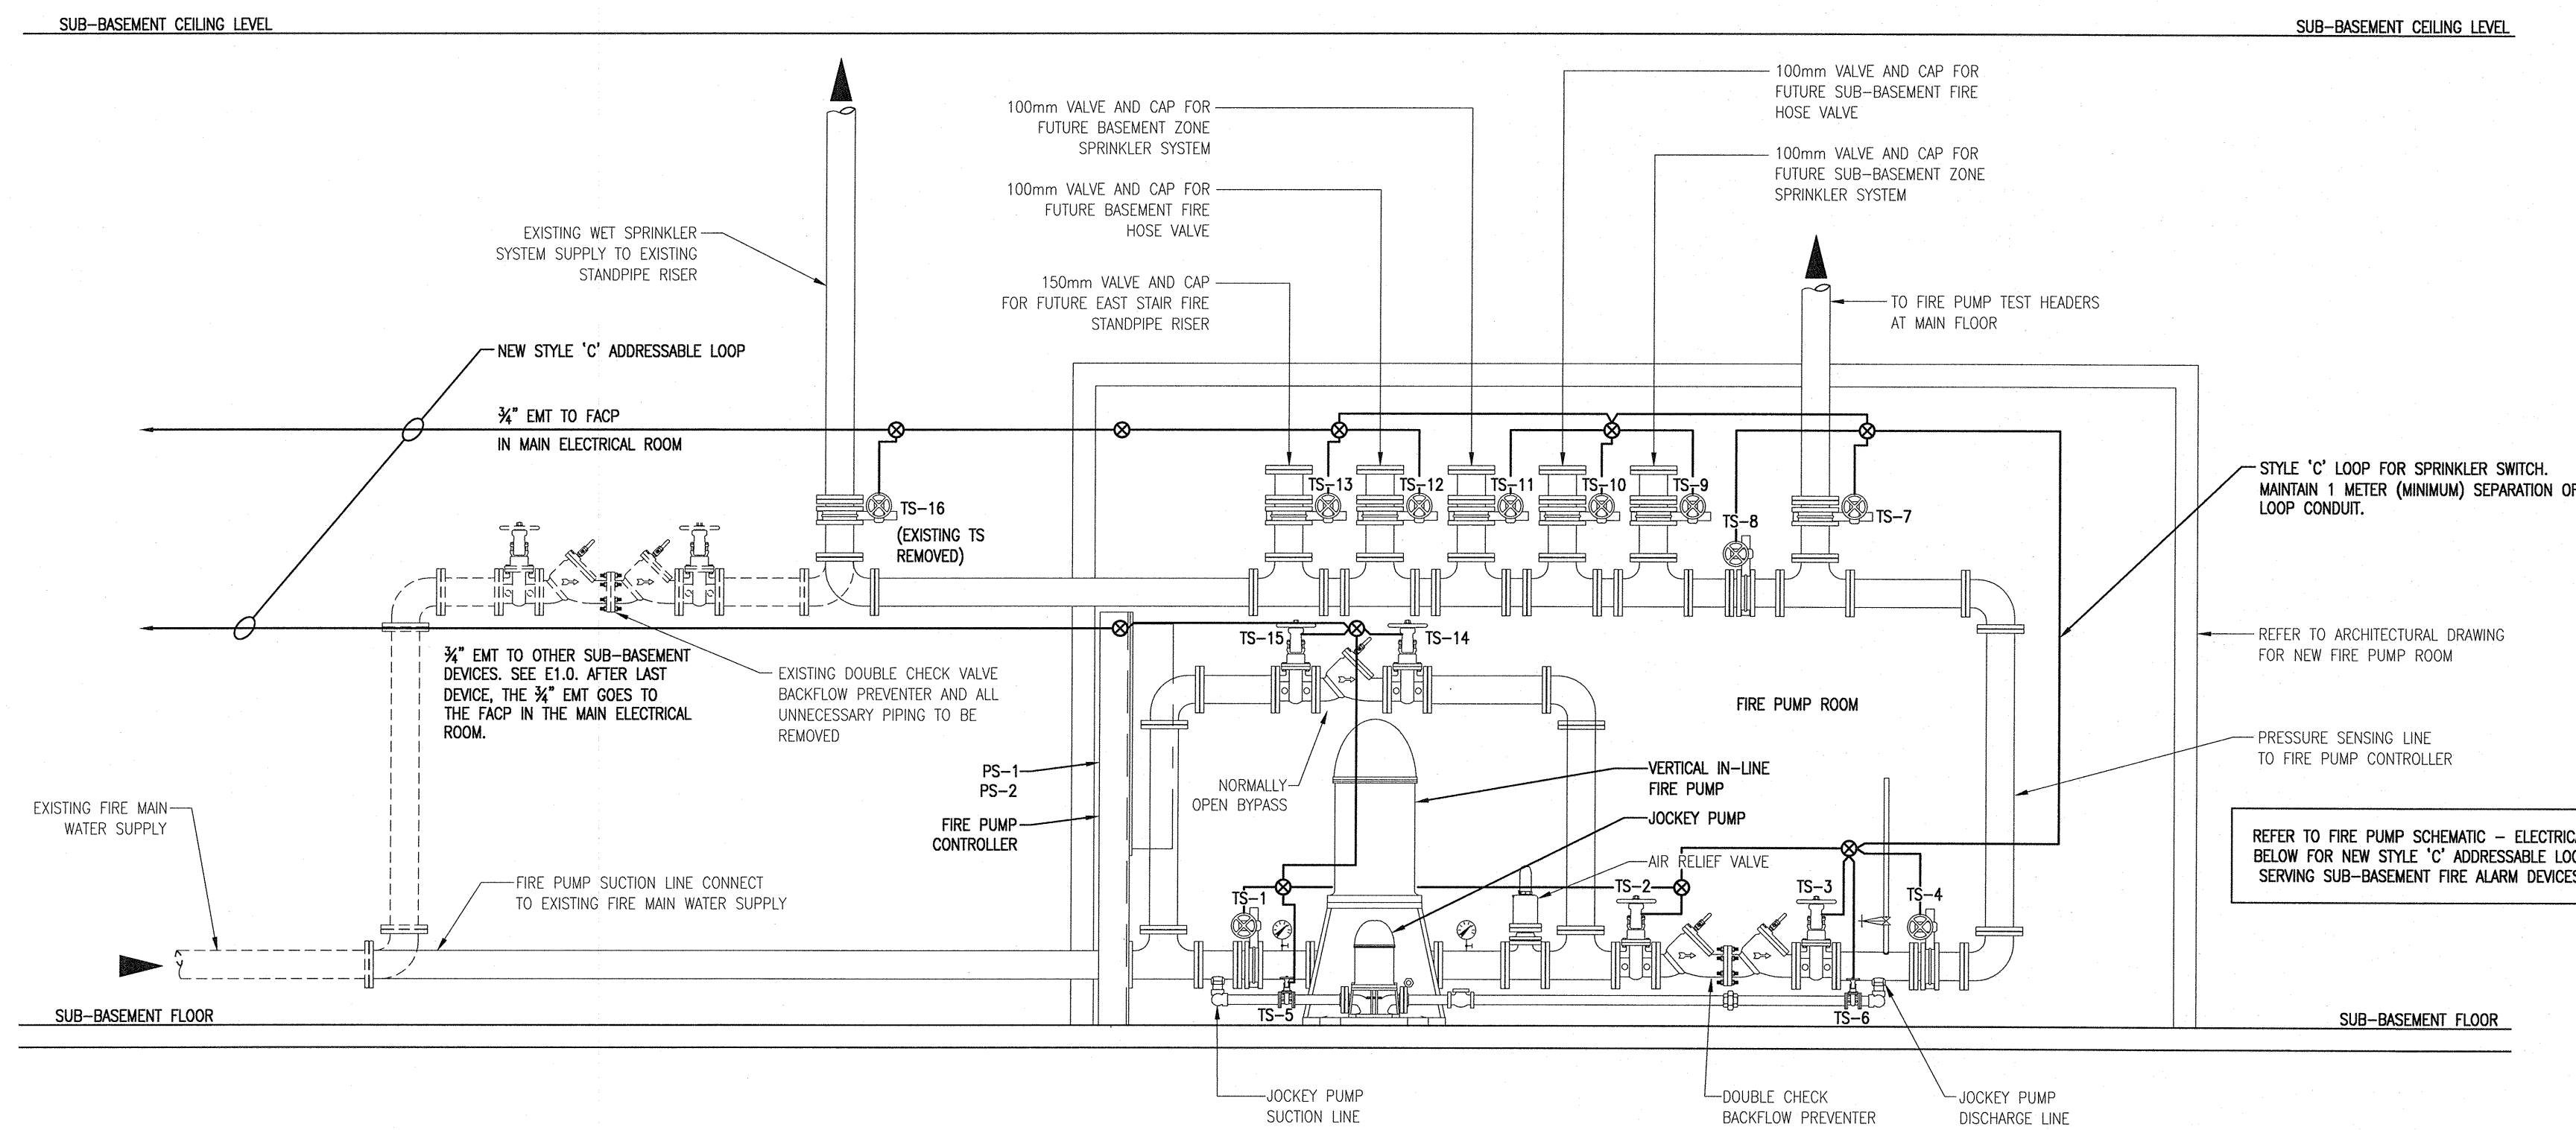

2 FIRE PUMP SCHEMATIC - ELECTRICAL (REFER TO PLAN ON E1.0)
 E3.0 SCALE: NTS

1	ISSUED FOR BID OPPORTUNITY	BL 13/04/09
NO.	REVISION/DESCRIPTION	BY DATE

SEALS

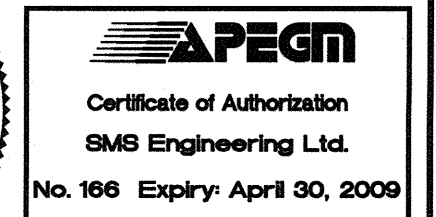

DRAWN BY KAM	CHECKED BY CB	APPROVED BDL
DATE 2006.01.16	USER APPROVAL	

CITY OF WINNIPEG
 PLANNING, PROPERTY &
 DEVELOPMENT DEPARTMENT
 CIVIC ACCOMMODATIONS DIVISION
 300 - 65 GARRY ST. R3C 4K4

PROJECT
HALON SYSTEM REPLACEMENT
 510 MAIN STREET

510 MAIN STREET

SHEET TITLE

PART MAIN FLOOR PLAN - FIRE PROTECTION
 SPRINKLER SYSTEM SCHEMATIC
 RISER DIAGRAM - ELECTRICAL

SMS ENGINEERING
 770 BROADVIEW STREET WINNIPEG MB CANADA R3M 0N3
 Telephone 204.775.0291 Fax 204.772.2153
 sms@smseng.com

SCALE AS SHOWN	PROJECT NO. 07-176-02	SHEET NO. E3.0
----------------	-----------------------	----------------