


FILE NAME: 0717601-FP-1.dwg  
 DATE:  
 DESCRIPTION: SEVENTH FLOOR HALON REPLACEMENT  
 PROJECT No: 07-176-02  
 ADDRESS: 510 MAIN STREET


NOTES :

**DRAWING NOTES**


- PIPE DOWN TO NEW FIRE PUMP IN SUB-BASEMENT MECHANICAL ROOM.
- FIRE PUMP TEST HEADER C/W 2-65mm HOSE VALVES WITH CAP AND CHAIN.
- MODIFY EXISTING WROUGHT IRON FENCE TO ACCOMMODATE TEST HEADER. SECURE TEST HEADER TO EXISTING WALLS AND FENCING.

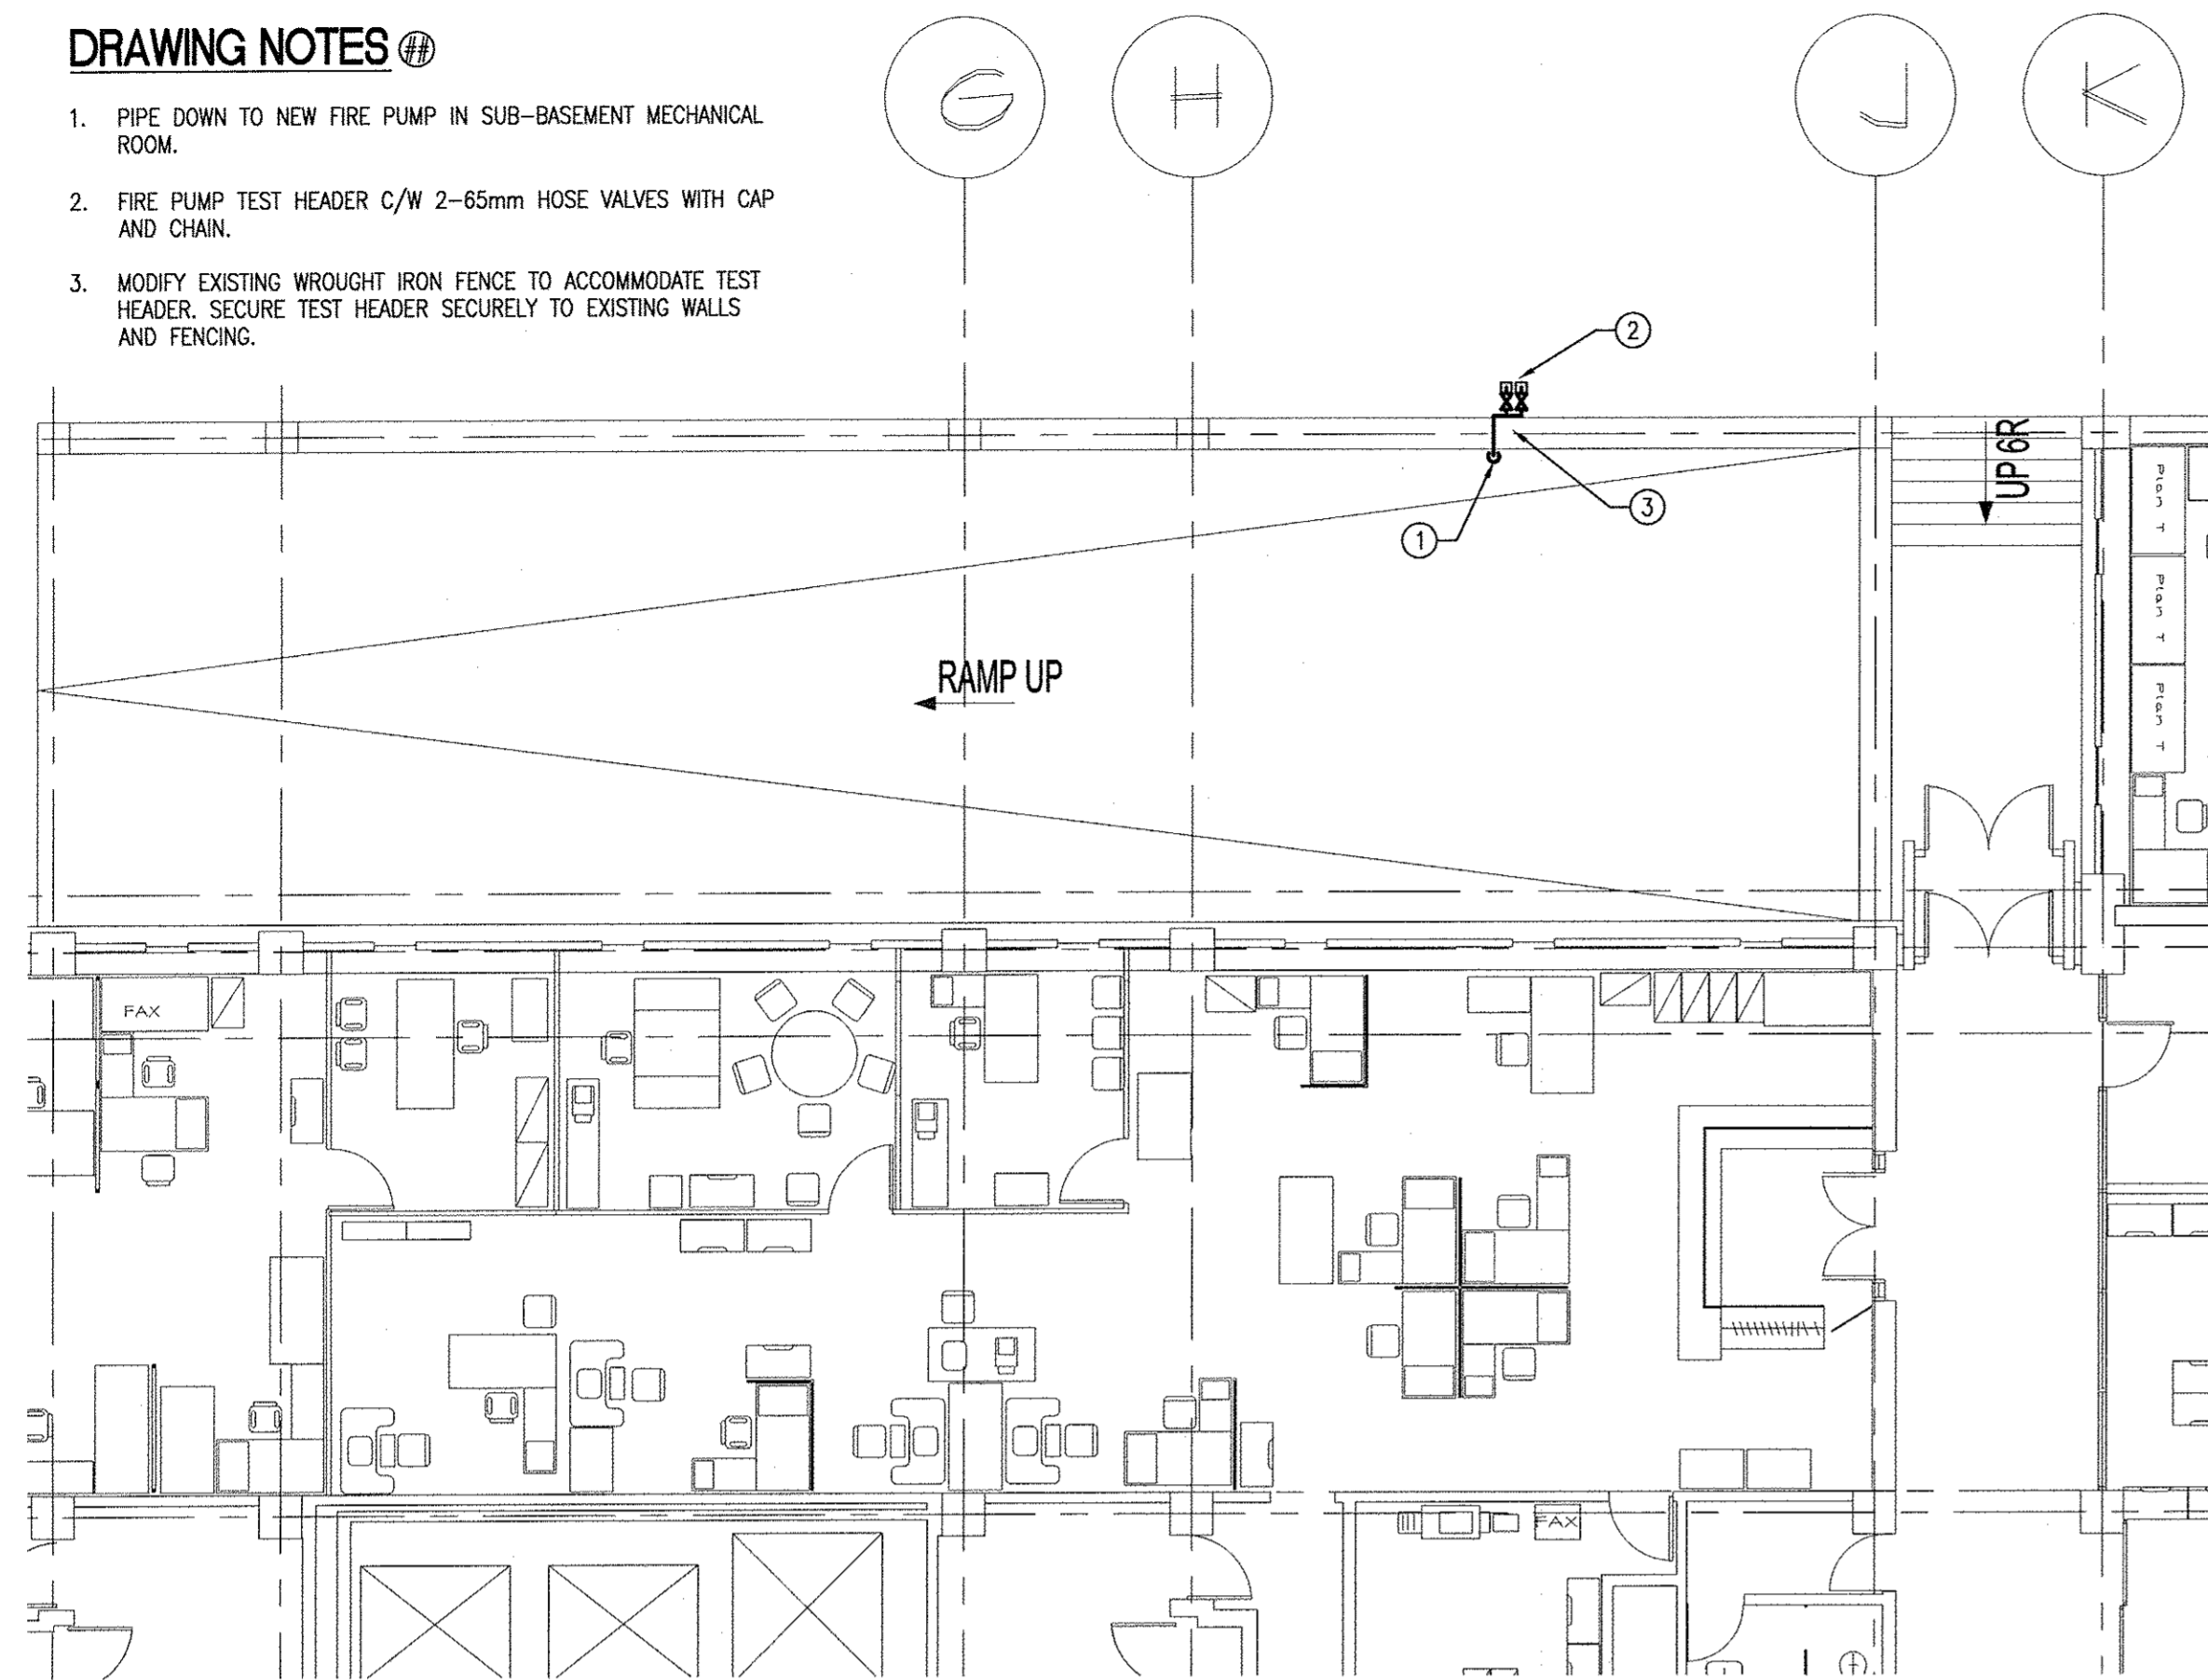

**1 PART MAIN FLOOR PLAN - FIRE PROTECTION**  
 FP-3 SCALE: 1:100

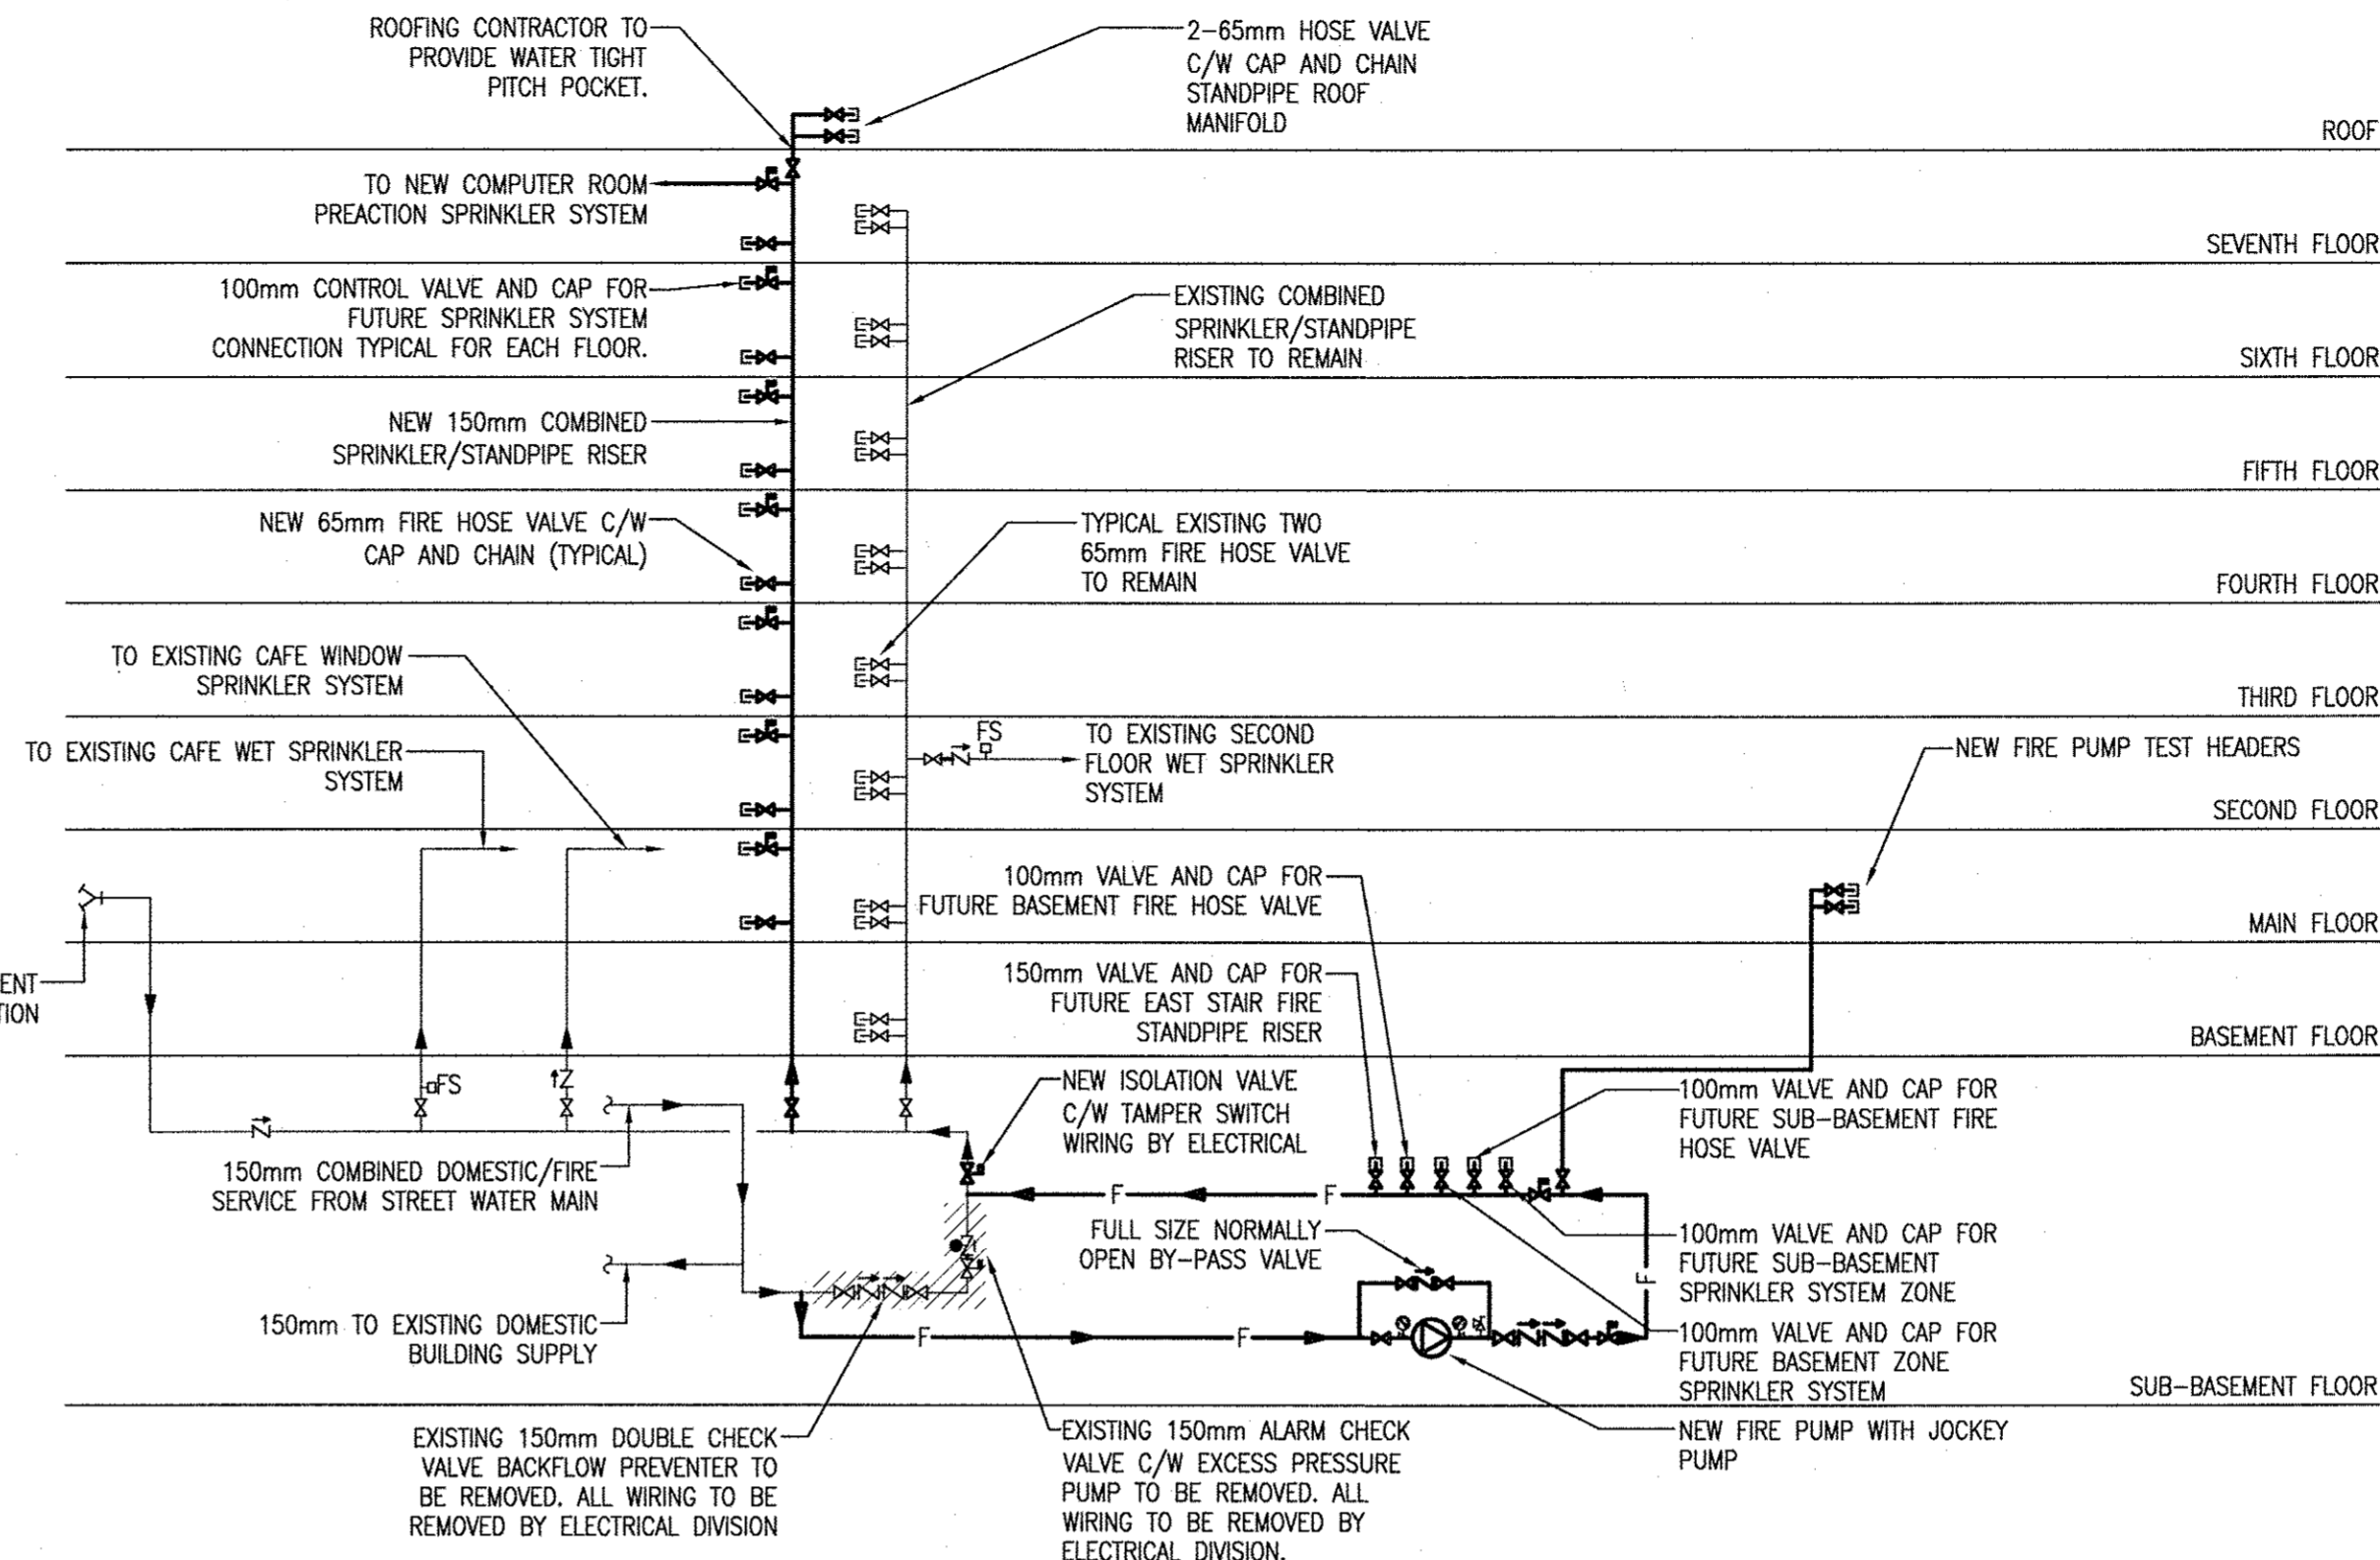


**2 SPRINKLER SYSTEM SCHEMATIC RISER DIAGRAM**  
 FP-3 SCALE: NOT TO SCALE

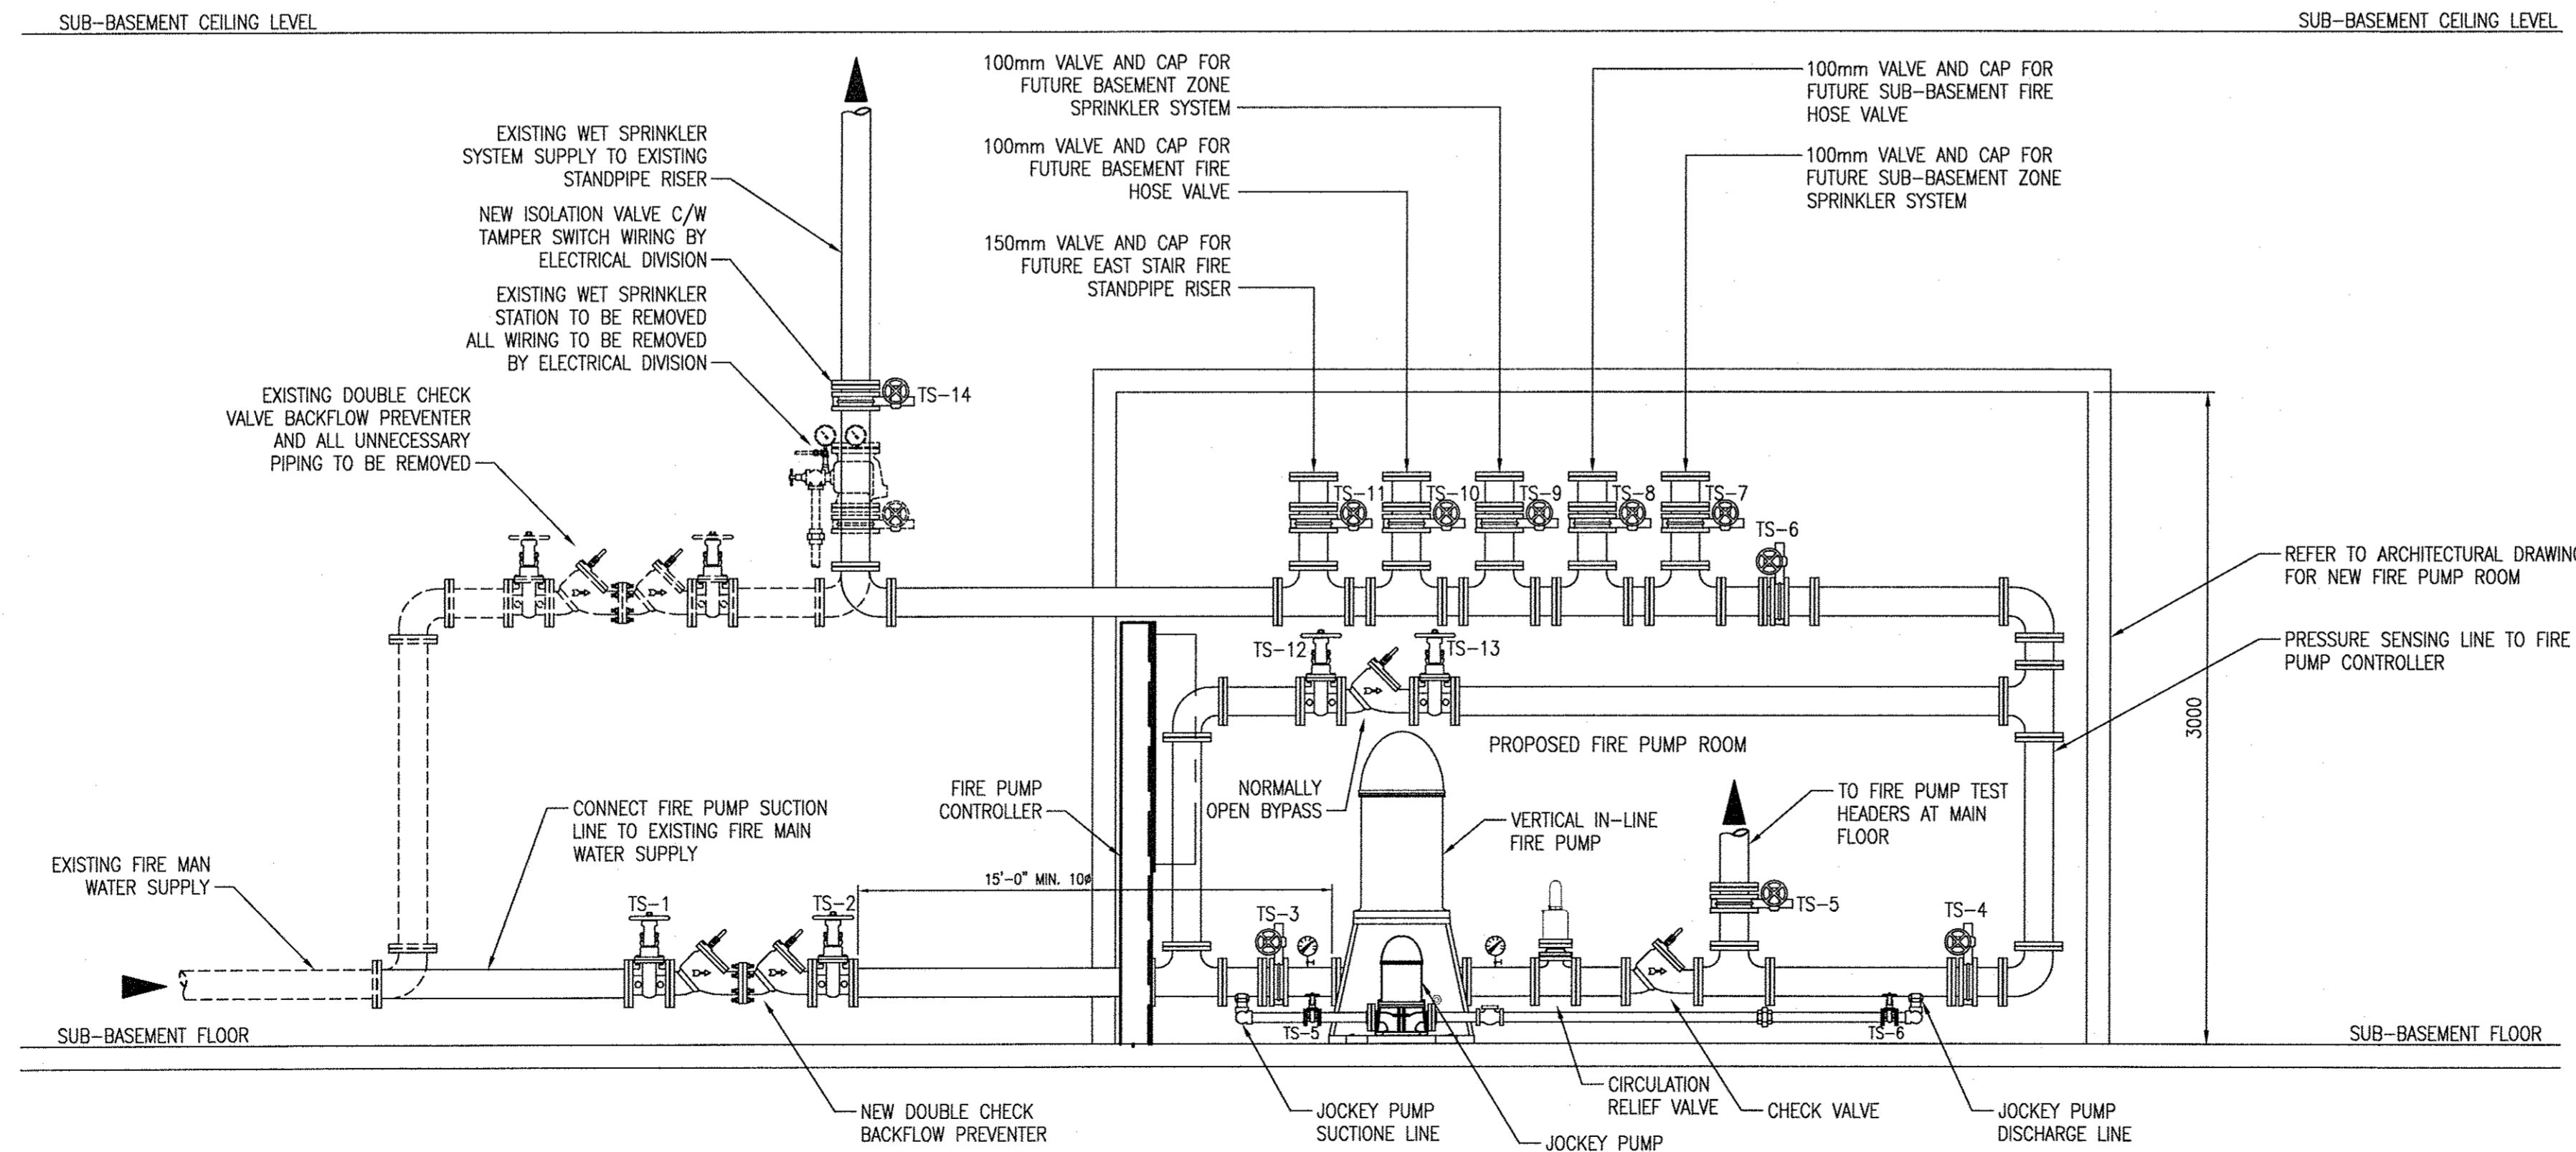

**3 FIRE PUMP ROOM SECTION**  
 FP-3 SCALE: 1:30

1	ISSUED FOR BID OPPORTUNITY	SW	3/29/09
NO.	REVISION/DESCRIPTION	BY	DATE

SEALS

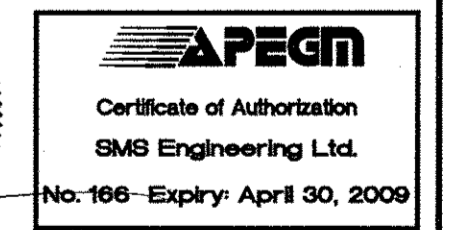

DRAWN BY	RRRMS	CHECKED BY	GO	APPROVED	VSW
DATE	2006.01.16	USER APPROVAL			

CITY OF WINNIPEG  
 PLANNING, PROPERTY &  
 DEVELOPMENT DEPARTMENT  
 CIVIC ACCOMMODATIONS DIVISION  
 300 - 65 GARRY ST. R3C 4K4

PROJECT  
 CITY OF WINNIPEG  
 HALON SYSTEM REPLACEMENT  
 510 MAIN STREET  
 510 MAIN STREET

SHEET TITLE  
 PART MAIN FLOOR PLAN - FIRE PROTECTION  
 SPRINKLER SYSTEM SCHEMATIC  
 RISER DIAGRAM

**SMS ENGINEERING**

SMS Engineering Ltd. Consulting Engineers  
 770 Bradford Street Winnipeg MB Canada R3H 0N3  
 Telephone 204.775.0291 Fax 204.772.2153  
 sms@smseng.com

SCALE	PROJECT NO.	SHEET NO.
1:100	07-176-02	FP-3

DRAWING SHEET SIZE: A1 (841mm x 594mm) PLOT 1:1