



1 WALL SECTION DETAIL
A5 Scale 1:10

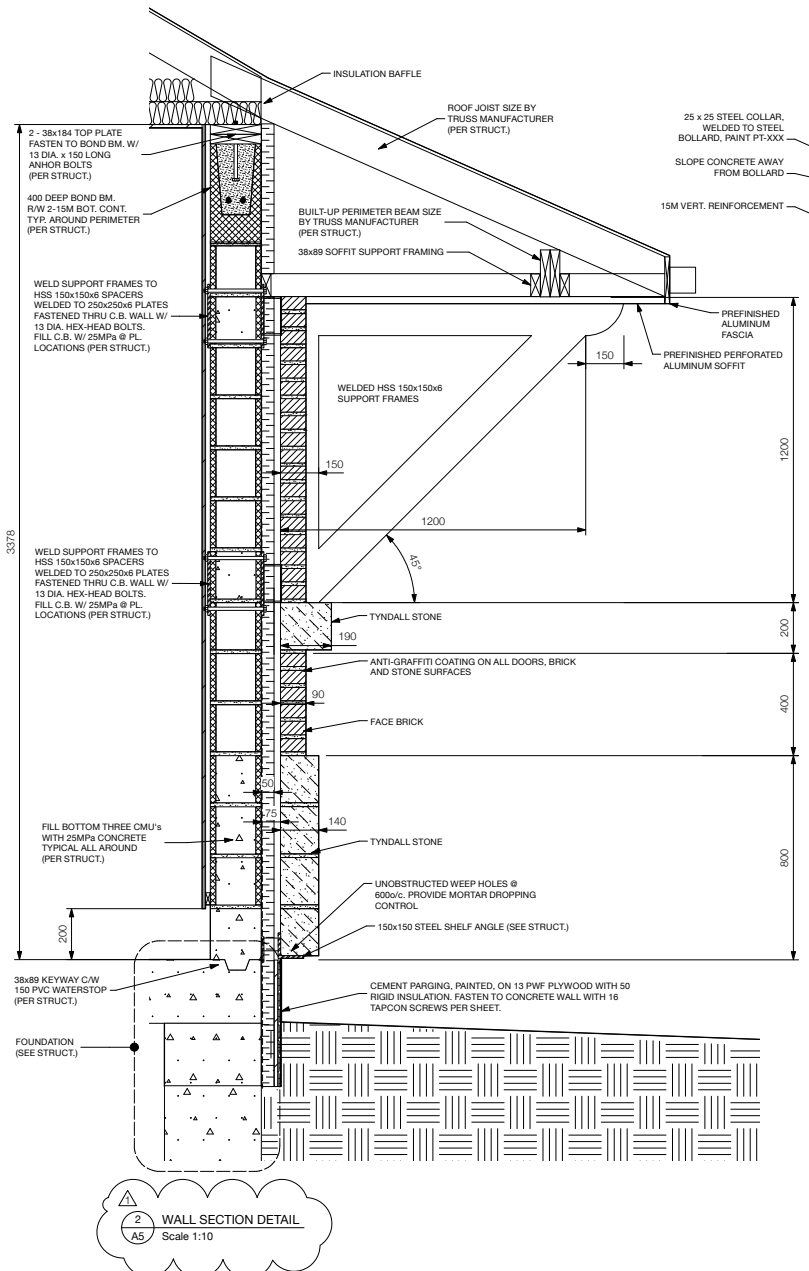

2 WALL SECTION DETAIL
A5 Scale 1:10

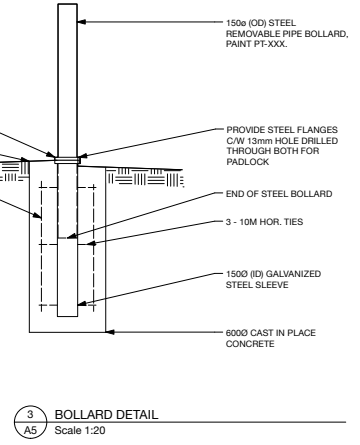

3 BOLLARD DETAIL
A5 Scale 1:20

1 WALL SECTION DETAIL
A5 Scale 1:10

A-B
C A = DETAIL/SECTION No.
B = DRAWING WHERE SHOWN
C = DRAWING WHERE TAKEN

<p>SYVERSON MONTEYNE ARCHITECTURE</p> <p>www.sm-arc.com 2-204-947-3155 / 5204-947-3181 607-70 Arthur St Winnipeg, MB</p>			<p>ARCHITECTS SEAL</p>		<p>THE CITY OF WINNIPEG WATER AND WASTE DEPARTMENT</p> <p>Winnipeg</p>		<p>CONSULTANT DRAWING NUMBER A5.0</p> <p>SHEET 5 OF 14</p>	
<p>DESIGNED BY: DSy</p> <p>CHECKED BY: EN</p>		<p>APPROVED BY: DSy</p> <p>signed by K. Zurek</p>		<p>REHABILITATION OF BOURNAIS WASTEWATER PUMPING STATION</p> <p>WALL SECTIONS AND DETAILS</p>		<p>CITY DRAWING NUMBER 8750</p>		
<p>1 ISSUED FOR ADDENDUM NO. 3 21.04.09 EN</p>		<p>DATE 2008 12 11</p>		<p>DATE 2009 03 27</p>		<p>BID OPPORTUNITY 901 - 2008</p> <p>PLOT DATE: 2009 03 26</p>		