

PROPERTY LIMITS DELINEATION
 DELINEATION OF PROPERTY LIMITS AS SHOWN ON THIS DWG DOES NOT REPRESENT A "LEGAL SURVEY". KGS GROUP MAKES NO REPRESENTATION OR WARRANTY AS TO THE ACCURACY OF PROPERTY LIMITS DELINEATED ON THIS DWG, NOR ON THE DIMENSIONAL ACCURACY OF DWG FEATURES RELATIVE TO THOSE PROPERTY LIMITS.



WARNING
 NOTIFY THE GAS COMPANY OF THE PROPOSED LOCATION OF EXCAVATION.
 TAKE PRECAUTION TO AVOID DAMAGE TO GAS COMPANY INSTALLATIONS.
 SEE PROVINCIAL REGULATION 210/72 FOR DETAILS.

LEGEND

- UWRL UNREGULATED WINTER RIVER LEVEL
- RSRL REGULATED SUMMER RIVER LEVEL
- 229— GEODETIC CONTOUR (m)
- TH08-01 TESTHOLE WITH INSTRUMENTATION BY KGS GROUP (NOVEMBER 2008) (SI-1) SLOPE INCLINOMETER #1 (PN-1) PNEUMATIC PIEZOMETER #1 (STP-1) STANDPIPE PIEZOMETER #1
- PROPERTY BOUNDARY

VERTICAL SCALE: 1:50 METRIC A1
 1:100 METRIC A3

HORIZONTAL SCALE: 1:250 METRIC A1
 1:500 METRIC A3

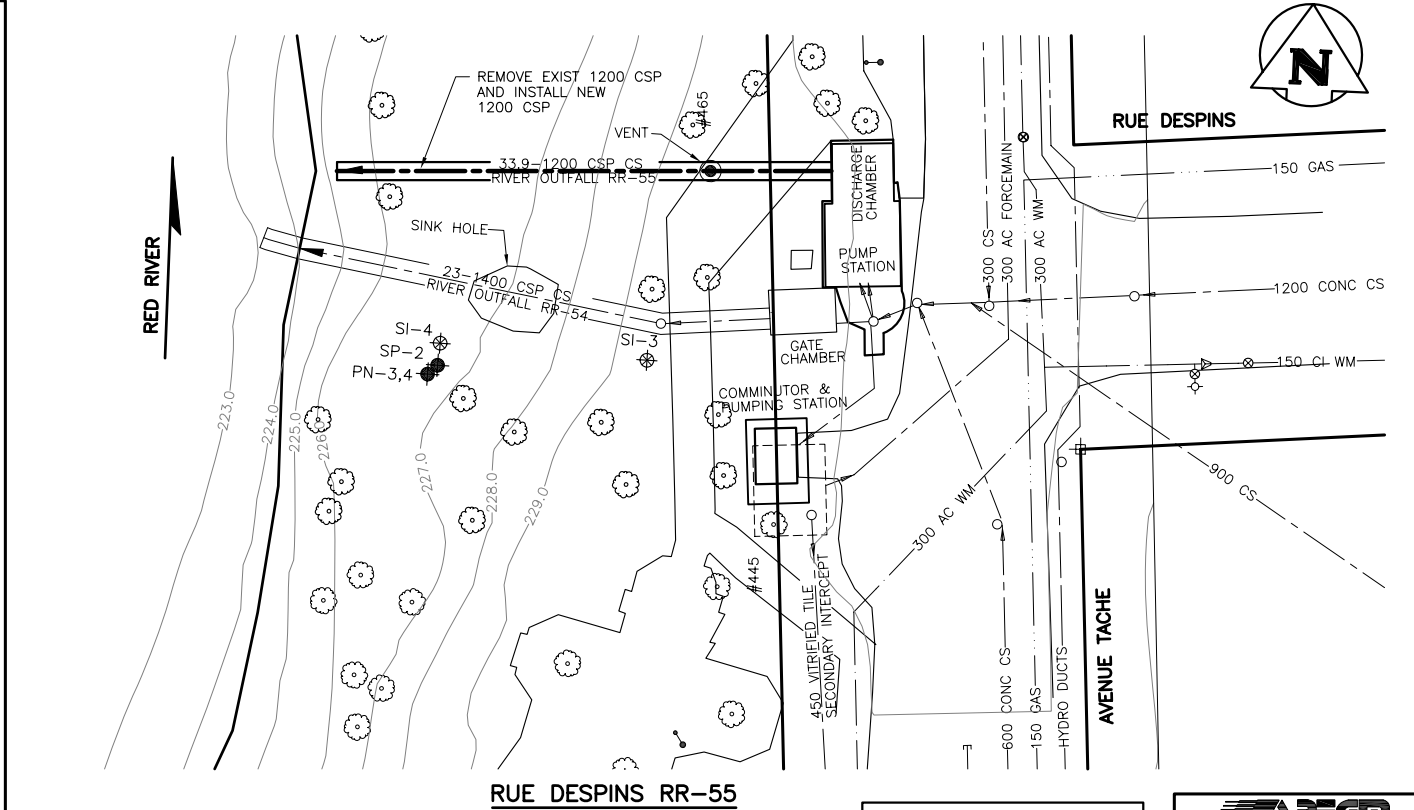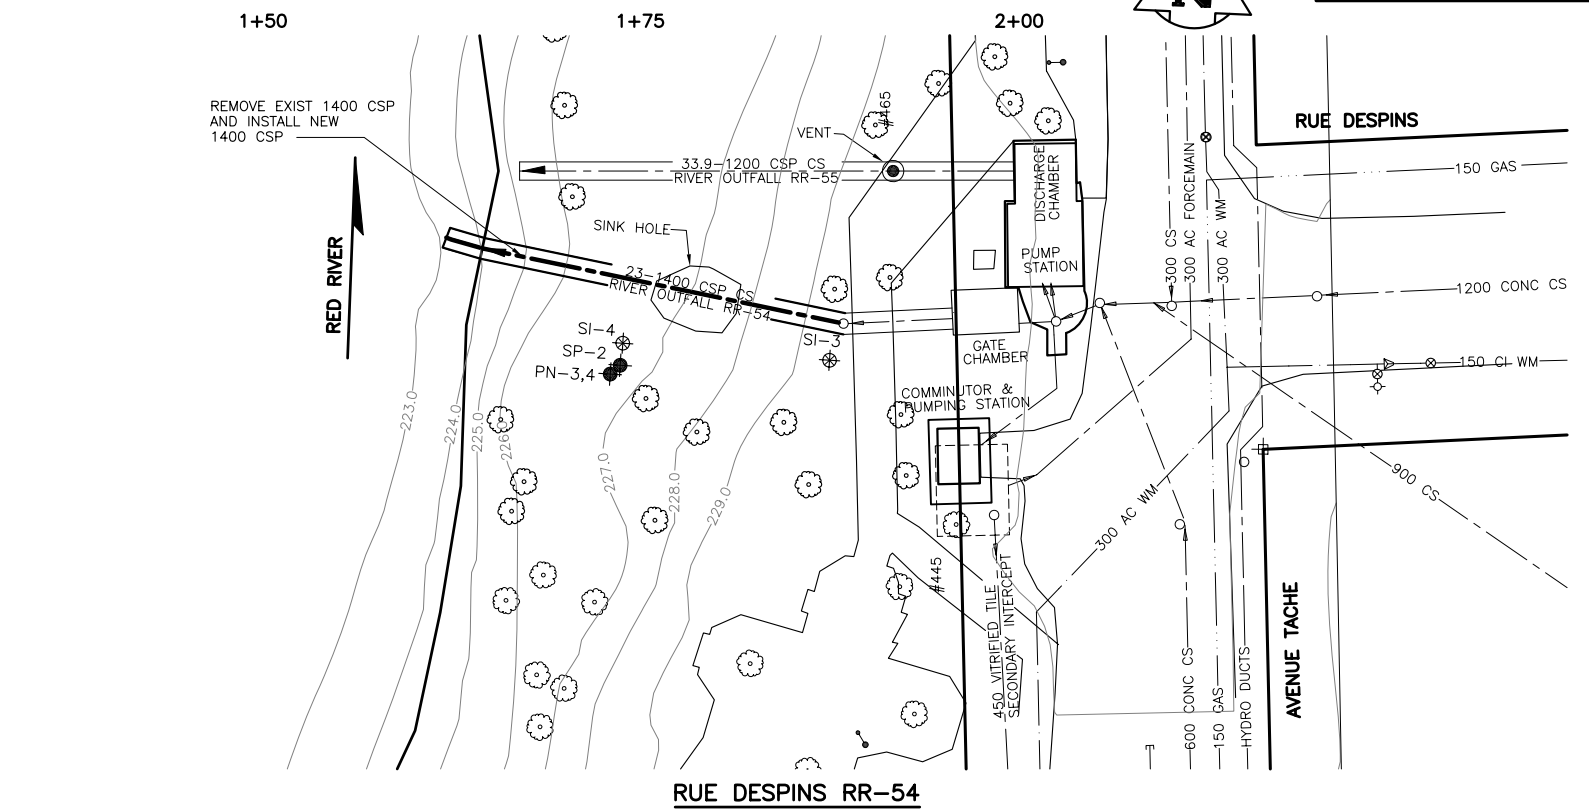

150 WM	WATERMAIN	150 WM	HYDRO	32.231		
Hydrant	HYDRANT	M.T.S.	M.T.S.			
Valve	VALVE	PROPERTY LINE	PROPERTY LINE			
300 L.D.S.	LAND DRAINAGE SEWER	300 L.D.S.	SURVEY BAR			
250 WWS	WASTE WATER SEWER	250 WWS	LIGHT STANDARD			
Manhole	MANHOLE	Hydro Pole	HYDRO POLE			
Catch Basin	CATCH BASIN	Guy Wire	GUY WIRE			
Curb Inlet	CURB INLET	Sign	SIGN			
Junctions	JUNCTIONS	Bush Line	BUSH LINE			
Culvert	CULVERT	Fence	FENCE			
Gas	GAS	Elevation	ELEVATION			
Existing	LEGEND-PLAN	Proposed	LEGEND-PLAN	Proposed	Existing	Legend-Profile

LOCATION APPROVED UNDERGROUND STRUCTURES

34-013
 ELEV. 230.472m

365 (604360) - E. SIDE TACHE AVE. N. OF RUE DESPINS, TRAIL 90' FROM CORNER, 30' IN N. OF ALL RAIL CROSSINGS & 0.90m IN. OF ALL OF TACHE AVE., 0.15mm IN. ON N. SIDE OF PILE TO LOCATE SAME.

KGS GROUP
 CONSULTING ENGINEERS & PROJECT MANAGERS
 WINNIPEG (204) 896-1209
 THUNDER BAY (807) 345-2233

DESIGNED BY: RJH
 CHECKED BY: RJH

DRAWN BY: DMW
 APPROVED BY:

HOR. SCALE: 1:250
 VERTICAL: 1:50

RELEASSED FOR CONSTRUCTION: DATE

ENGINEER'S SEAL

ORIGINAL SIGNED BY: R.J. HOUSTON
 16/12/08

CONSULTANT DRAWING NO. 08-0107-12_01

THE CITY OF WINNIPEG
 WATER & WASTE DEPARTMENT

2008 OUTFALL REPAIRS
 RUE DESPINS
 PLAN AND PROFILE
 OUTFALL (RR-54) AND
 OUTFALL (RR-55)

SHEET 01 OF 09
 CAD FILE DRAWING NUMBER RR-54-55 PLAN PROF
 CITY DRAWING NUMBER LD-5238

P:\PROJECTS\2008\08-0107-12\DWG\MUN\RR_54-55-PLAN-PROF.dwg
 PLOT 1:1 (A1)