



1 FLOOR PLAN (HIGH LEVEL) - VENTILATION
1:100

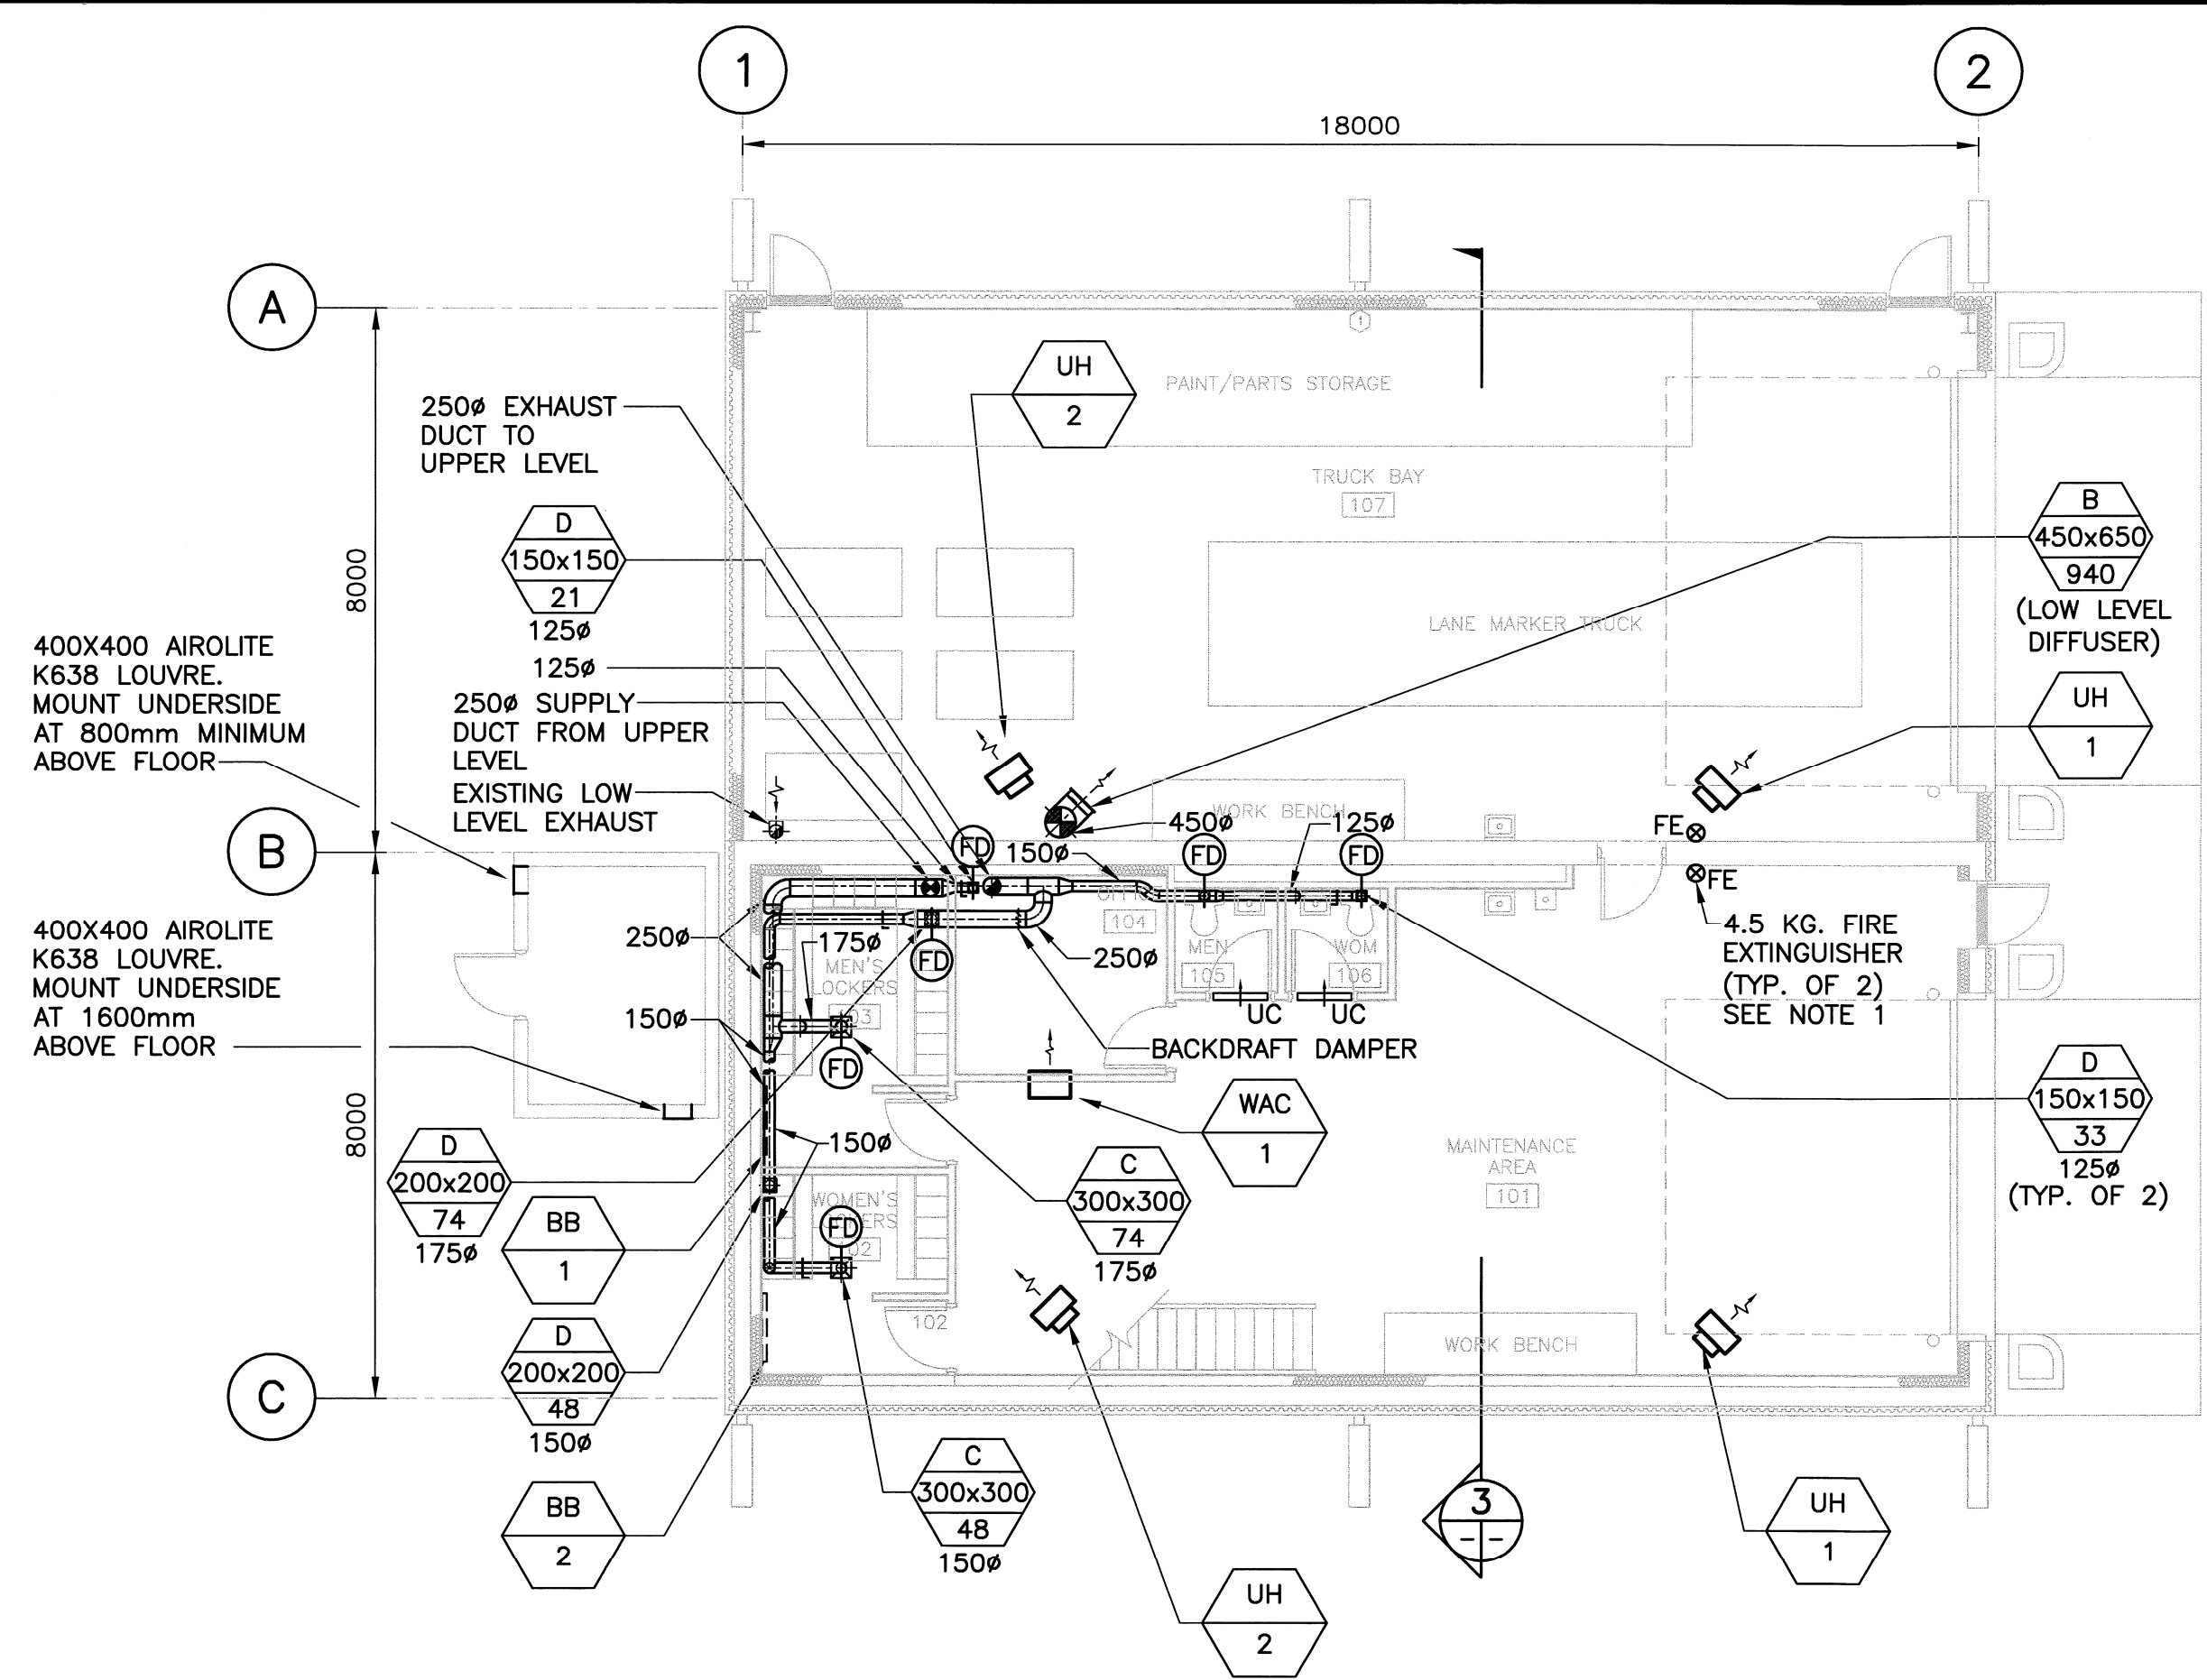

2 FLOOR PLAN (LOW LEVEL) - VENTILATION
1:100

- GENERAL NOTES:**
1. ALL DIMENSIONS ARE IN MILLIMETERS AND/OR METERS UNLESS NOTED OTHERWISE.
 2. PROVIDE BALANCING DAMPER ON ALL DUCT BRANCH TAKE-OFF FOR SUPPLY DIFFUSERS AND EXHAUST GRILLES.
 3. DUCTWORK PRESSURE CLASSIFICATION SHALL BE 500 PA.
 4. REFER TO DRAWING M-0001 FOR LEGEND.
 5. REFER TO DRAWING M-0002 FOR EQUIPMENT SCHEDULE.

- NOTES:**
1. PORTABLE FIRE EXTINGUISHERS SHALL BE UL APPROVED CLASS "ABC" DRY CHEMICAL AND SHALL BE MOUNTED ON A WALL BRACKET AT 1.5 METERS ABOVE THE FINISHED FLOOR LEVEL. PROVIDE A FIRE EXTINGUISHER SIGN AT LEAST 2.4 METERS ABOVE THE FIRE EXTINGUISHER.

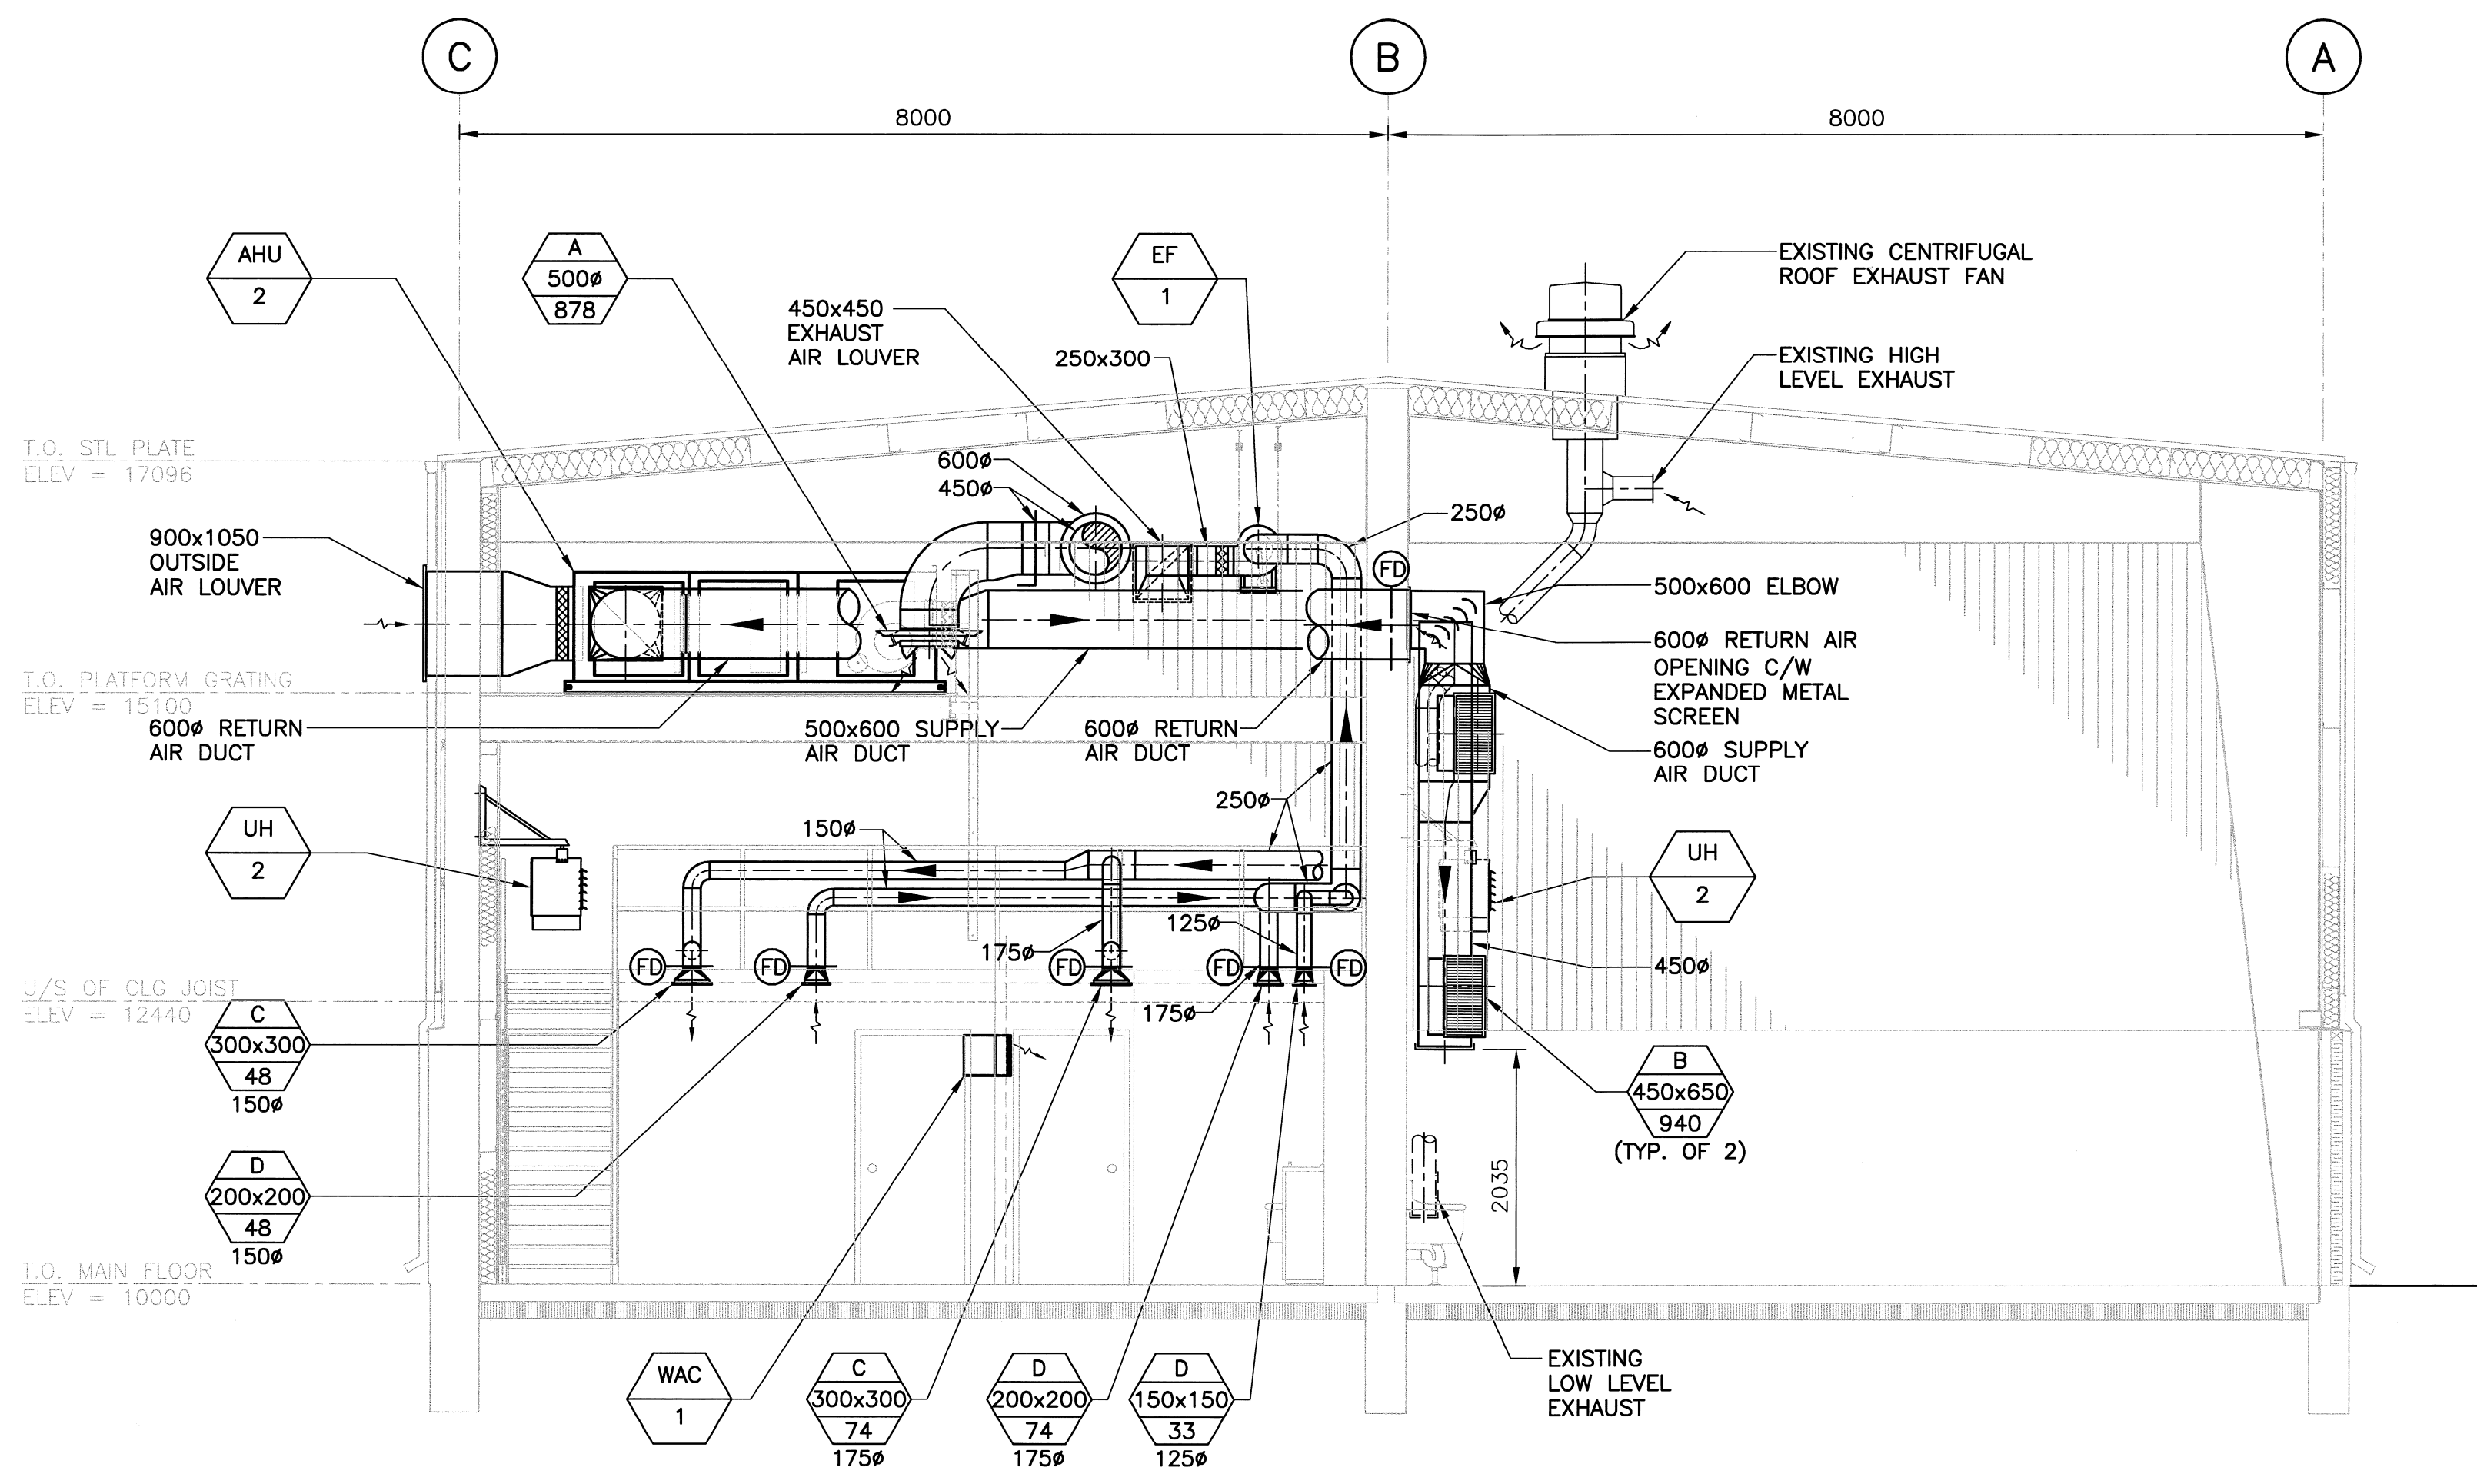

3 SECTION
1:50



0	ISSUED FOR TENDER	09.04.17	L.S.
NO.	DESCRIPTION	DATE	ISSUED BY
REVISIONS/ISSUE			
<small>THE CONTENT OF THIS DOCUMENT IS NOT INTENDED FOR THE USE OF, NOR IS IT INTENDED TO BE RELIED UPON BY ANY PERSON, FIRM OR CORPORATION, OTHER THAN THE CLIENT AND WARDROP ENGINEERING INC. WARDROP ENGINEERING DOES ANY LIABILITY WHATSOEVER TO OTHER PARTIES FOR DAMAGES OR INJURY SUFFERED BY SUCH THIRD PARTY ARISING FROM USE OF THIS DOCUMENT BY THEM, WITHOUT THE EXPRESS PRIOR WRITTEN AUTHORITY OF WARDROP ENGINEERING AND OUR CLIENT. THIS DOCUMENT IS SUBJECT TO FURTHER RESTRICTIONS IMPOSED BY THE CONTRACT BETWEEN THE CLIENT AND WARDROP ENGINEERING INC. AND THESE PARTIES' PERMISSION MUST BE SOUGHT REGARDING THIS DOCUMENT IN ALL OTHER CIRCUMSTANCES.</small>			
CLIENT			
CITY OF WINNIPEG PUBLIC WORKS TRAFFIC SERVICES			
WARDROP Engineering Inc.			
PROJECT NAME			
RENOVATIONS FOR PAVEMENT MARKING OPERATIONS FACILITY			
DRAWING DESCRIPTION			
FLOOR PLAN HIGH LEVEL PLAN/LOW LEVEL PLAN AND SECTION - HVAC			
DESIGNED BY:	DRAWN BY:	CHECKED BY:	
WGN	WGN	L.S.	
APPROVED BY:			
SCALE:		DATE:	
AS NOTED		09.02.09	
DRAWING NO.	0900070300-DWG-M0003		REV.
			0