
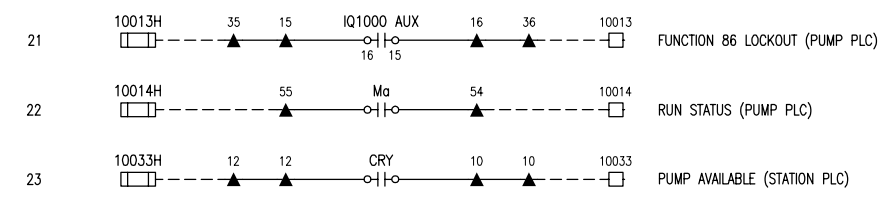


A1 SIZE - 594mm x 841mm

1
2
3
4
5
6
7
8
9
10
11
12
13
14
15
16
17
18
19
20
21
22
23
24
25
26
27
28
29
30

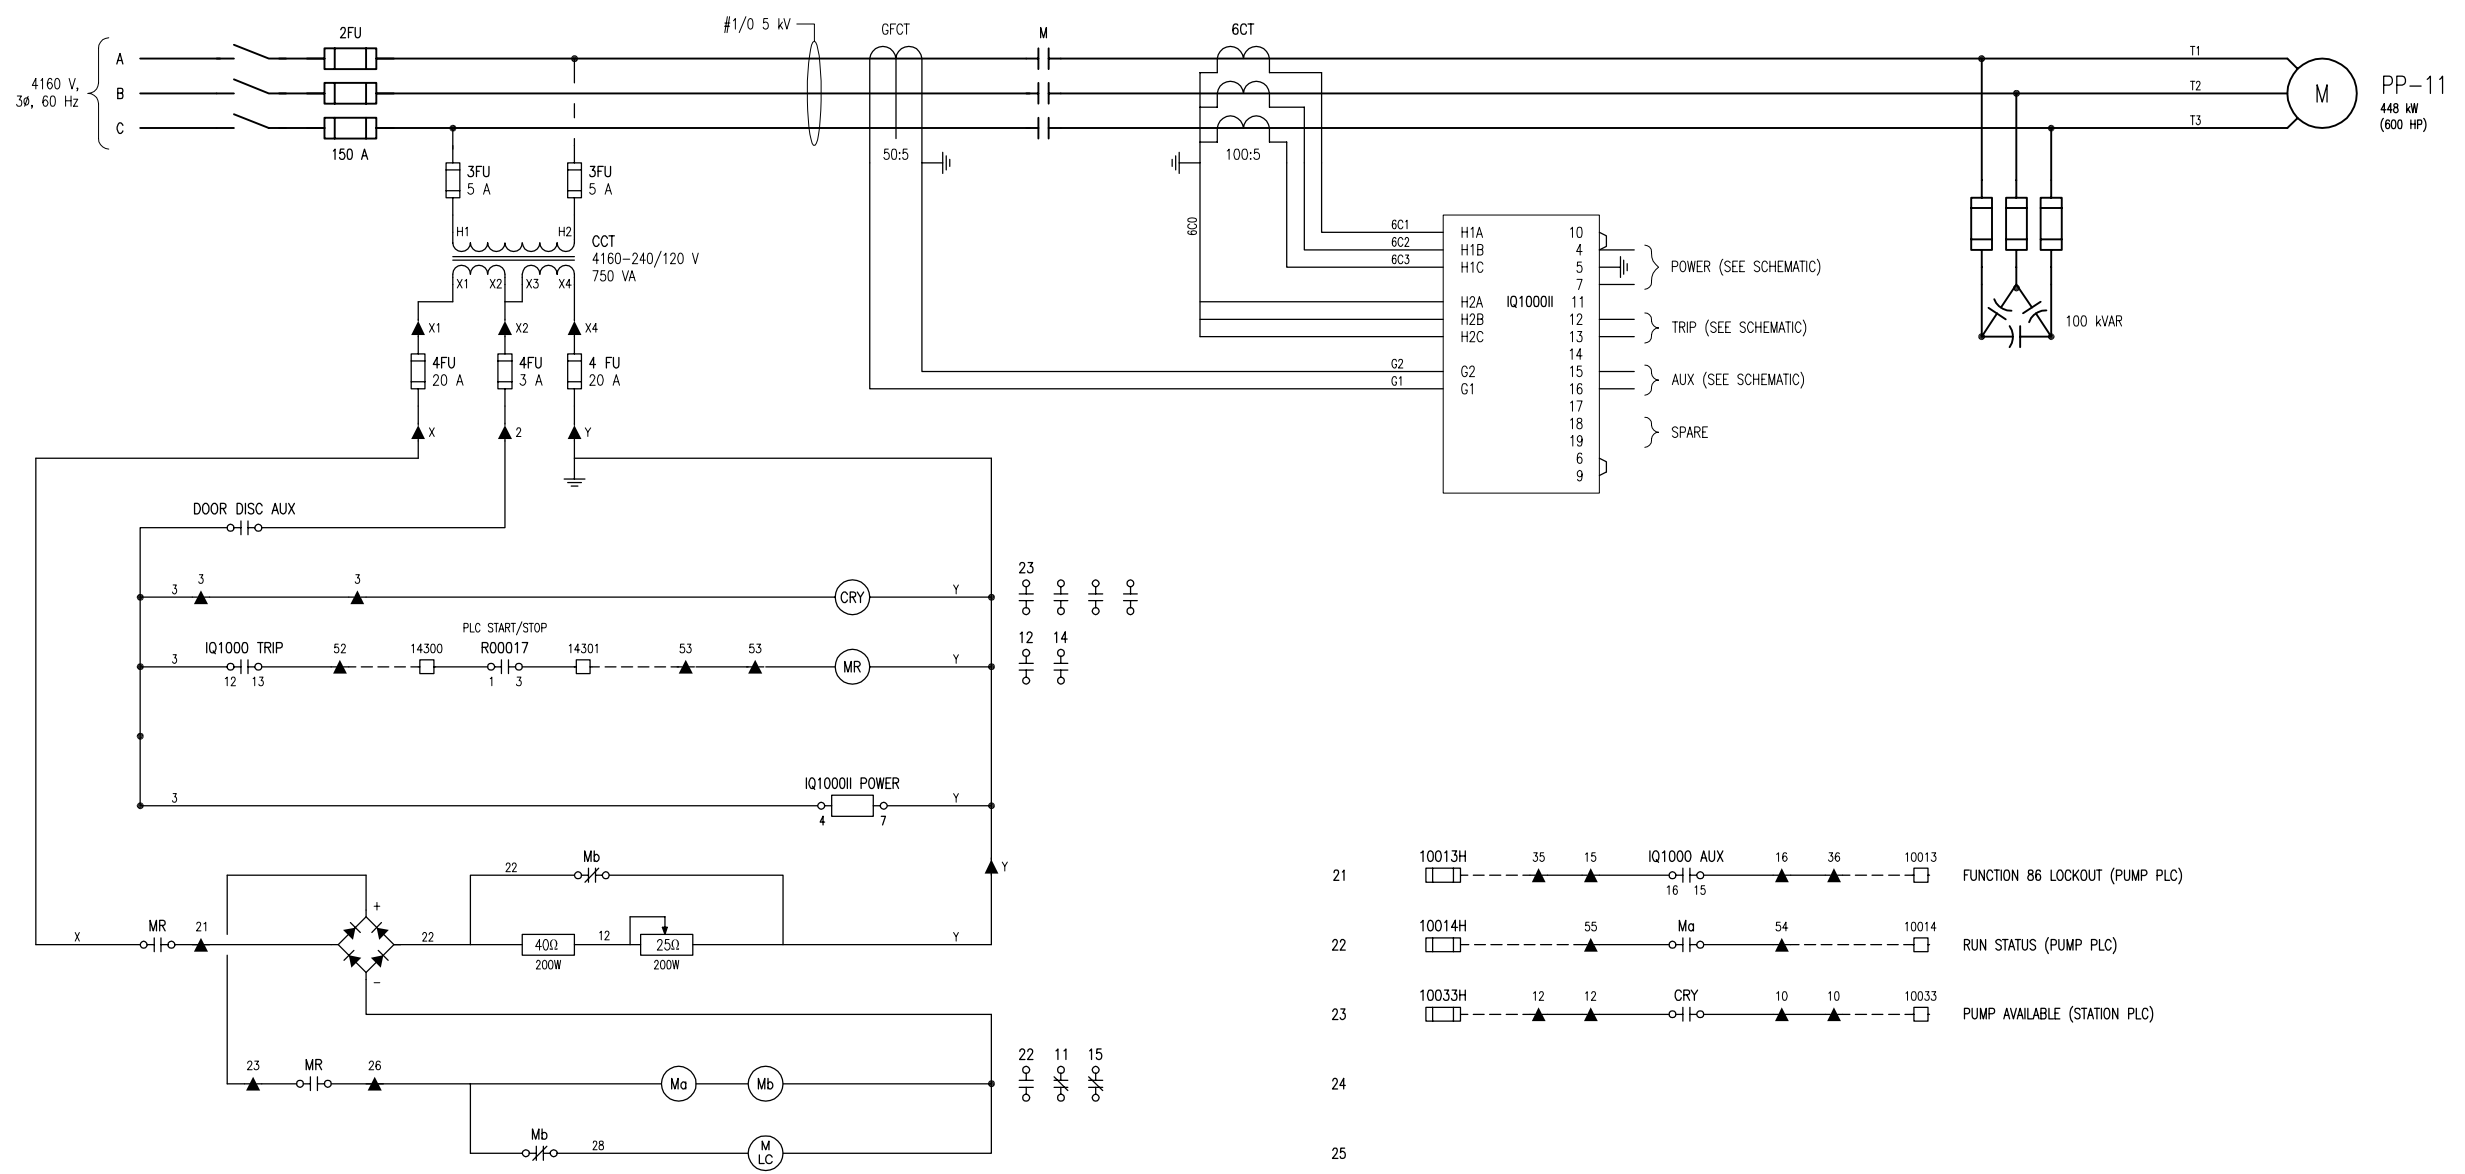

LEGEND:
 - - - - - FIELD WIRING
 ——— STARTER / PANEL WIRING
 ▲ STARTER TERMINAL
 □ CONTROL PANEL TERMINAL

LAST SAVE: 2009/05/29 - 8:20am
 PATH: M:\12900\GEN\WELLE\DD - General DWG\Hurst\1-0650M-E0005-001-01.dwg

1-0650M-E0002	ELECTRICAL SINGLE LINE DIAGRAM - 4160 V DISTRIBUTION
DRAWING NUMBER	REFERENCE DRAWINGS

B.M. ELEV.	FIELD BOOK #:	 SNC-LAVALIN INC. 148 Notaire Park Way Winnipeg, MB, Canada R3P 0X7 204-786-8080	ENGINEER'S SEAL	 THE CITY OF WINNIPEG WATER AND WASTE DEPARTMENT HURST PUMPING STATION MOTOR STARTER SCHEMATIC PUMP PP-11
POSTED TO LBIS			DESIGNED BY: EXISTING CHECKED BY: CJR DRAWN BY: CJR APPROVED BY: CJR HOR. SCALE: NTS VERTICAL: NTS RELEASED FOR CONSTRUCTION DATE: 2005/11/17 DATE:	
01 REVISED DRAWING NUMBER	2008/02/13	AEO		
00 ISSUED FOR CITY USE	2007/08/28	Y.M		
NO. REVISIONS	DATE	BY	FILENAME: 1-0650M-E0005-001-01.dwg	
CITY DRAWING NUMBER			SHEET	REV.
1-0650M-E0005			001	01 A1