


LEGEND	
LFMC	LIQUID TIGHT FLEXIBLE METAL CONDUIT
LFNMC	LIQUID TIGHT FLEXIBLE NON-METALLIC CONDUIT
RGS	RIGID GALVANIZED STEEL CONDUIT

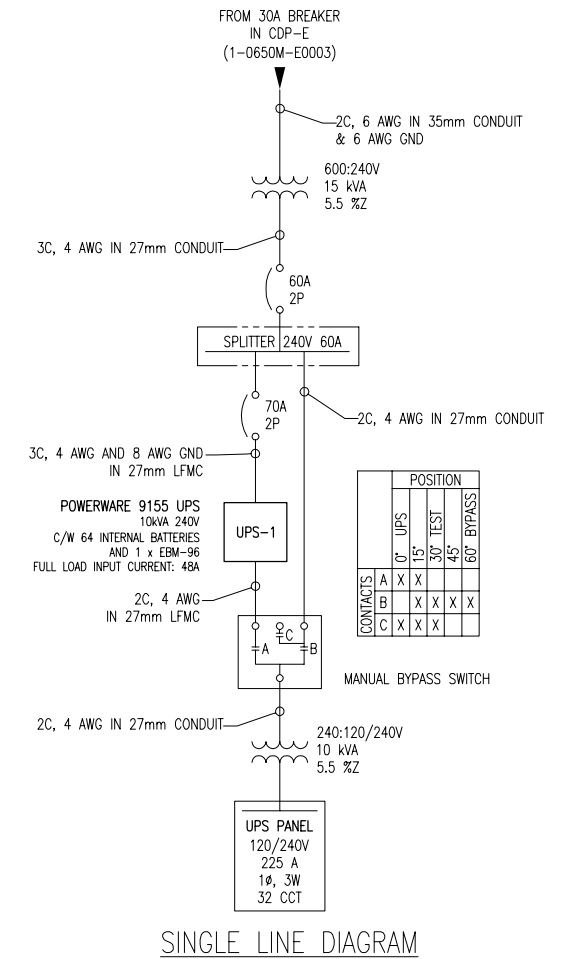

CONTACTS	POSITION				
	0'	15'	30'	45'	60'
A	X	X	X	X	X
B	X	X	X	X	X
C	X	X	X	X	X

1-0650M-E0014	ELECTRICAL ROOM EQUIPMENT PLAN
DRAWING NUMBER	REFERENCE DRAWINGS



NO.	REVISIONS	DATE	DESIGN	CHECK
04	MODIFIED TITLE BLOCK; REFERENCED NEW DRAWING	2009/05/27	BOK	CJR
03	AS BUILT	2008/11/24	AEO	CJR
02	ISSUED FOR CONSTRUCTION	2008/05/13	DC	CJR
01	REMOVED SUPPLY OF UPS FROM NOTES	2008/02/22	YOM	CJR
00	ISSUED FOR CITY USE	2008/01/08	AEO	CJR

SNC-LAVALIN INC.
148 Notary Park Way
Winnipeg, MB, Canada R3P 0X7
204-786-8080

DESIGNED BY: C. REIMER
CHECKED BY: C. REIMER
DRAWN BY: A. OLIVER
APPROVED BY: C. REIMER
SCALE: NTS
RELEASED FOR CONSTRUCTION
DATE: 2007/07/05
DATE: G. PATTON

ENGINEER'S SEAL
ORIGINAL DRAWING
SEALED BY:
C. J. REIMER
2009/03/14
REV. 03

THE CITY OF WINNIPEG
WATER AND WASTE DEPARTMENT

HURST WATER PUMPING STATION
UPS UPGRADES
SINGLE LINE DIAGRAM & LAYOUT
UPS-1

CITY DRAWING NUMBER	SHEET	REV.	SIZE
1-0650M-E0011	001	04	A1