



**A BUILDING SECTION DETAIL**  
B0002 1:50

**B BUILDING SECTION DETAIL**  
B0002 1:50


**C BUILDING SECTION DETAIL**  
B0002 1:50

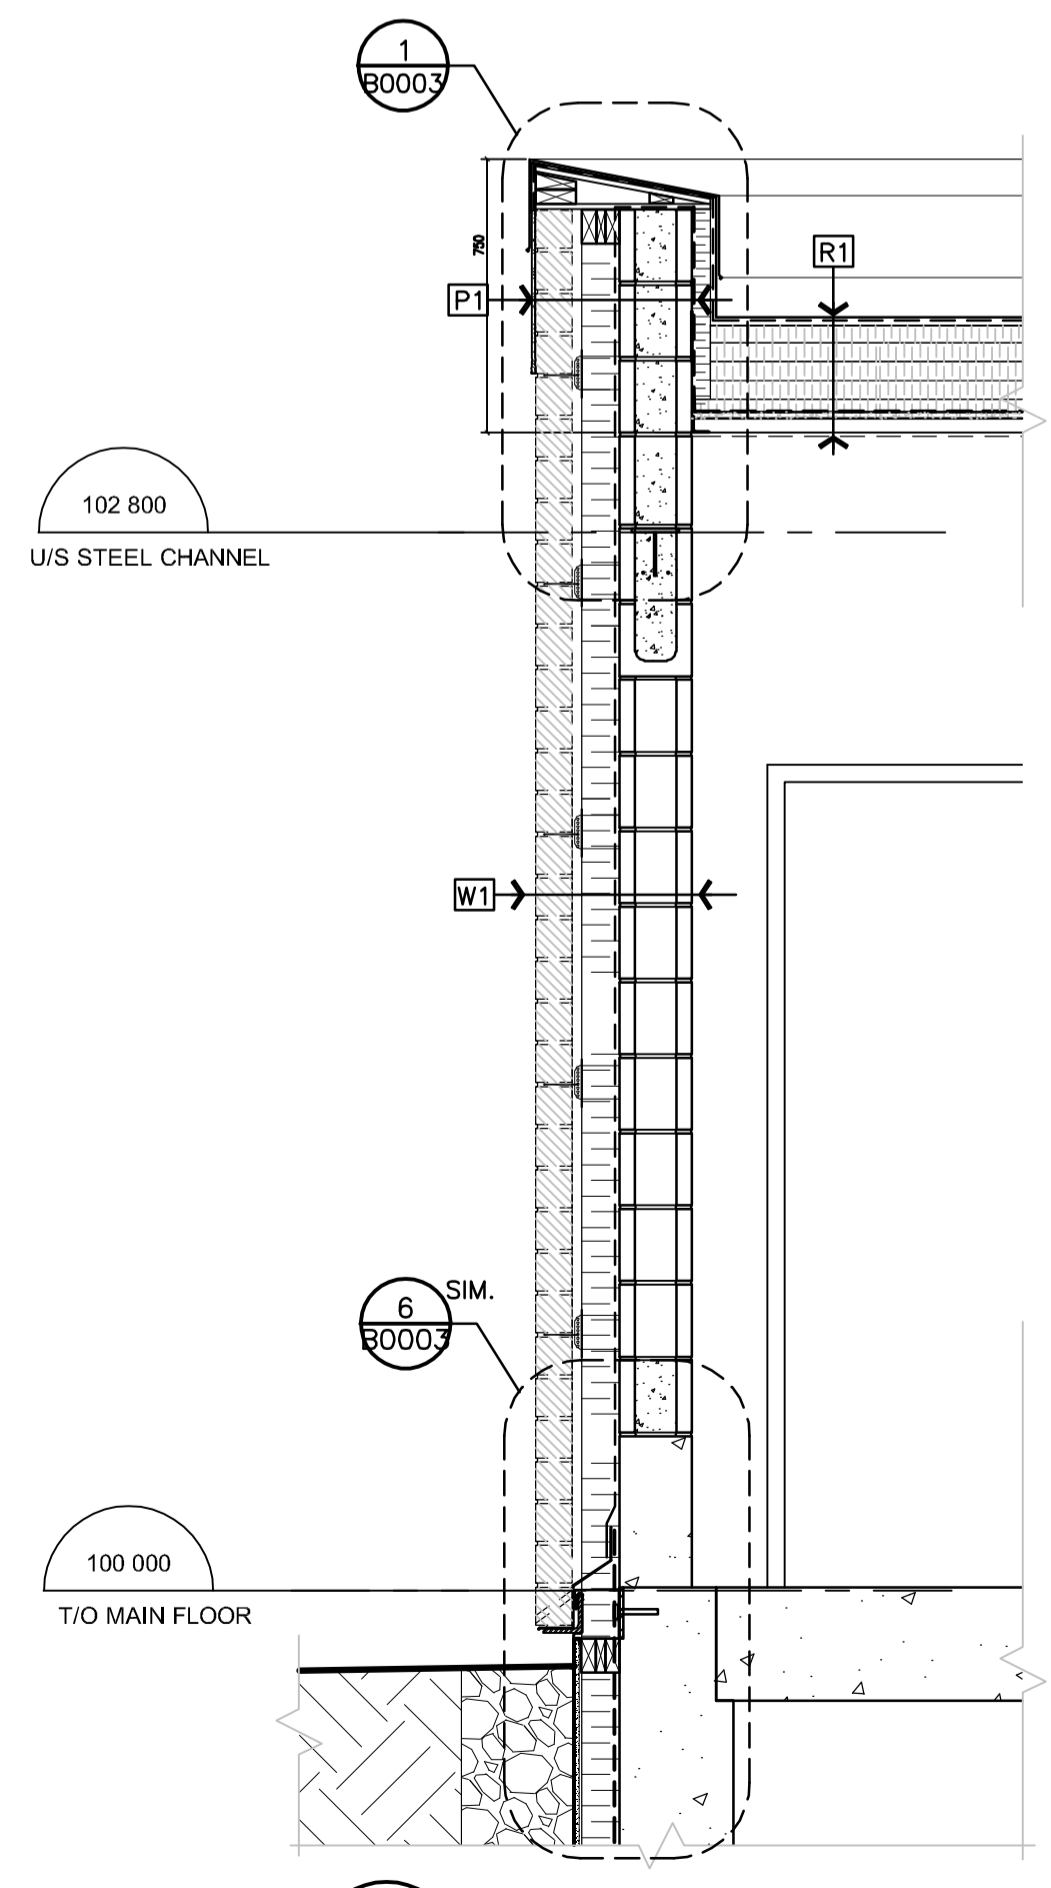

**1 WALL SECTION**  
B0002 1:20

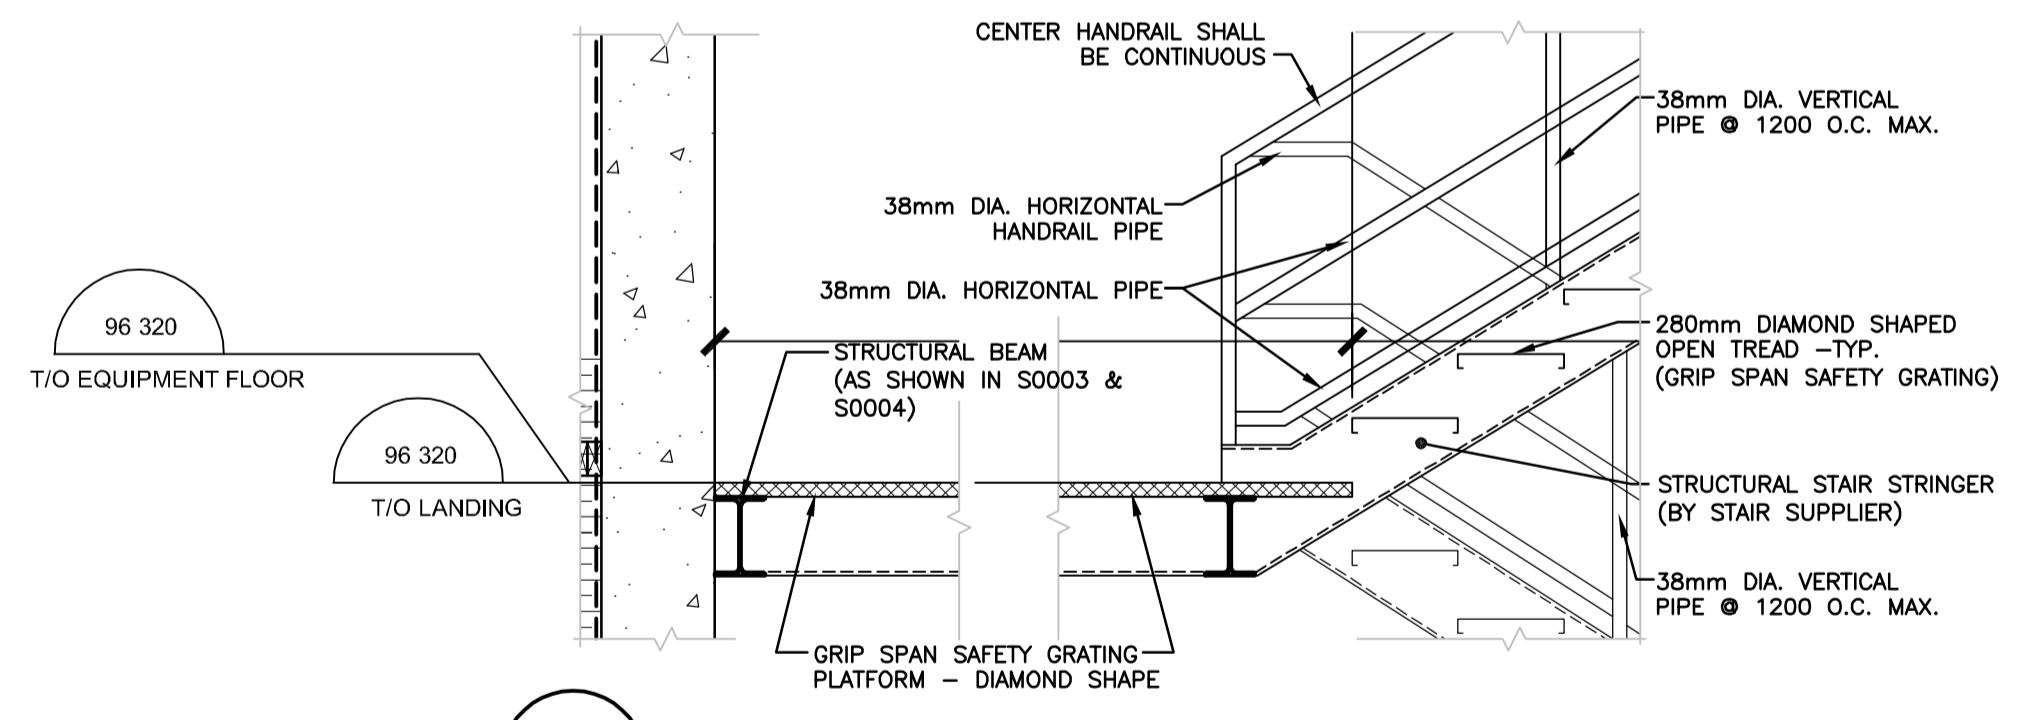

**2 SECTION DETAIL**  
B0002 1:10

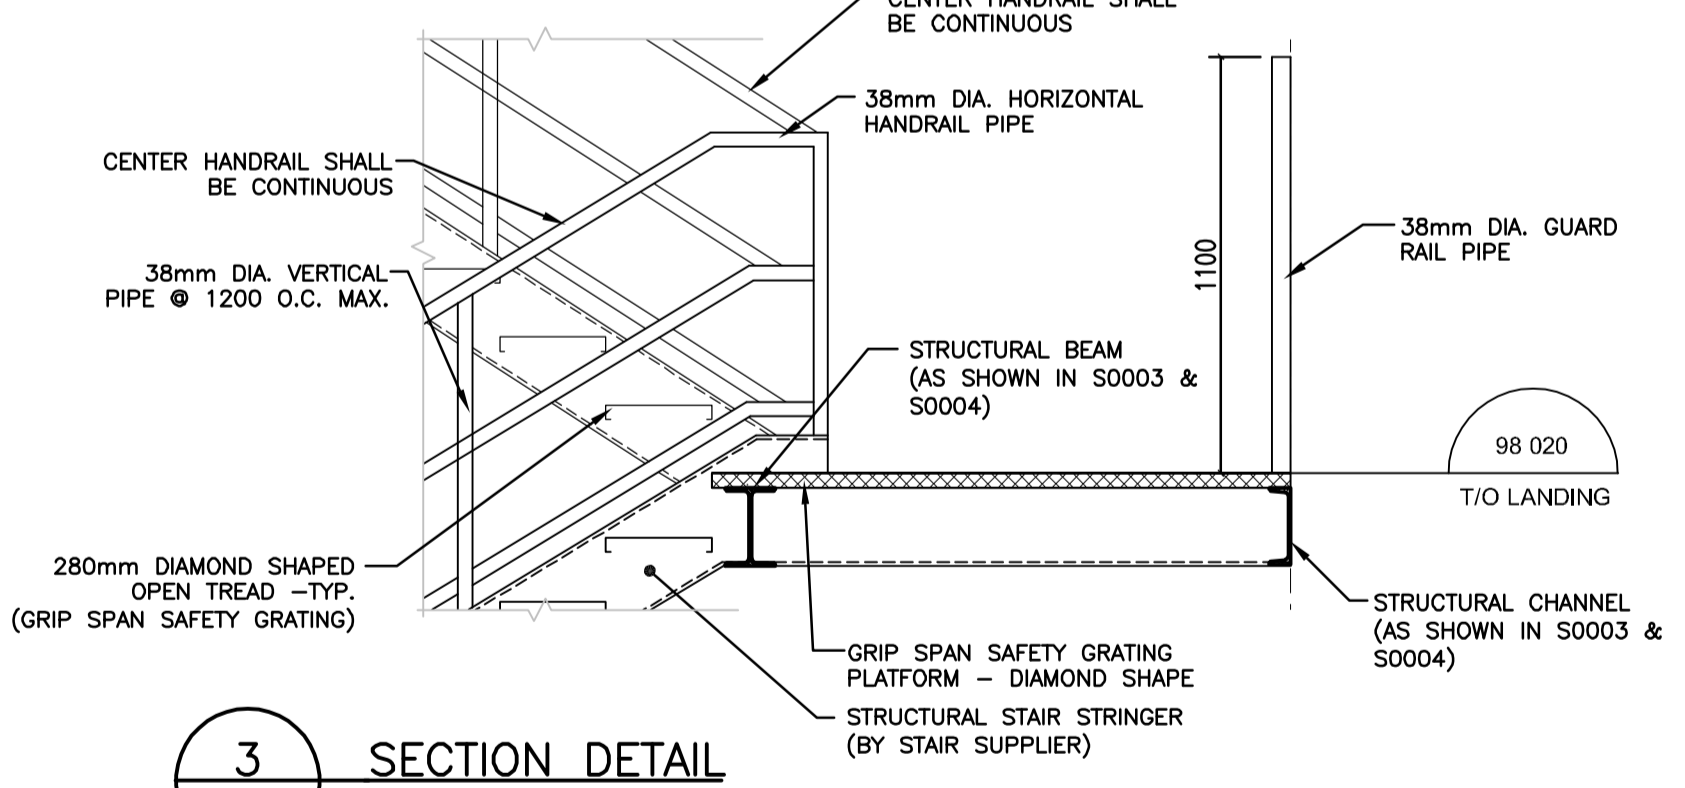

**3 SECTION DETAIL**  
B0002 1:10

**NOTE:**  
- ALL STAIR TREADS, AND GRATINGS TO BE: ( ALUMINUM - GRIP SPAN )  
- STRUCTURAL CHANNELS, RAILINGS AND BEAMS AT LANDINGS TO BE HOT DIP GALVANIZED.

**METRIC**  
WHOLE NUMBERS INDICATE MILLIMETRES  
DECIMALIZED NUMBERS INDICATE METRES



LOCATION APPROVED UNDERGROUND STRUCTURES		
SUPV. U/G STRUCTURES COMMITTEE	DATE	
NOTE: LOCATION OF UNDERGROUND STRUCTURES AS SHOWN ARE BASED ON THE BEST INFORMATION AVAILABLE BUT NO GUARANTEE IS GIVEN THAT ALL EXISTING UTILITIES ARE SHOWN OR THAT THE GIVEN LOCATIONS ARE EXACT. CONFIRMATION OF EXISTENCE AND EXACT LOCATION OF ALL SERVICES MUST BE OBTAINED FROM THE INDIVIDUAL UTILITIES BEFORE PROCEEDING WITH CONSTRUCTION.		
NO.	REVISIONS	DATE BY
1	REVISE RAILING MATERIALS	10.03.08
A	ISSUED FOR TENDER	10.02.16 WO

B.M. ELEV.	
DESIGNED BY	W.O.
CHECKED BY	B.C.
DRAWN BY	W.O.
APPROVED BY	M.H.
HOR. SCALE:	AS NOTED
VERTICAL:	RELEASED FOR CONSTRUCTION:
DATE	09.09.21

**Stantec Consulting Ltd.**  
905 Waverley Street, Winnipeg, Manitoba  
Tel 204-489-5900 Fax 204-453-9012

ENGINEER'S SEAL  
ORIGINALLY SEALED BY:  
MOHAMMAD HOQUE  
FEB. 24, 2010

**THE CITY OF WINNIPEG**  
WATER AND WASTE DEPARTMENT

**Winnipeg**

**NORTH END WATER POLLUTION CONTROL FACILITIES  
HAULED WASTEWATER RECEIVING FACILITIES  
HAULED WASTEWATER BUILDING  
BUILDING SECTIONS AND DETAILS**

BID OPPORTUNITY NO. 822-2009  
CITY DRAWING NUMBER 1-0101A-B0002-001  
SHEET 1 OF 1

V:\1170\wastwa\11701830\Drawings\401\_sds\dwg\401\_sds\dwg\11701830-102.dwg [1-102]  
2010-03-08 09:28AM By: mason