



A BUILDING SECTION DETAIL
B0002 1:50

B BUILDING SECTION DETAIL
B0002 1:50


C BUILDING SECTION DETAIL
B0002 1:50

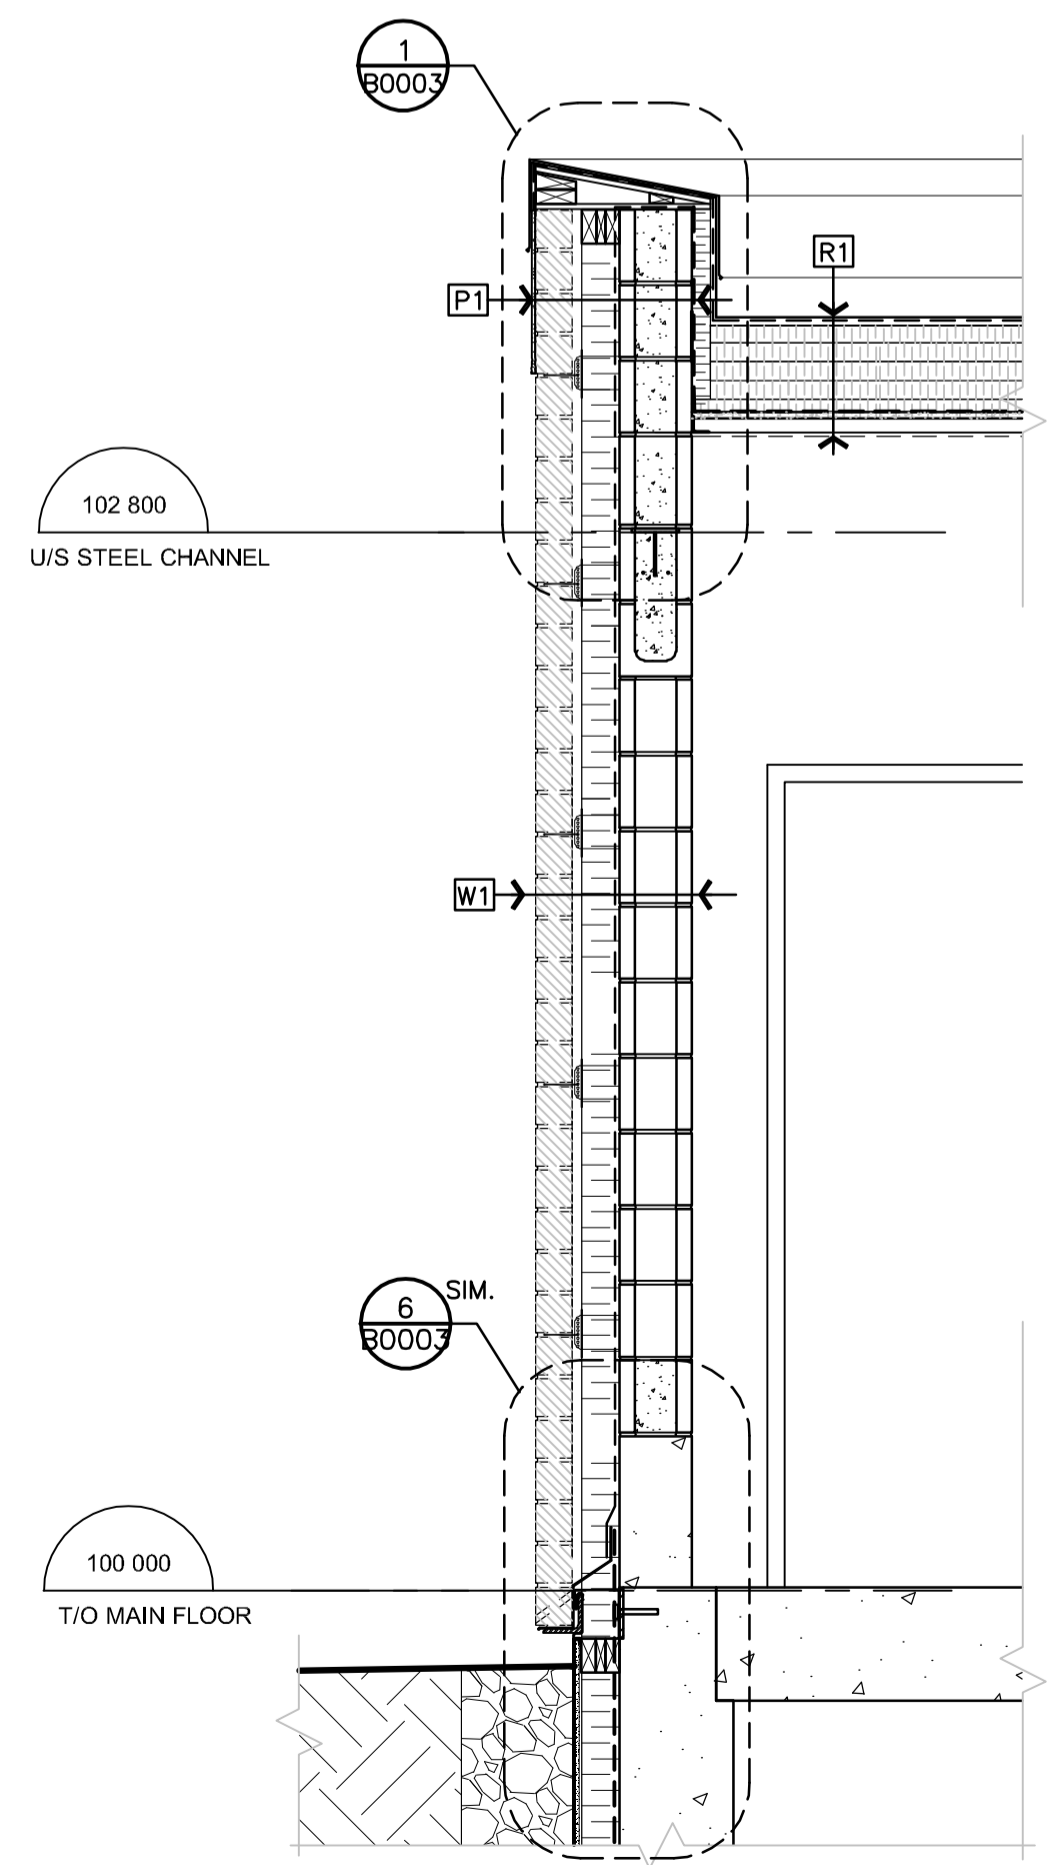

1 WALL SECTION
B0002 1:20

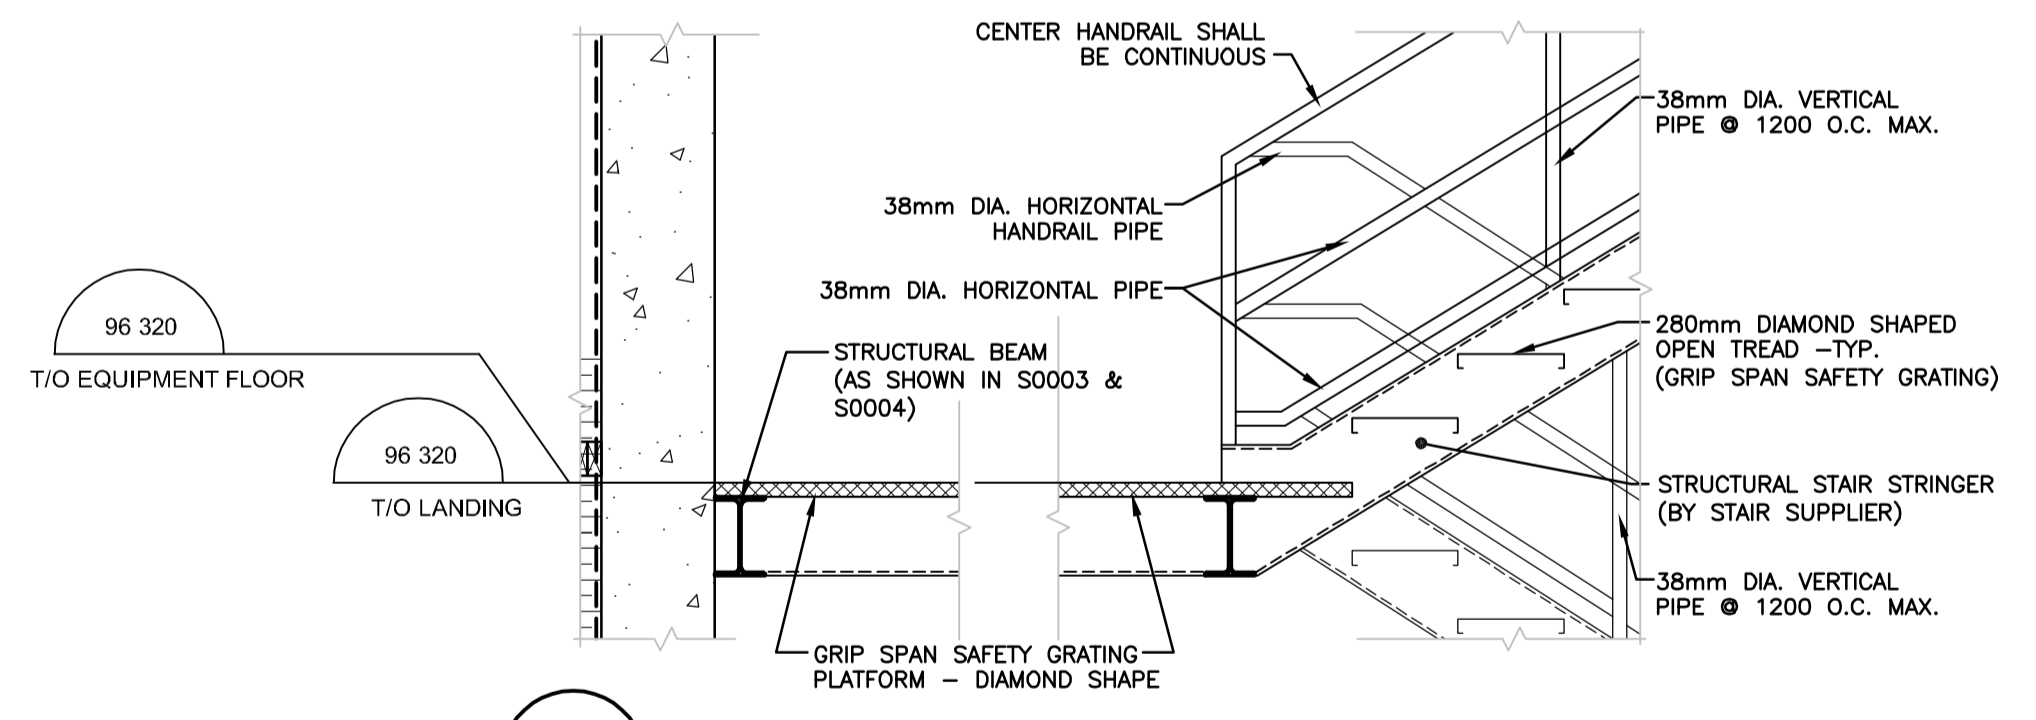

2 SECTION DETAIL
B0002 1:10

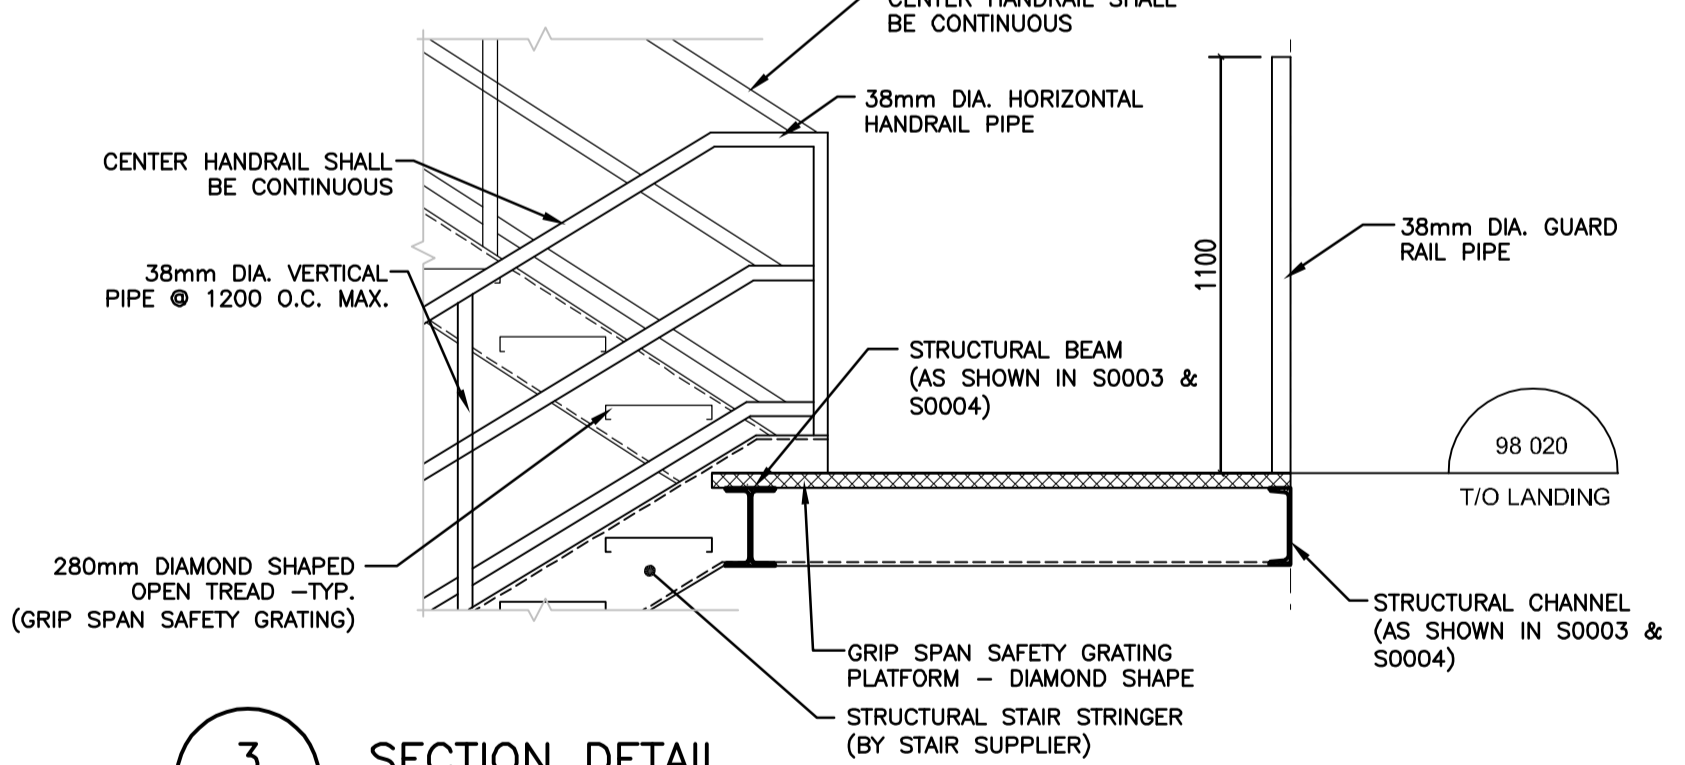

3 SECTION DETAIL
B0002 1:10

NOTE:
- ALL STAIR TREADS, AND GRATINGS TO BE: (ALUMINUM - GRIP SPAN)
- STRUCTURAL CHANNELS, RAILINGS AND BEAMS AT LANDINGS TO BE HOT DIP GALVANIZED.

METRIC
WHOLE NUMBERS INDICATE MILLIMETRES
DECIMALIZED NUMBERS INDICATE METRES

APEGM
Certificate of Authorization
Stantec Consulting Ltd.
No. 1301 Date: _____

LOCATION APPROVED UNDERGROUND STRUCTURES

SUPV. U/G STRUCTURES COMMITTEE	DATE

NOTE:
LOCATION OF UNDERGROUND STRUCTURES AS SHOWN ARE BASED ON THE BEST INFORMATION AVAILABLE BUT NO GUARANTEE IS GIVEN THAT ALL EXISTING UTILITIES ARE SHOWN OR THAT THE GIVEN LOCATIONS ARE EXACT. CONFIRMATION OF EXISTENCE AND EXACT LOCATION OF ALL SERVICES MUST BE OBTAINED FROM THE INDIVIDUAL UTILITIES BEFORE PROCEEDING WITH CONSTRUCTION.

NO.	REVISIONS	DATE	BY
2	ADDENDUM#3 PIPE PENETRATION	10.03.19	
1	ADDENDUM#2 RAILING MATERIALS	10.03.08	MH
A	ISSUED FOR TENDER	10.02.16	WO

Stantec Consulting Ltd.
905 Waverley Street, Winnipeg, Manitoba
Tel 204-489-5900 Fax 204-453-9012

DESIGNED BY	W.O.	CHECKED BY	B.C.
DRAWN BY	W.O.	APPROVED BY	M.H.
HOR. SCALE:	AS NOTED	RELEASED FOR CONSTRUCTION:	
VERTICAL:		DATE	09.09.21

ENGINEER'S SEAL

ORIGINALLY SEALED BY:
MOHAMMAD HOQUE
FEB. 24, 2010

THE CITY OF WINNIPEG
WATER AND WASTE DEPARTMENT

Winnipeg

NORTH END WATER POLLUTION CONTROL CENTRE
HAULED WASTEWATER RECEIVING FACILITIES
HAULED WASTEWATER BUILDING
BUILDING SECTIONS AND DETAILS

BID OPPORTUNITY NO. 822-2009
CITY DRAWING NUMBER 1-0101A-B0002-001
SHEET 1 OF 1

V:\1170\wastwa\11701830\dwg\11701830.dwg (4/3/2010 10:00:00 AM) User: j... Path: ...