


1 PLAN
P0002 1:20

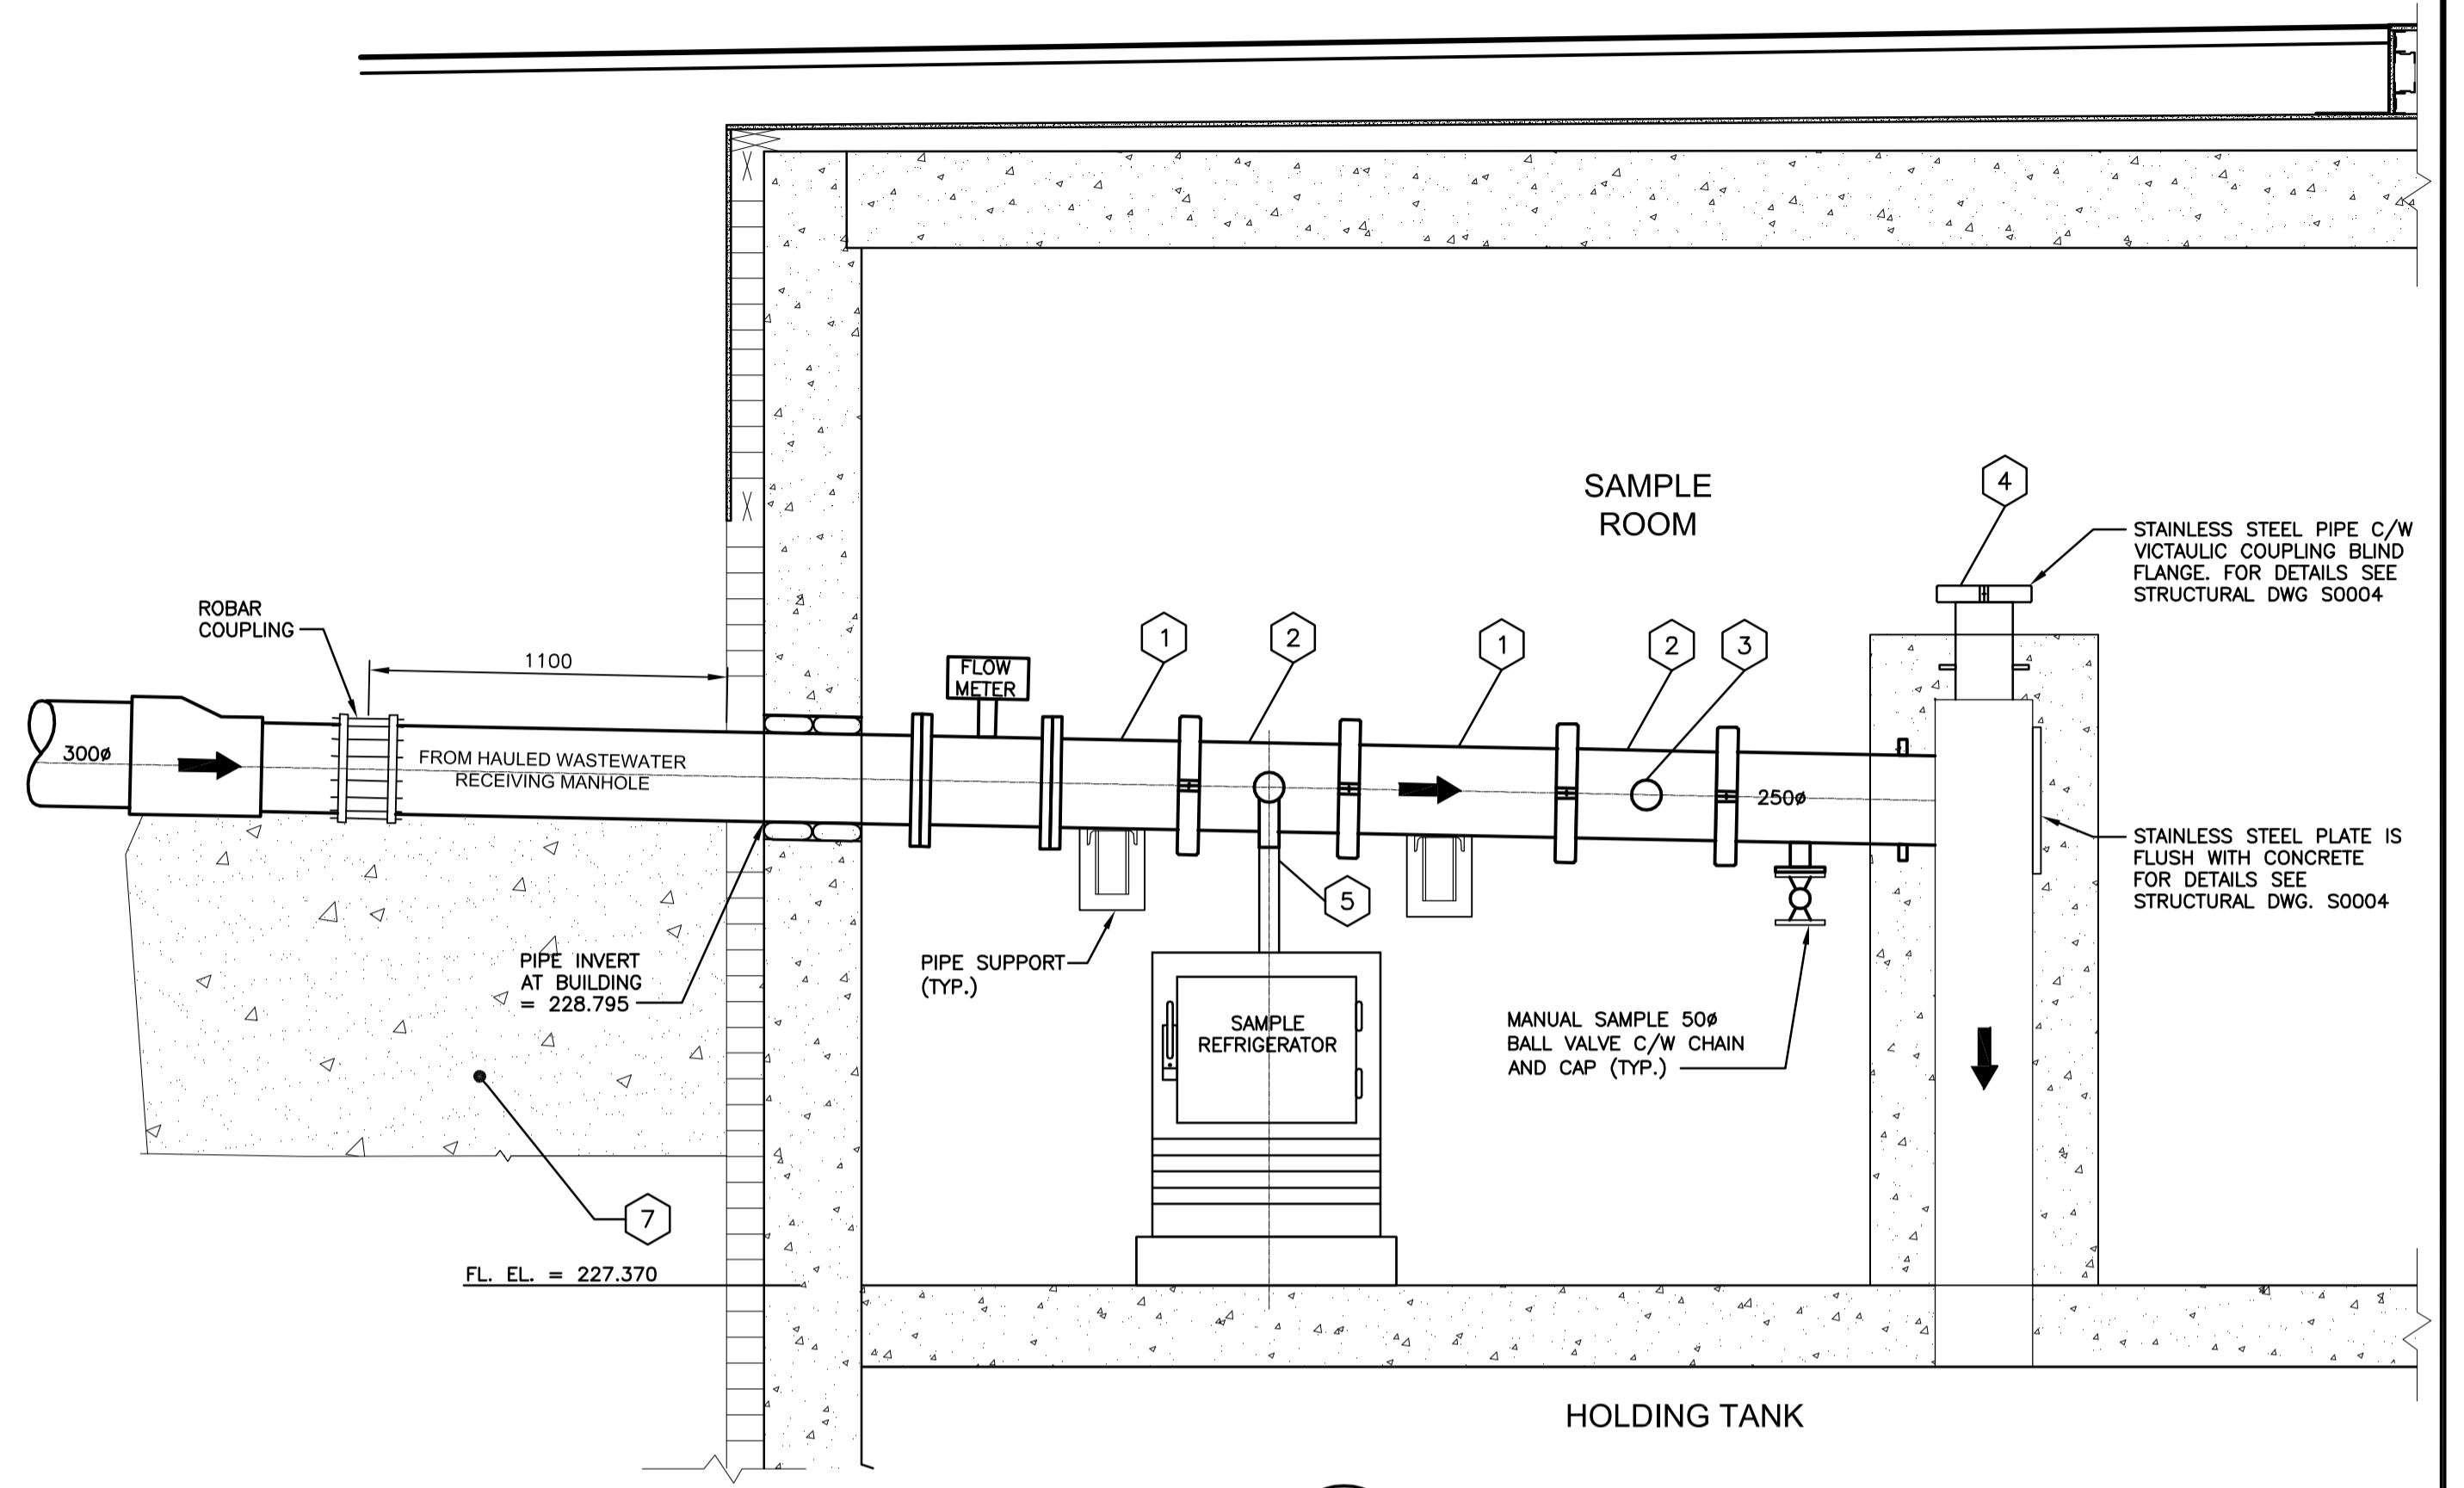

A SECTION
P0002 1:20

NOTE:

- 1 ALL PIPE TO BE IPS TYPE 316L STAINLESS STEEL -SCHEDULE 10S AS PER ASTM A778
- 2 MANUFACTURED IPS TYPE 316L STAINLESS STEEL SPOOL PIECE WITH ADAPTER SADDLE FOR ISOLOK SAMPLING INSTRUMENT
- 3 PROVIDE GASKETED CAP FOR SPOOL PIECE
- 4 VICTAULIC STEEL RIGID COUPLING
- 5 CLEAR POLYVINYL TUBING
- 6 LEAN MIX CONCRETE FILL REFER TO STRUCTURAL DRAWING S0007

METRIC
WHOLE NUMBERS INDICATE MILLIMETRES
DECIMALIZED NUMBERS INDICATE METRES

APEGM
Certificate of Authorization
Stantec Consulting Ltd.
No. 1301 Date:

LOCATION APPROVED UNDERGROUND STRUCTURES			
SUPV. U/G STRUCTURES COMMITTEE	DATE		
NOTE: LOCATION OF UNDERGROUND STRUCTURES AS SHOWN ARE BASED ON THE BEST INFORMATION AVAILABLE BUT NO GUARANTEE IS GIVEN THAT ALL EXISTING UTILITIES ARE SHOWN OR THAT THE GIVEN LOCATIONS ARE EXACT. CONFIRMATION OF EXISTENCE AND EXACT LOCATION OF ALL SERVICES MUST BE OBTAINED FROM THE INDIVIDUAL UTILITIES BEFORE PROCEEDING WITH CONSTRUCTION.			
NO.	REVISIONS	DATE	BY
1	REVISED AS PER ADDENDUM #4		
A	ISSUED FOR TENDER	10.02.16	A.H.B

B.M. ELEV.			
DESIGNED BY	A.H.B.	CHECKED BY	E.W.
DRAWN BY	K.R.	APPROVED BY	A.H.B.
HOR. SCALE:	AS NOTED	RELEASED FOR CONSTRUCTION:	
VERTICAL:		DATE	
NO.	REVISIONS	DATE	BY
		09.11.10	

Stantec Consulting Ltd.
905 Waverley Street, Winnipeg, Manitoba
Tel 204-489-5900 Fax 204-453-9012

ENGINEER'S SEAL
ORIGINAL SEALED BY
A.H.BEGHIN
P. ENG.
10/02/24

THE CITY OF WINNIPEG
WATER AND WASTE DEPARTMENT

Winnipeg

NORTH END WATER POLLUTION CONTROL CENTRE
HAULED WASTEWATER RECEIVING FACILITIES
HAULED WASTEWATER RECEIVING BUILDING
SAMPLE ROOM FLOOR PLAN AND SECTION

TENDER NO. **822-2009** CITY DRAWING NUMBER **I-010IA-P0002-001** SHEET **2** OF **8**

V:\1170\wast\117018\02\mechanical\03_schematic\process\wastec\117018-102-rm-fldwg 2010-05-26 11:53AM By: t.mack