


1 LEVEL 3 - BELOW GRADE
B0004 1:50


2 LEVEL 2 - BELOW GRADE
B0004 1:50

3 LEVEL 1 - GRADE
B0004 1:50


4 ROOF PLAN
B0004 1:50

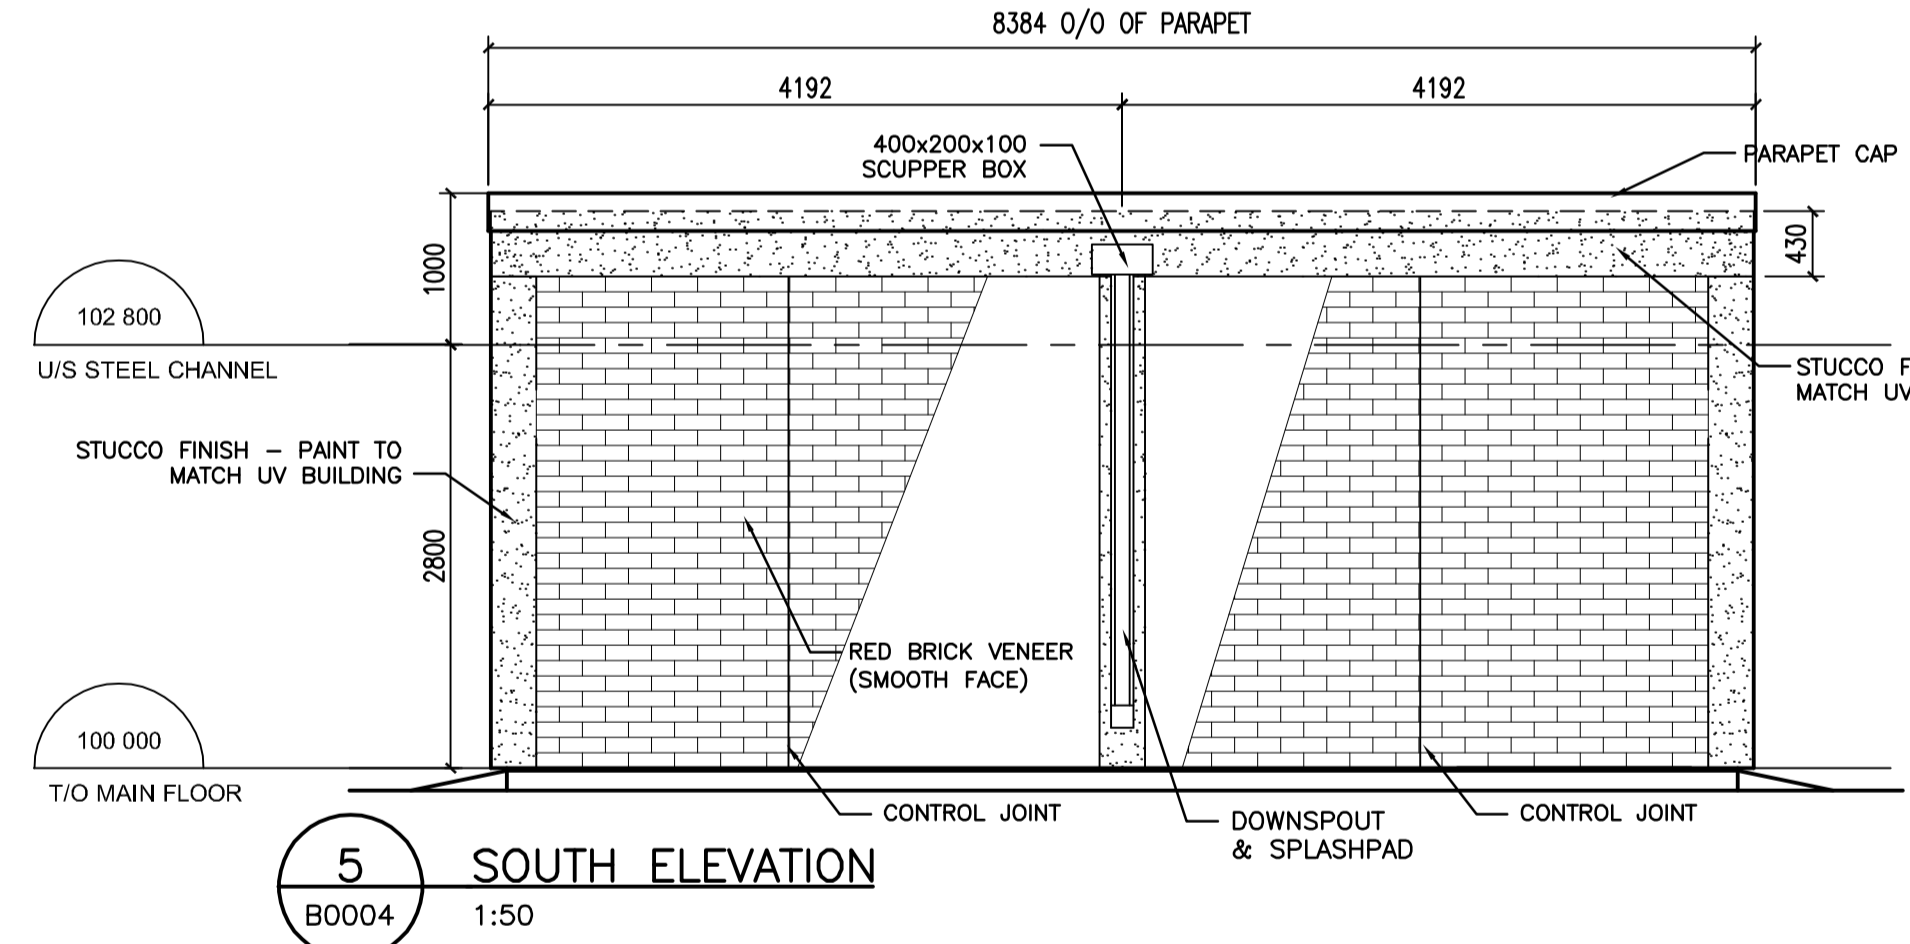


5 SOUTH ELEVATION
B0004 1:50

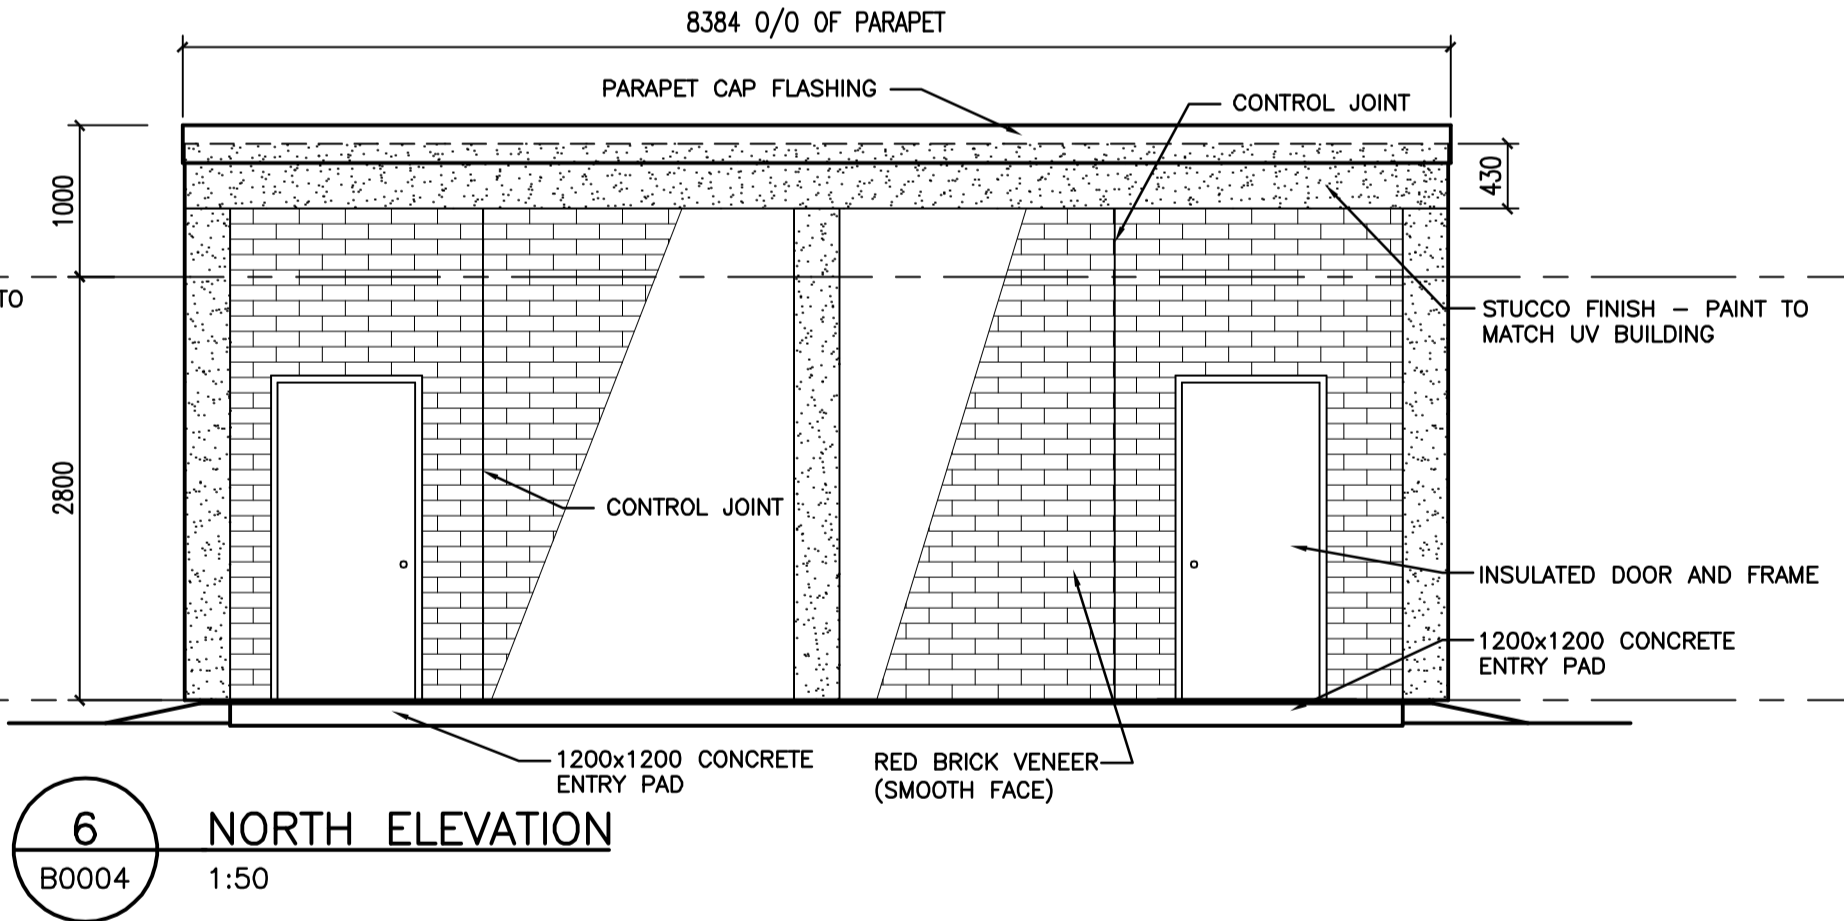

6 NORTH ELEVATION
B0004 1:50

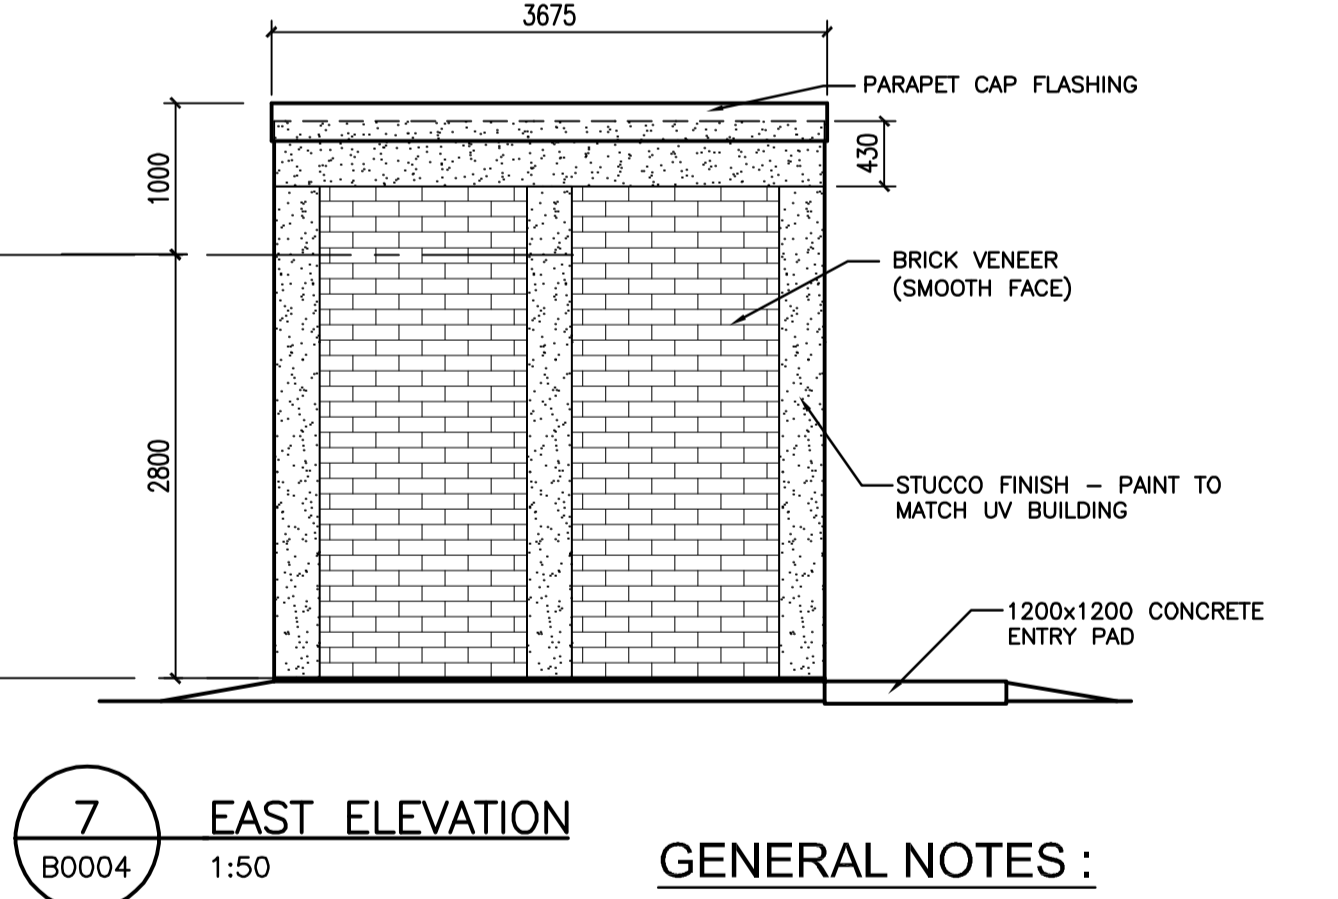

7 EAST ELEVATION
B0004 1:50

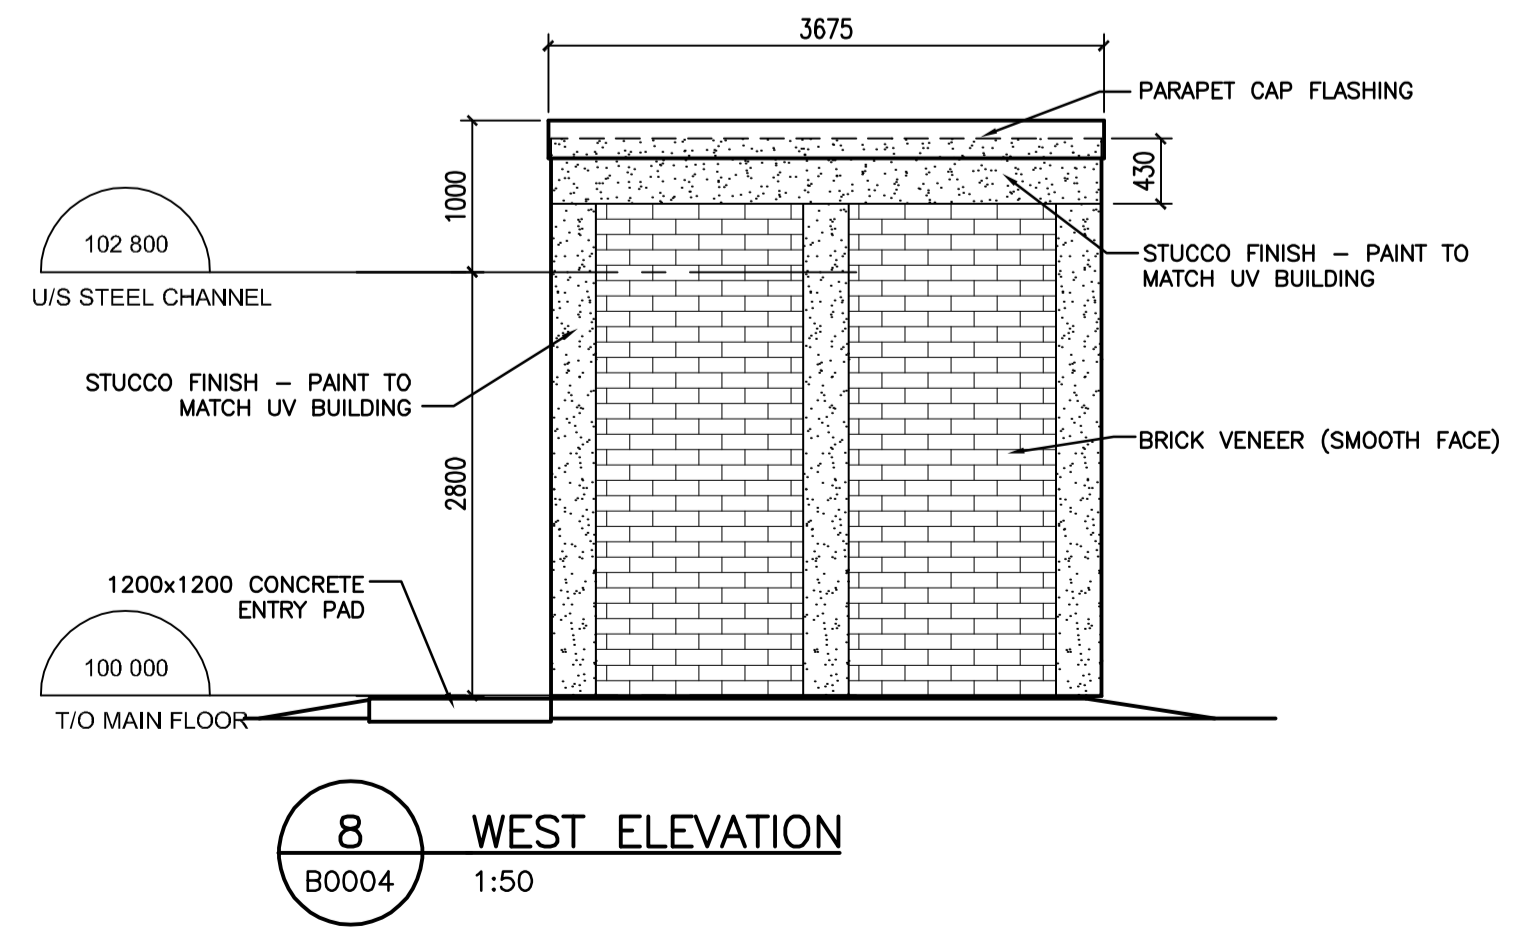

8 WEST ELEVATION
B0004 1:50

GENERAL NOTES :

1. THESE DRAWINGS SHALL NOT BE SCALE.
2. THE CONTRACTOR SHALL SATISFY THEMSELVES THAT ALL DIMENSIONS, DATUM, AND DETAILED INFORMATION SHOWN ARE CORRECT.
3. THE CONTRACTOR IS TO REPORT ANY DISCREPANCIES PRIOR TO COMMENCEMENT OF WORK.
4. THE CONTRACTOR IS TO REVIEW ALL ARCHITECTURAL, MECH AND ELECTRICAL DRAWINGS FOR ALL ADDITIONAL OPENINGS THROUGH FLOORS AND ROOF FOR DUCT AND PIPING RISERS, ELECTRICAL RISERS, AND ALL OPENINGS NOT SHOWN ON THE STRUCTURAL DRAWINGS.
5. ALL PARTITIONS ARE TO EXTEND FROM THE FLOOR SLAB TO THE U/S OF THE FLOOR OR ROOF MEMBRANE ABOVE.
6. ALL WOOD BLOCKING USED AT OR BELOW GRADE IS TO BE PRESSURE-TREATED.

METRIC
WHOLE NUMBERS INDICATE MILLIMETRES
DECIMALIZED NUMBERS INDICATE METRES

APEGM
Certificate of Authorization
Stantec Consulting Ltd.
No. 1301 Date: _____

LOCATION APPROVED UNDERGROUND STRUCTURES

SUPV. U/G STRUCTURES COMMITTEE	DATE
NOTE: LOCATION OF UNDERGROUND STRUCTURES AS SHOWN ARE BASED ON THE BEST INFORMATION AVAILABLE BUT NO GUARANTEE IS GIVEN THAT ALL EXISTING UTILITIES ARE SHOWN OR THAT THE GIVEN LOCATIONS ARE EXACT. CONFIRMATION OF EXISTENCE AND EXACT LOCATION OF ALL SERVICES MUST BE OBTAINED FROM THE INDIVIDUAL UTILITIES BEFORE PROCEEDING WITH CONSTRUCTION.	

B.M. ELEV.	
DESIGNED BY	W.O.
CHECKED BY	B.C.
DRAWN BY	W.O.
APPROVED BY	M.H.
HOR. SCALE:	AS NOTED
RELEASED FOR CONSTRUCTION:	
VERTICAL:	
A ISSUED FOR TENDER	10.02.16 WO
NO. REVISIONS	DATE BY
	09.09.21

Stantec Consulting Ltd.
905 Waverley Street, Winnipeg, Manitoba
Tel 204-489-5900 Fax 204-453-9012

ENGINEER'S SEAL

BID OPPORTUNITY NO.
822-2009

THE CITY OF WINNIPEG
WATER AND WASTE DEPARTMENT

Winnipeg

**NORTH END WATER POLLUTION CONTROL FACILITIES
HAULED WASTEWATER RECEIVING FACILITIES
LEACHATE RECEIVING BUILDING
FLOOR PLAN/ROOF PLAN AND EXTERIOR ELEVATIONS**

CITY DRAWING NUMBER
1-0101A-B0004-001

SHEET 1 OF 1

V:\1170\winnipeg\11701830\Drawings\04_A_working\sheet_files\architectural\leachate-rn_01\1830-01.dwg [B0004]
 2010-02-17 08:38AM By: mson