


SITE PLAN
1:250

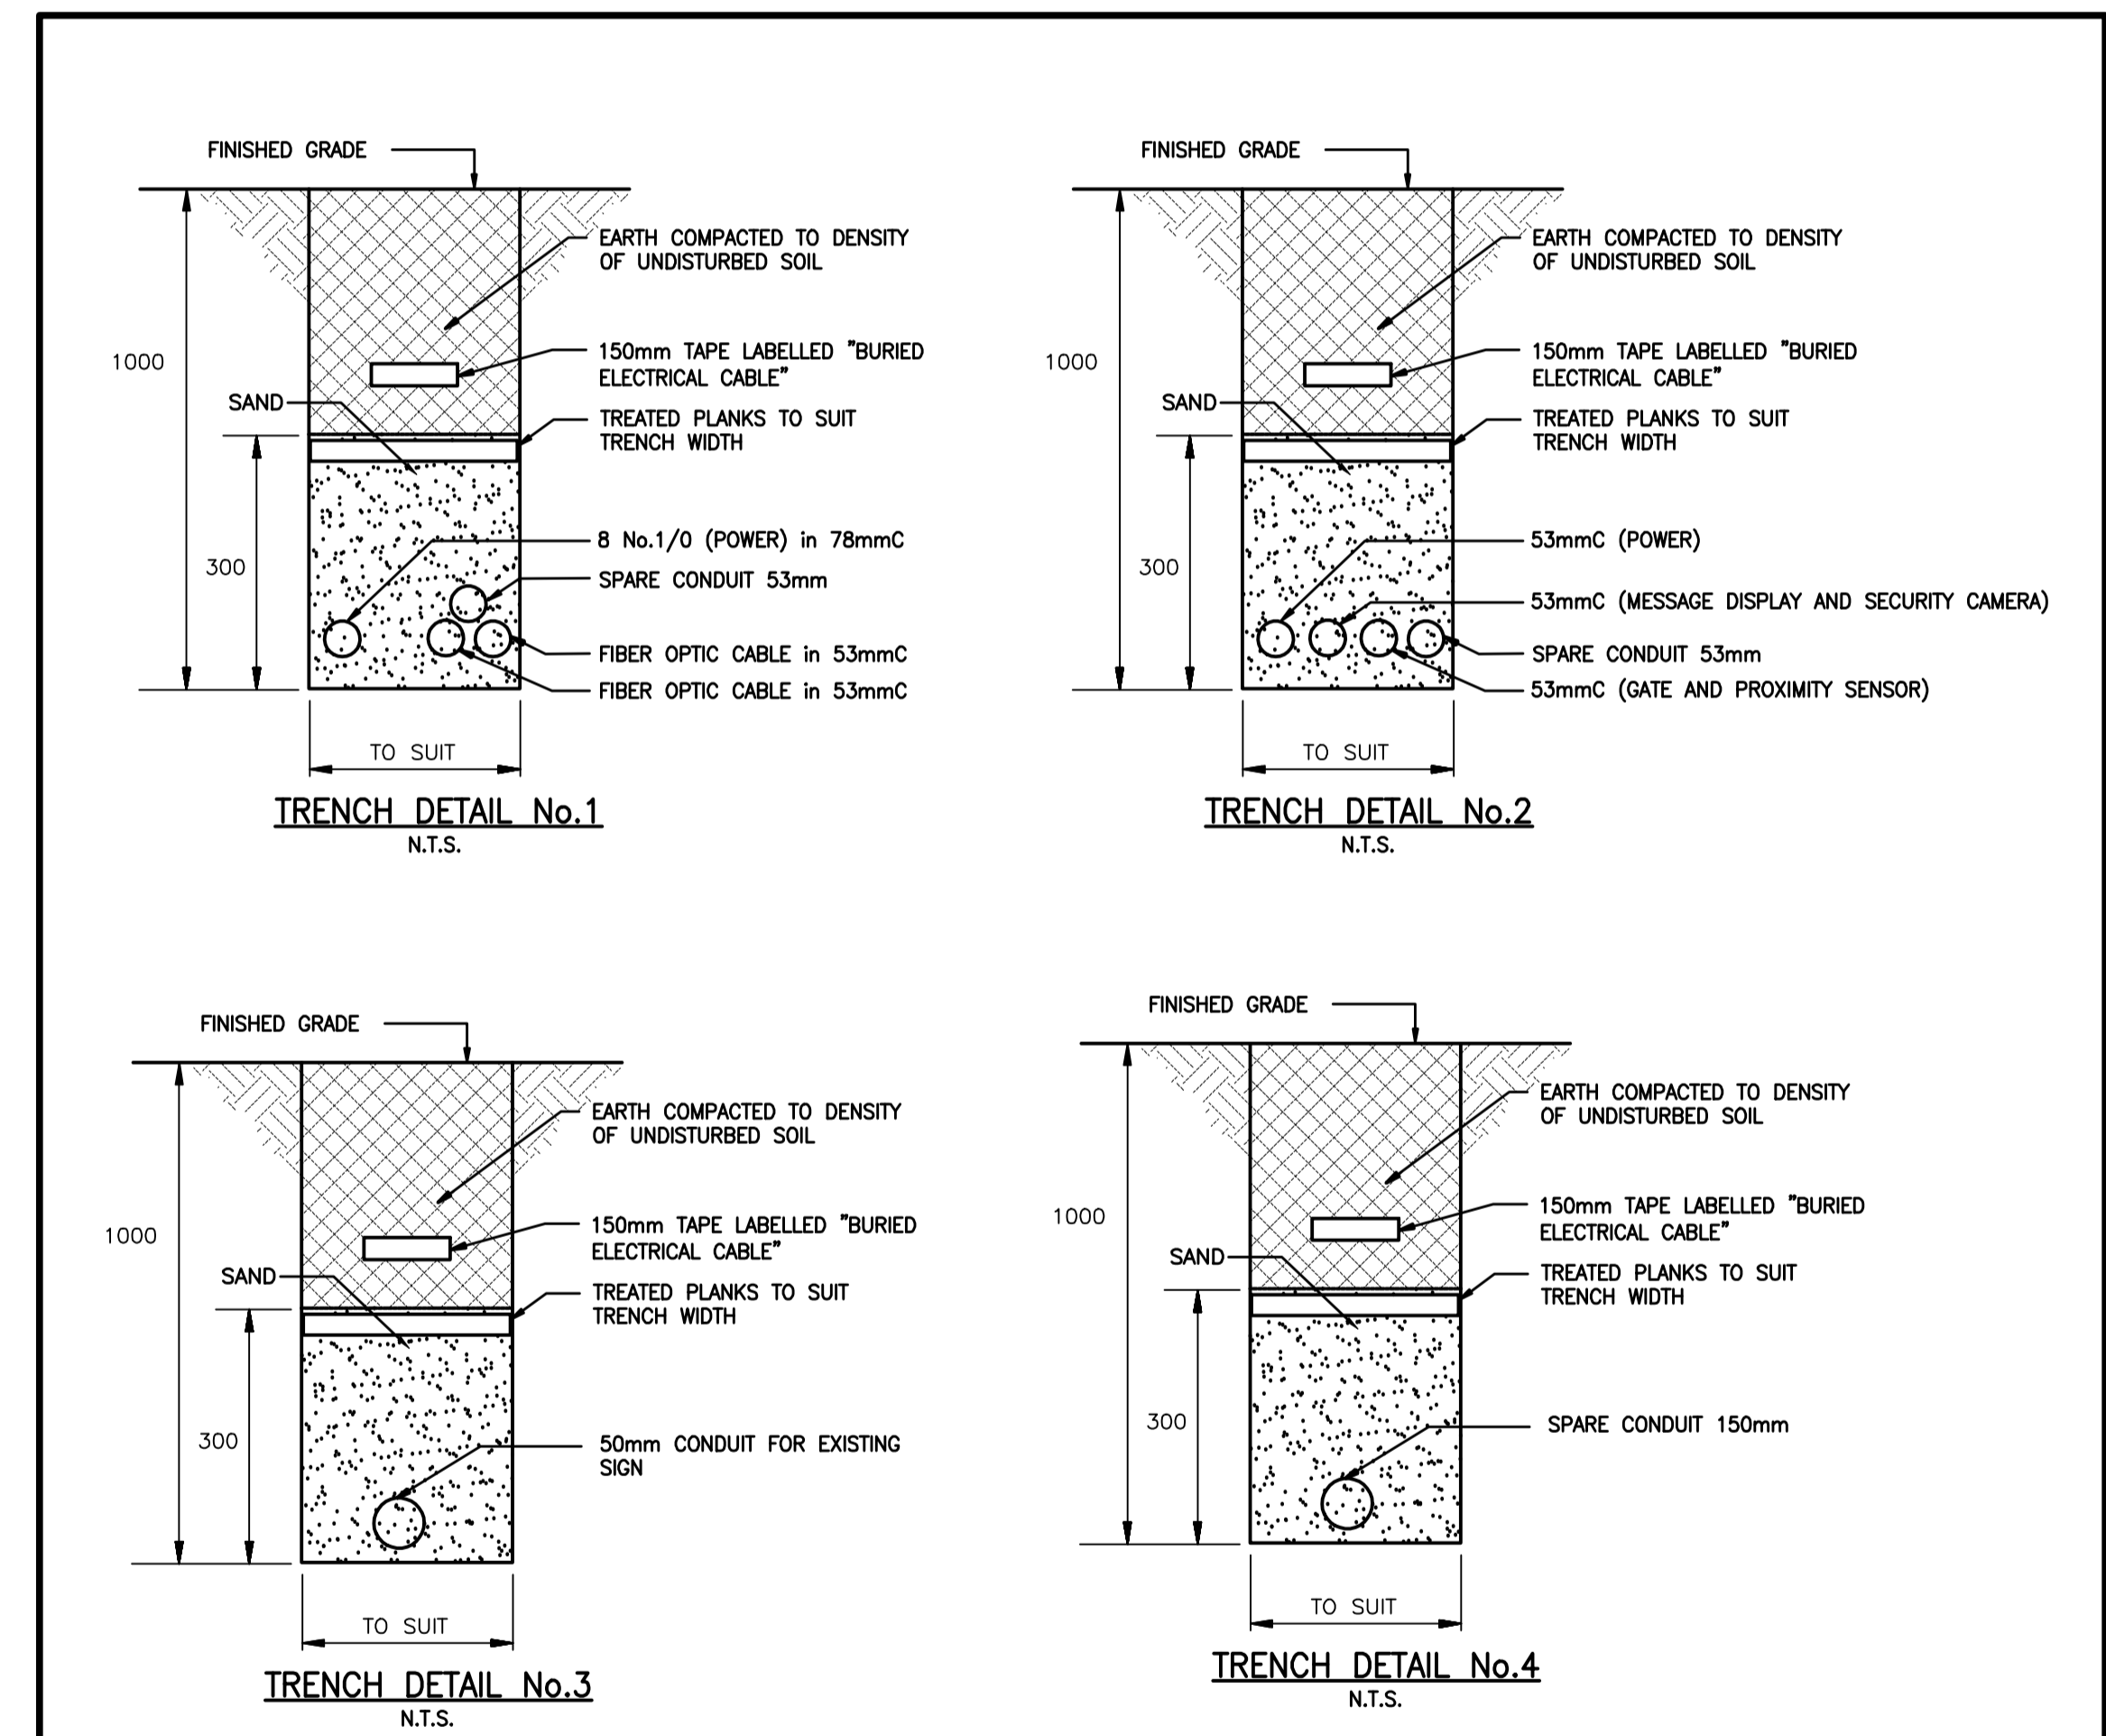

APEGM
Certificate of Authorization
Stantec Consulting Ltd.
No. 1301 Expiry: April 30, 2010

LOCATION APPROVED
UNDERGROUND STRUCTURES

SUPV. U/G STRUCTURES COMMITTEE DATE

NOTE:
LOCATION OF UNDERGROUND STRUCTURES AS SHOWN ARE BASED ON THE BEST INFORMATION AVAILABLE BUT NO GUARANTEE IS GIVEN THAT ALL EXISTING UTILITIES ARE SHOWN OR THAT THE GIVEN LOCATIONS ARE EXACT. CONFIRMATION OF EXISTENCE AND EXACT LOCATION OF ALL SERVICES MUST BE OBTAINED FROM THE INDIVIDUAL UTILITIES BEFORE PROCEEDING WITH CONSTRUCTION.

NO.	REVISIONS	DATE	BY
A	ISSUED FOR TENDER	10.02.16	S.T.

Stantec Consulting Ltd. 905 Waverley Street, Winnipeg, Manitoba Tel 204-489-5900 Fax 204-453-9012		ENGINEER'S SEAL DESIGNED BY S.T. CHECKED BY D.D. DRAWN BY S.T. APPROVED BY -- HOR. SCALE: -- RELEASED FOR CONSTRUCTION: VERTICAL: -- DATE: 09.11.20
---	--	---

TENDER NO. 822-2009

THE CITY OF WINNIPEG
 WATER AND WASTE DEPARTMENT
 SOUTH END WATER POLLUTION CONTROL CENTRE
 HAULED WASTEWATER RECEIVING FACILITIES
 HAULED WASTEWATER RECEIVING BUILDING
 SITE PLAN
 CITY DRAWING NUMBER: 1-0102A-E0014-001
 SHEET 1 OF 1